

PROJECT INFORMATION

THE ESCOFFIER RESIDENCE
492 MESA VIEW WAY
GOLDEN, CO, 80403

DESIGNER INFORMATION

ALHAN VAZQUEZ
313-333-7049
W213333428@STUDENT.HCCS.EDU

DIRECTORY OF SHEETS

- CS-1

- COVER SHEET
- ID-1.1

- 1ST FLOOR PARTITION PLAN
- ID-1.2

- 2ND FLOOR PARTITION PLAN
- ID-1.3

- BASEMENT PARTITION PLAN
- ID-2.1

- ENLARGED IN-LAW SUITE RCP
- ID-3.1

- 1ST FLOOR ELECTRICAL PLAN
- ID-3.2

- 2ND FLOOR ELECTRICAL PLAN
- ID-3.3

- BASEMENT ELECTRICAL PLAN
- ID-4.1

- FINISH PLAN 1ST FLOOR
- ID-4.2

- FINISH PLAN 2ND FLOOR
- ID-4.3

- FINISH PLAN BASEMENT
- ID-5.1

- 1ST FLOOR FURNITURE PLAN
- ID-5.2

- 2ND FLOOR FURNITURE PLAN
- ID-5.3

- BASEMENT FURNITURE PLAN
- ID-6.1

- KITCHEN ELEVATIONS
- ID-6.2

- KITCHEN ISLAND ELEVATIONS
- ID-6.3

- CLOSET, PANTRY, POWDER ROOM ELEVATIONS
- ID-7.1

- CABINETRY SECTIONS
- ID-7.2

- 2ND FLOOR BEDROOM SECTIONS
- ID-7.3

- HIDDEN PANEL WALL SECTIONS
- ID-7.4

- CHILDREN'S BEDROOM SECTIONS
- ID-8.1


- MATERIAL FINISH SCHEDULE
- ID-9.1

- FURNITURE SCHEDULE
- ID-10.1

- 1ST FLOOR RCP
- ID-10.2

- 2ND FLOOR RCP
- ID-10.3

- BASEMENT RCP

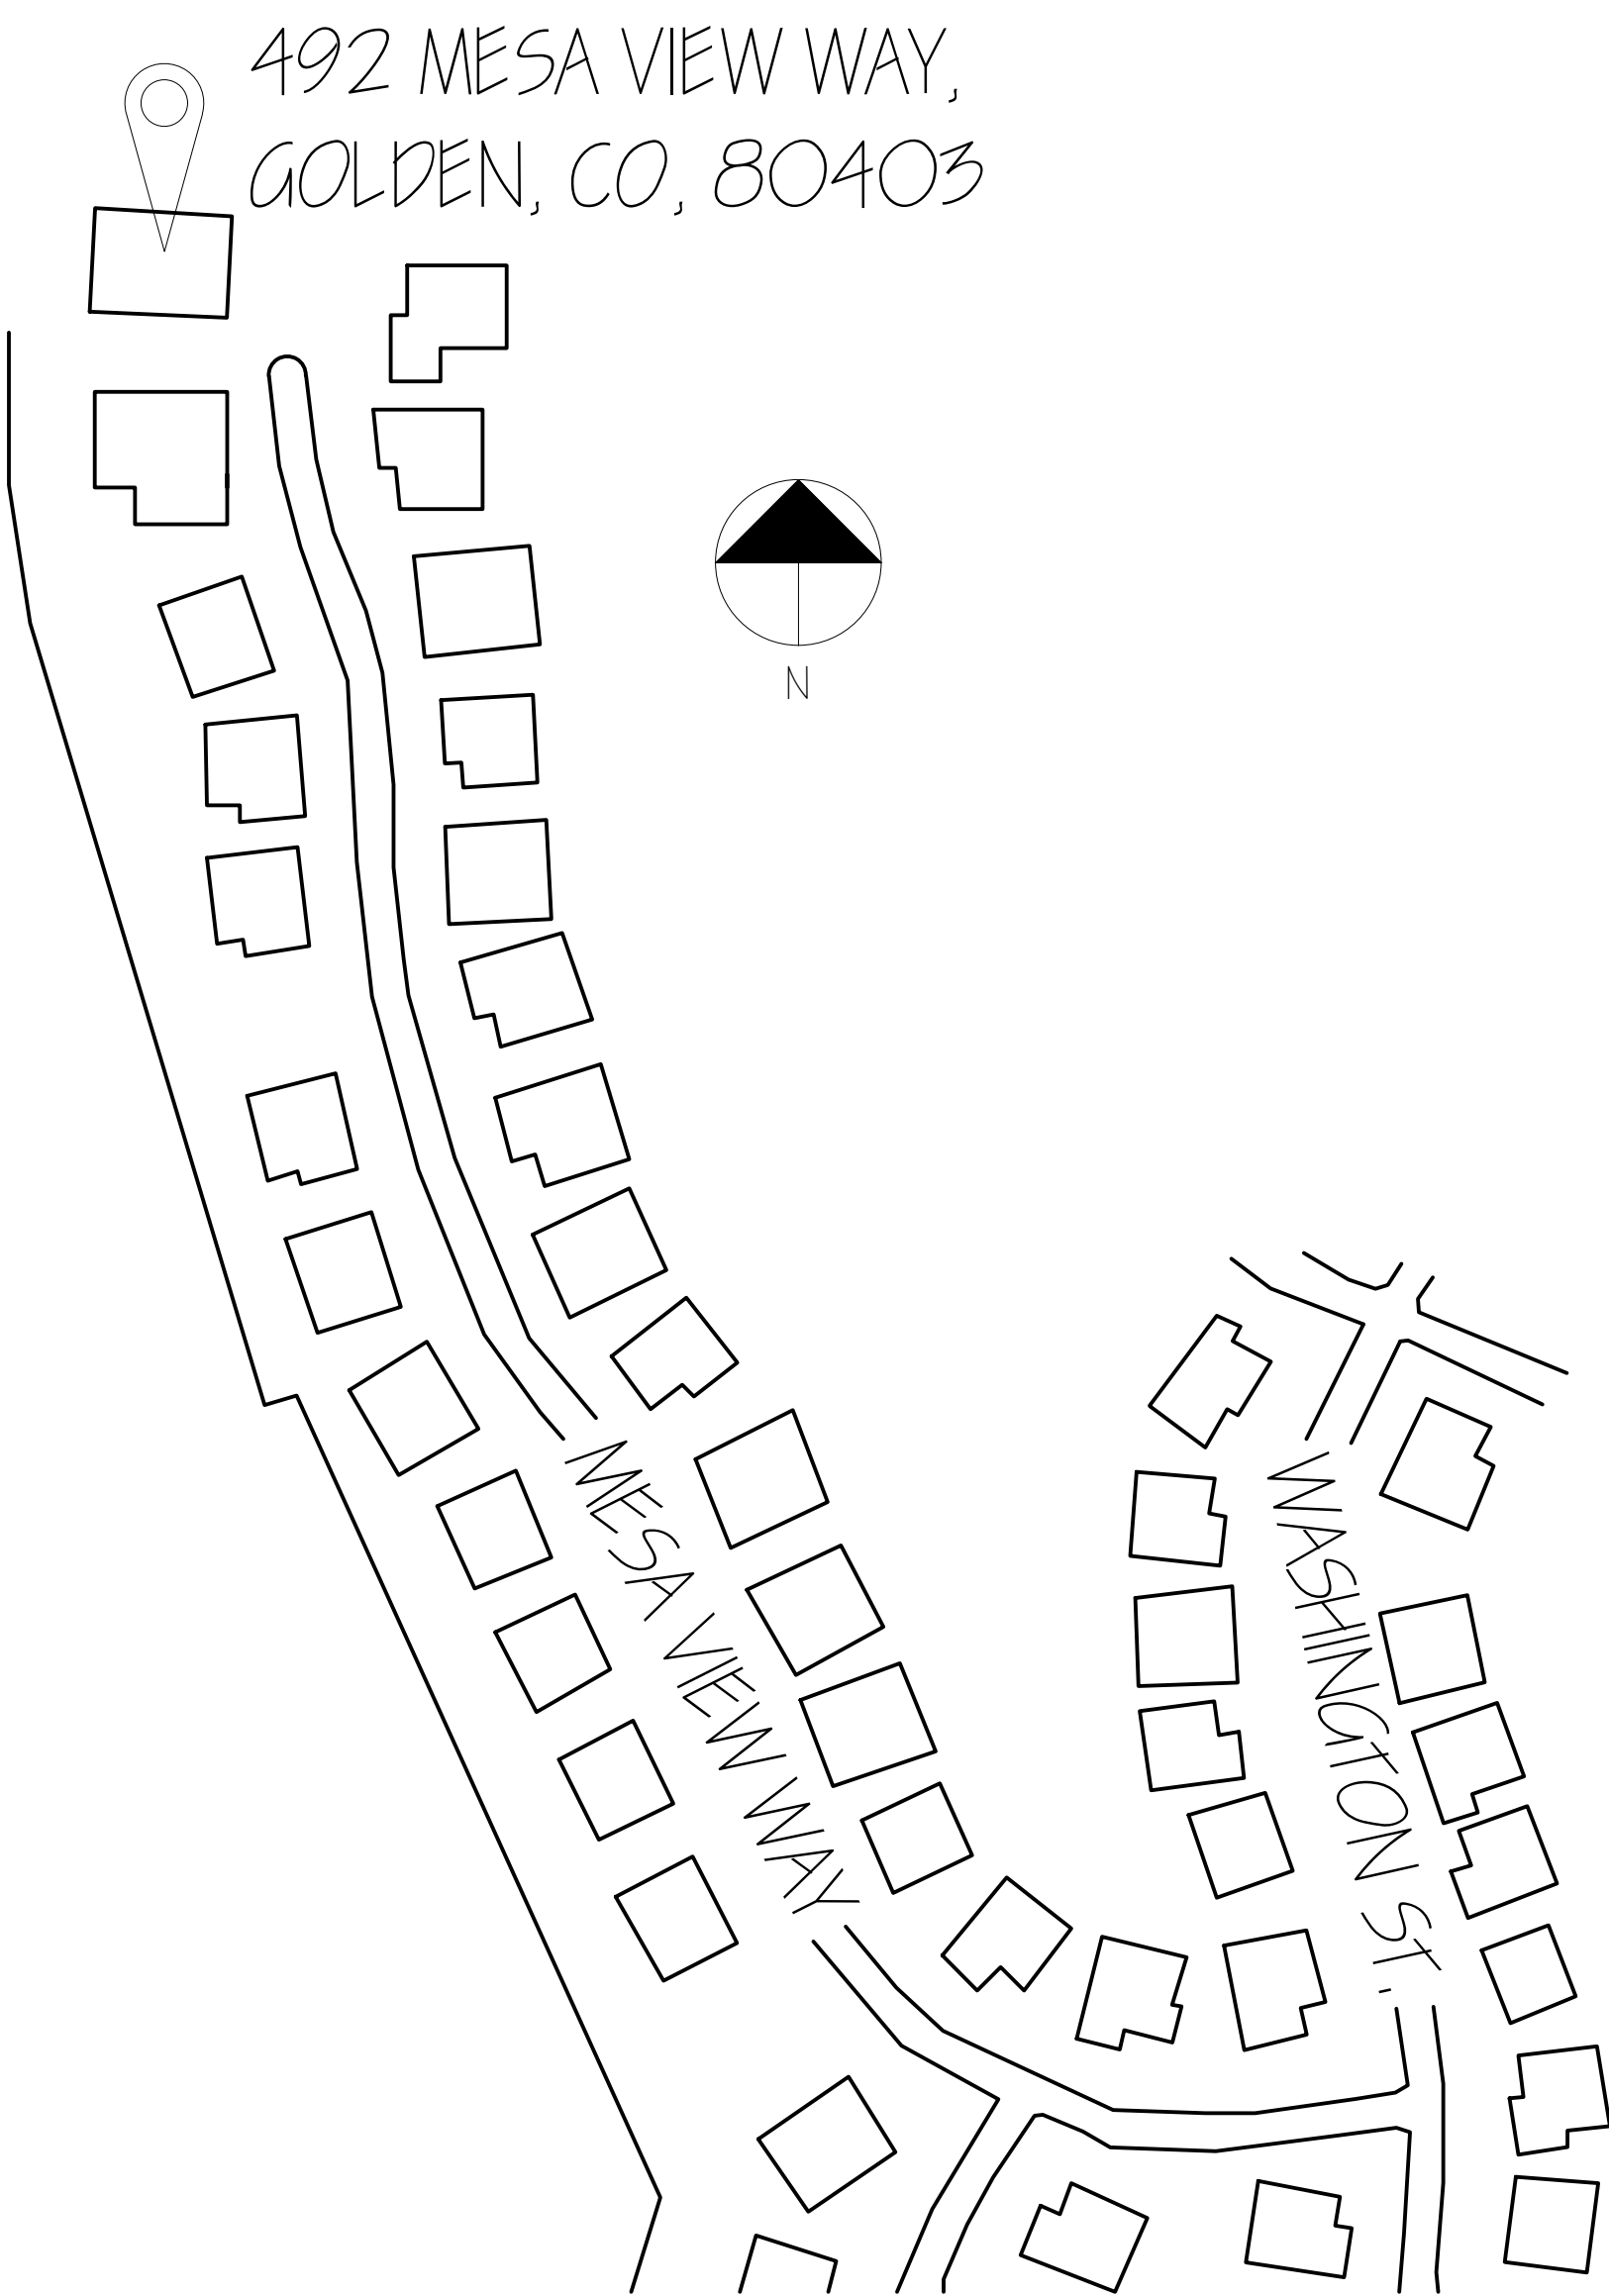

DIRECTORY OF SYMBOLS

ELEVATION CALL OUT

NORTH ARROW

WALL / CUT

IDENTIFICATION LABEL

ENLARGEMENT INDICATOR

DETAIL / SECTION DETAIL

VISIBLE OBJECT LINE

HIDDEN LINE

CUTTING PLANE

DIMENSION LINE

FINISHES DIRECTION ARROW

CEILING HEIGHT CHANGE CALLOUT



PROJECT:
RESIDENTIAL COURSE PROJECT
THE ESCOFFIER RESIDENCE

RESIDENTIAL DESIGN
INDS 2313


REVISIONS:		
6		
5		
4		
3		
2		
1		

DATE: NOV 5TH, 2024

DRAFTED BY:
ALHAN VAZQUEZ

SHEET CONTENTS:
COVER SHEET

SHEET:
CS-1

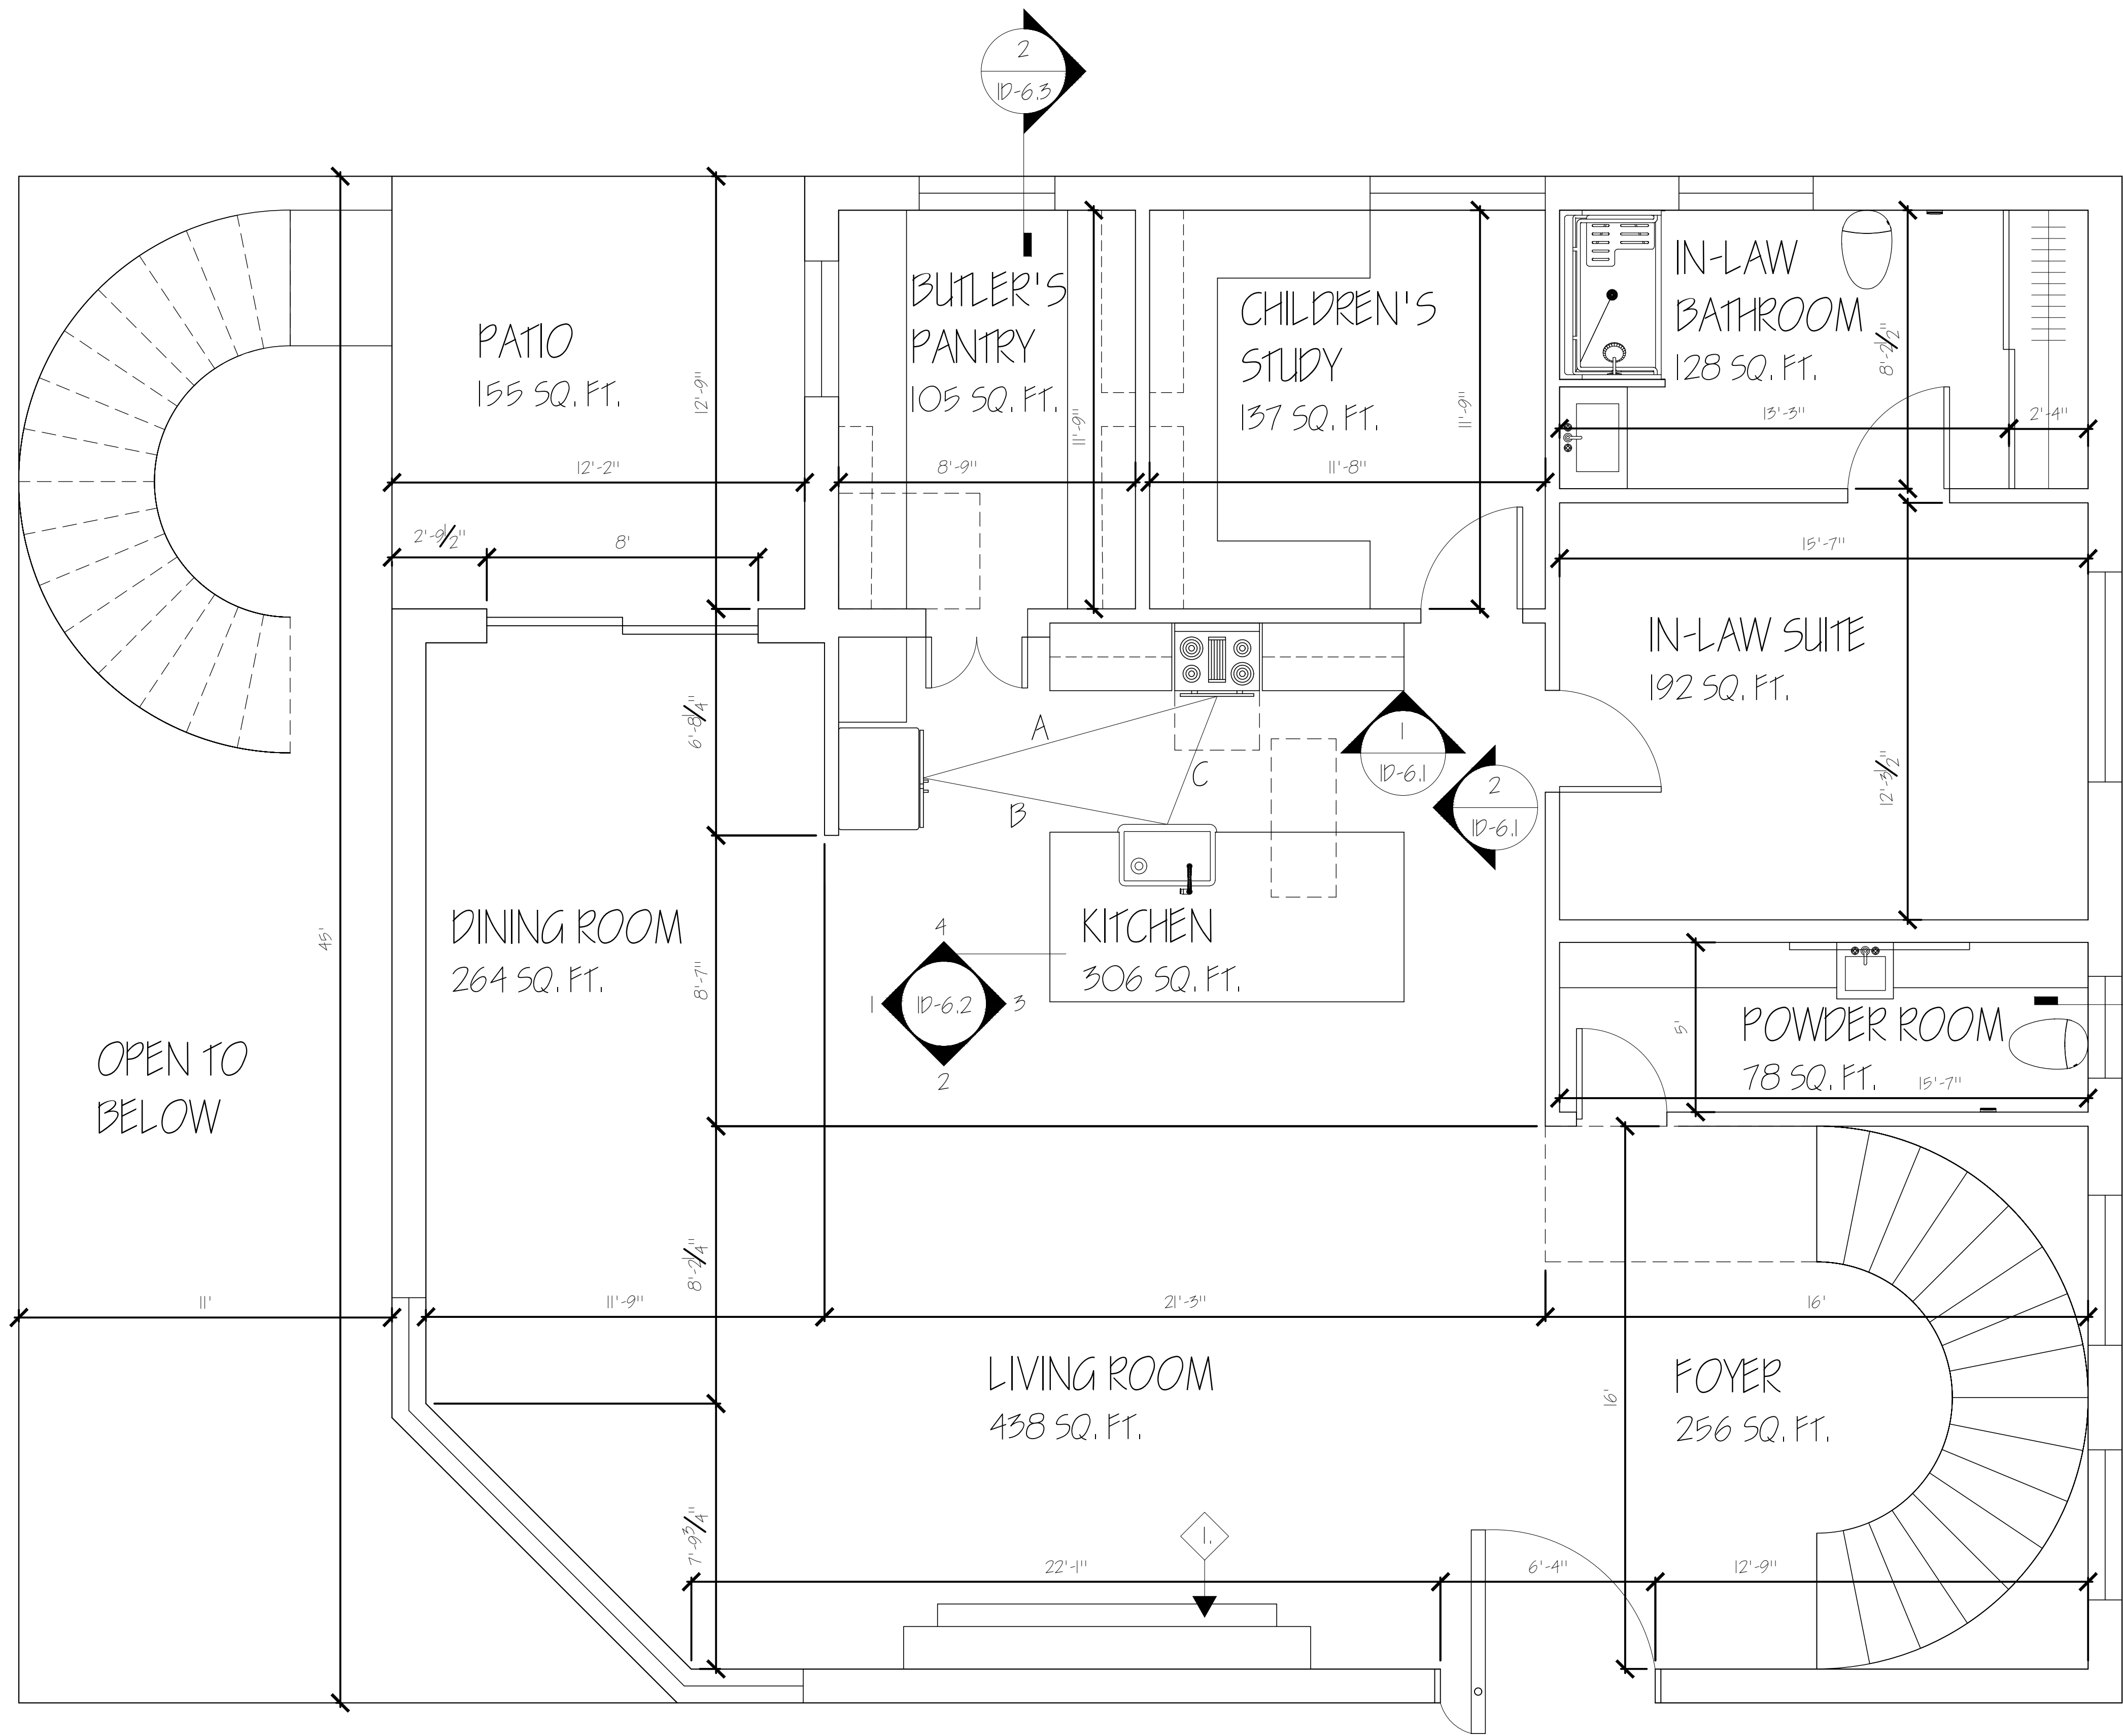

GENERAL NOTES

- ALL CEILING HEIGHTS ARE TO BE 9'-0" U.N.O.
- ALL EXTERIOR WALLS ARE 12" IN THICKNESS.
- ALL INTERIOR WALLS ARE 5" IN THICKNESS.
- ALL INTERIOR PLUMBING WALLS ARE 8" IN THICKNESS.
- DO NOT SCALE THE DRAWING.
- ALL INTERIOR ROOM DOOR CLEARANCES ARE 36" WIDE U.N.O.
- THE FRONT PIVOT DOOR HAS A CLEARANCE OF 64" WIDE.
- FOR ROOM FINISHES REFER TO 1ST FLOOR FINISH PLAN ID-4.1
- IN-LAW BATHROOM HAS ADA WHEELCHAIR ROTATION CLEARANCE.
- IN-LAW BATHROOM SHOWER IS WHEELCHAIR ROLL-IN ACCESSIBLE.
- IN-LAW BATHROOM HAS NON-SLIP TILE FLOORING.
- THE WORKING TRIANGLE IN THE KITCHEN IS COMPOSED OF SEGMENTS A, B AND C.
- TRIANGLE SEGMENT A MEASURES 8'-11 ³/₁₆" , SEGMENT B MEASURES 7'-3 ¹³/₁₆" , AND SEGMENT C MEASURES 4'-0 ⁹/₁₆" .
- FOR ALL FOUR KITCHEN ISLAND ELEVATIONS REFER TO ID-6.2

PLAN NOTES

- 1. THE FIREPLACE FROM 1ST FLOOR UP TO HOUSE CEILING ROOF.



RESIDENTIAL COURSE PROJECT
THE ESCOFFIER RESIDENCE

RESIDENTIAL DESIGN
INDS 2313


REVISIONS:		
6		
5		
4		
3		
2		
1		

DATE: NOV 5TH, 2024

DRAFTED BY:
ALHAN VAZQUEZ

SHEET CONTENTS:
PARTITION PLAN
1ST FLOOR

SHEET:
ID-1.1

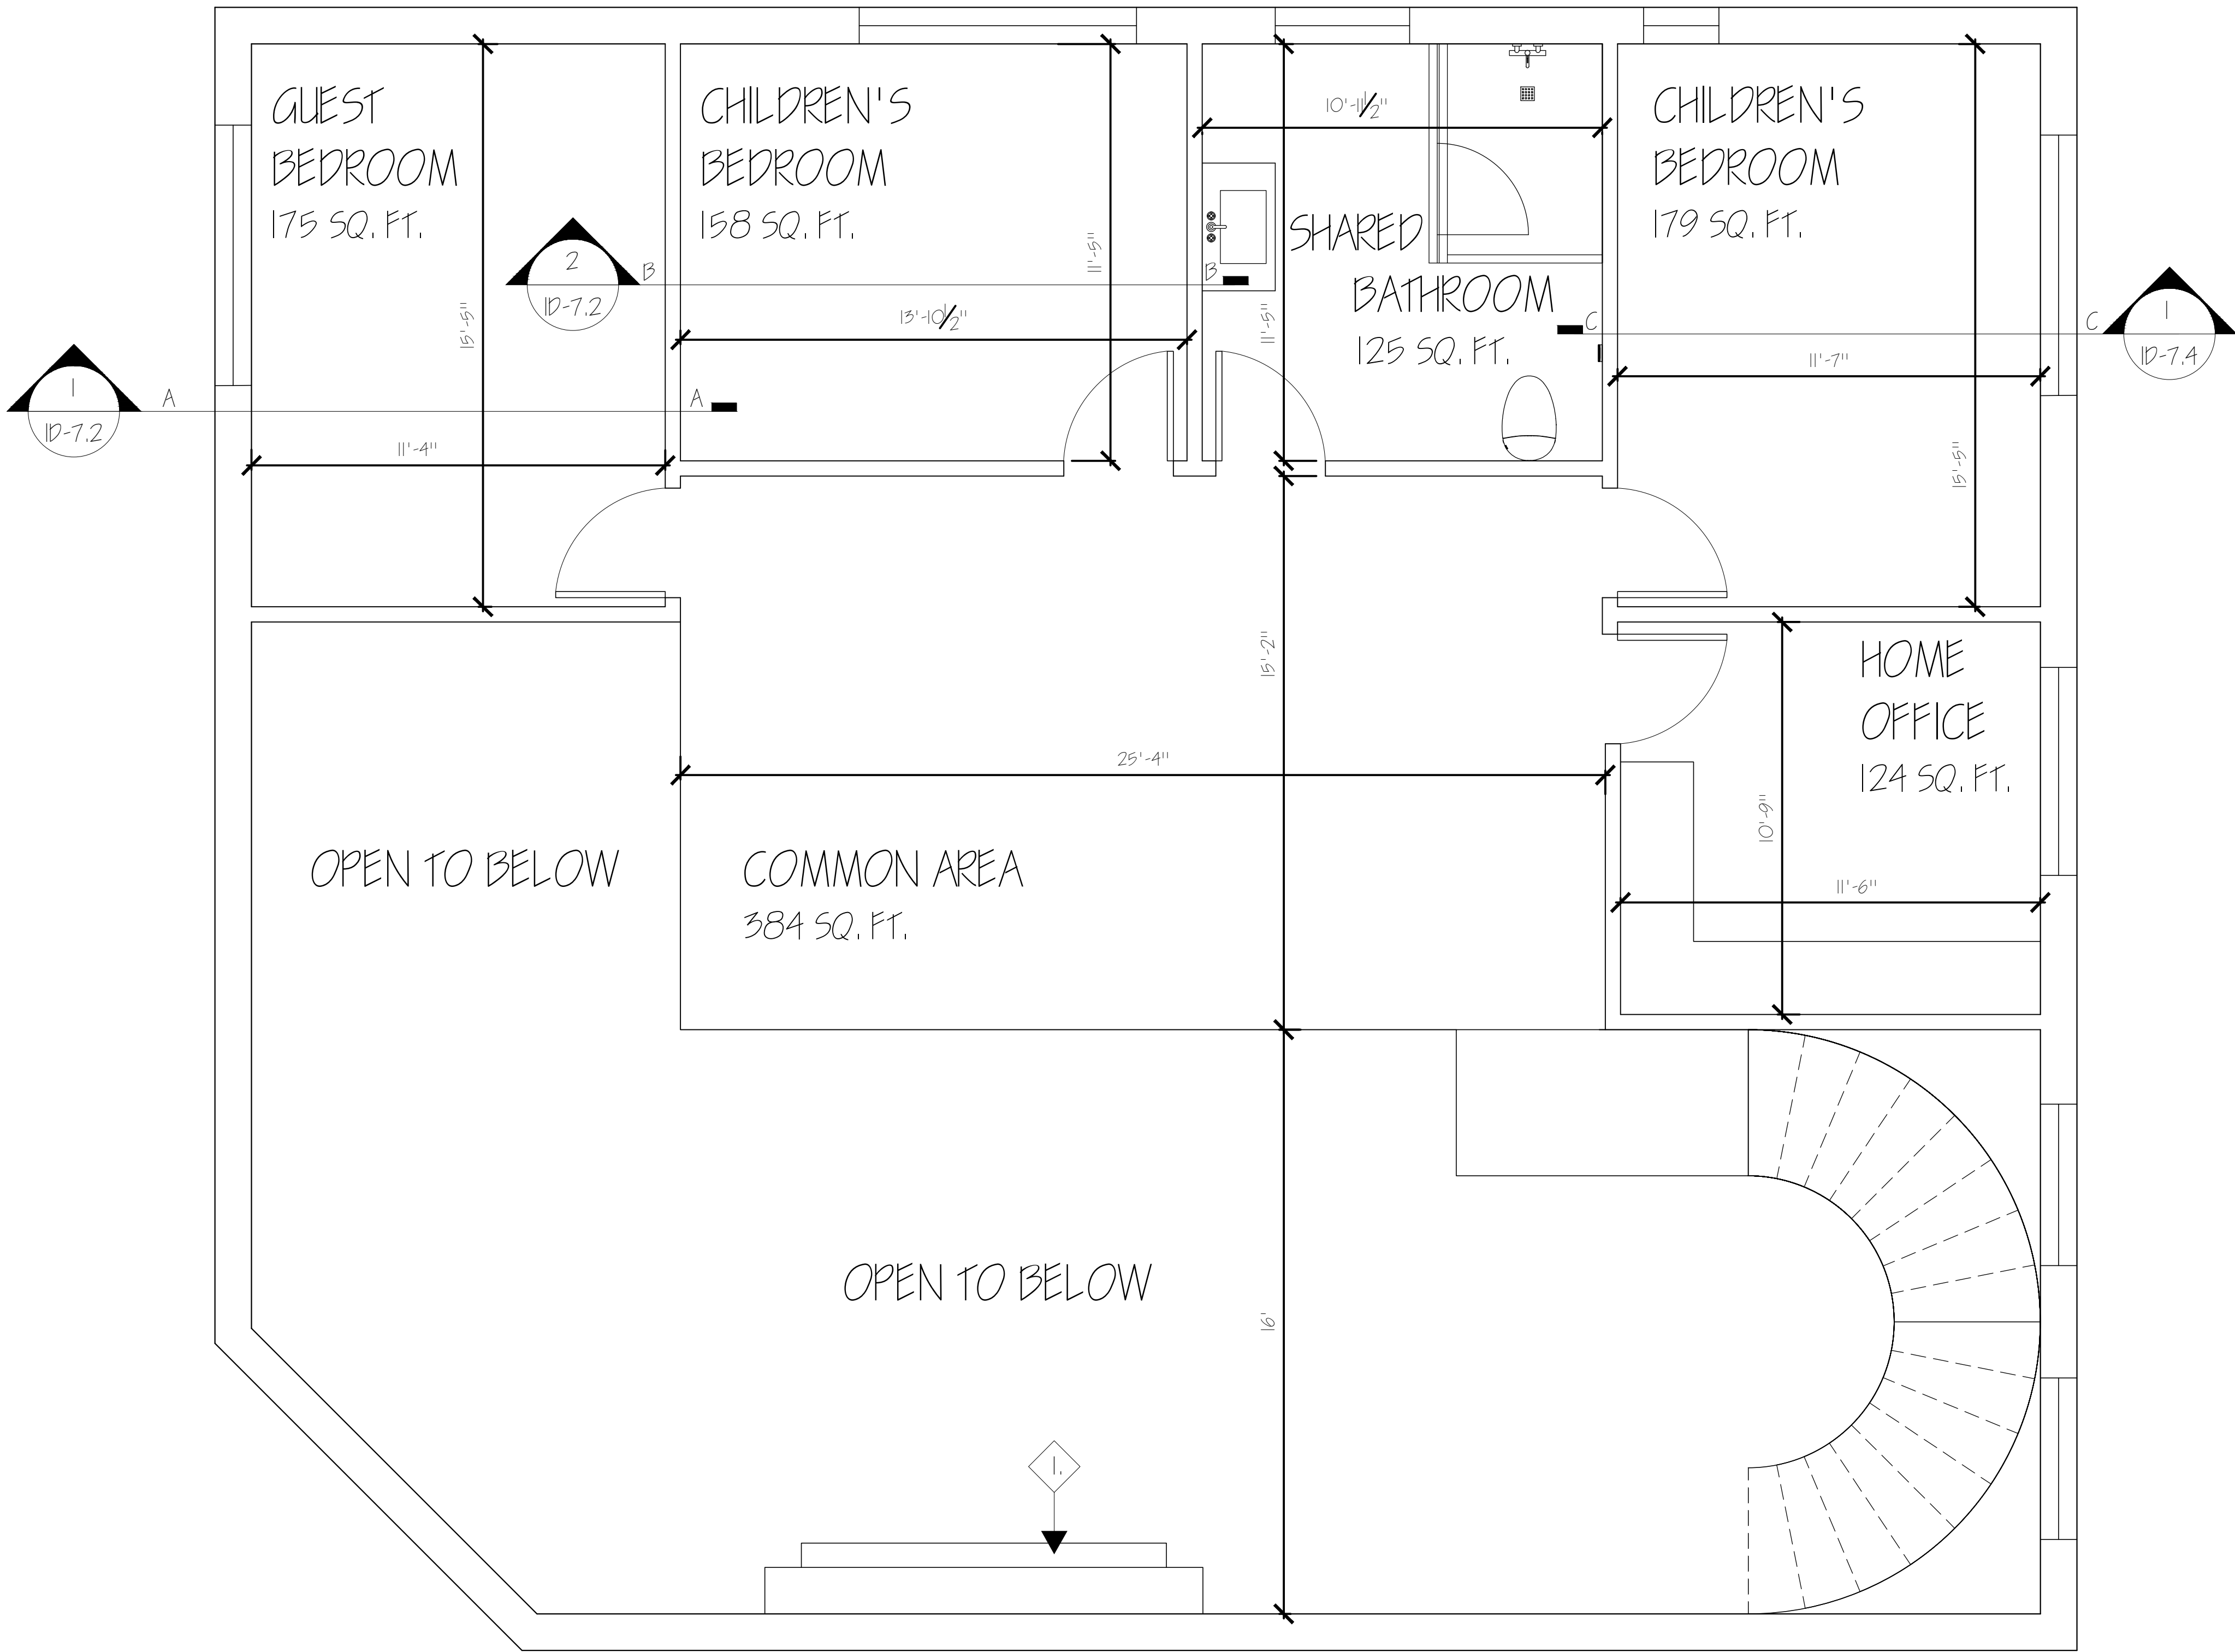


GENERAL NOTES

- FOR CEILING HEIGHTS REFER TO 2ND FLOOR RCP ID-10.2.
- ALL EXTERIOR WALLS ARE 12" IN THICKNESS.
- ALL INTERIOR WALLS ARE 5" IN THICKNESS.
- ALL INTERIOR PLUMBING WALLS ARE 8" IN THICKNESS.
- DO NOT SCALE THE DRAWING.
- ALL INTERIOR ROOM DOOR CLEARANCES ARE 36" WIDE U.N.O.
- FOR ROOM FINISHES REFER TO 1ST FLOOR FINISH PLAN ID-4.1
- SHARED BATHROOM HAS NON-SLIP TILE FLOORING.
- FOR BEDROOM SECTION VIEWS REFER TO BEDROOM FURNISHED SECTIONS ID-7.2 AND ID-7.4

PLAN NOTES

1. THE FIREPLACE FROM 1ST FLOOR UP TO HOUSE CEILING ROOF.

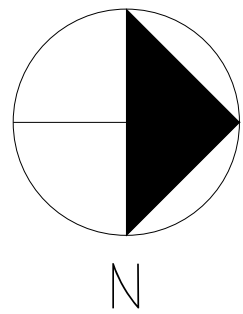

1 2ND FLOOR PARTITION PLAN
SCALE: $\frac{1}{4}" = 1'-0"$



PROJECT:
RESIDENTIAL COURSE PROJECT
THE ESCOFFIER RESIDENCE

RESIDENTIAL DESIGN

INDS 2313

REVISIONS:

6		
5		
4		
3		
2		
1		

DATE: NOV 5TH, 2024

DRAFTED BY:


ALHAN VAZQUEZ

SHEET CONTENTS:

PARTITION PLAN
2ND FLOOR


SHEET:

ID-1.2

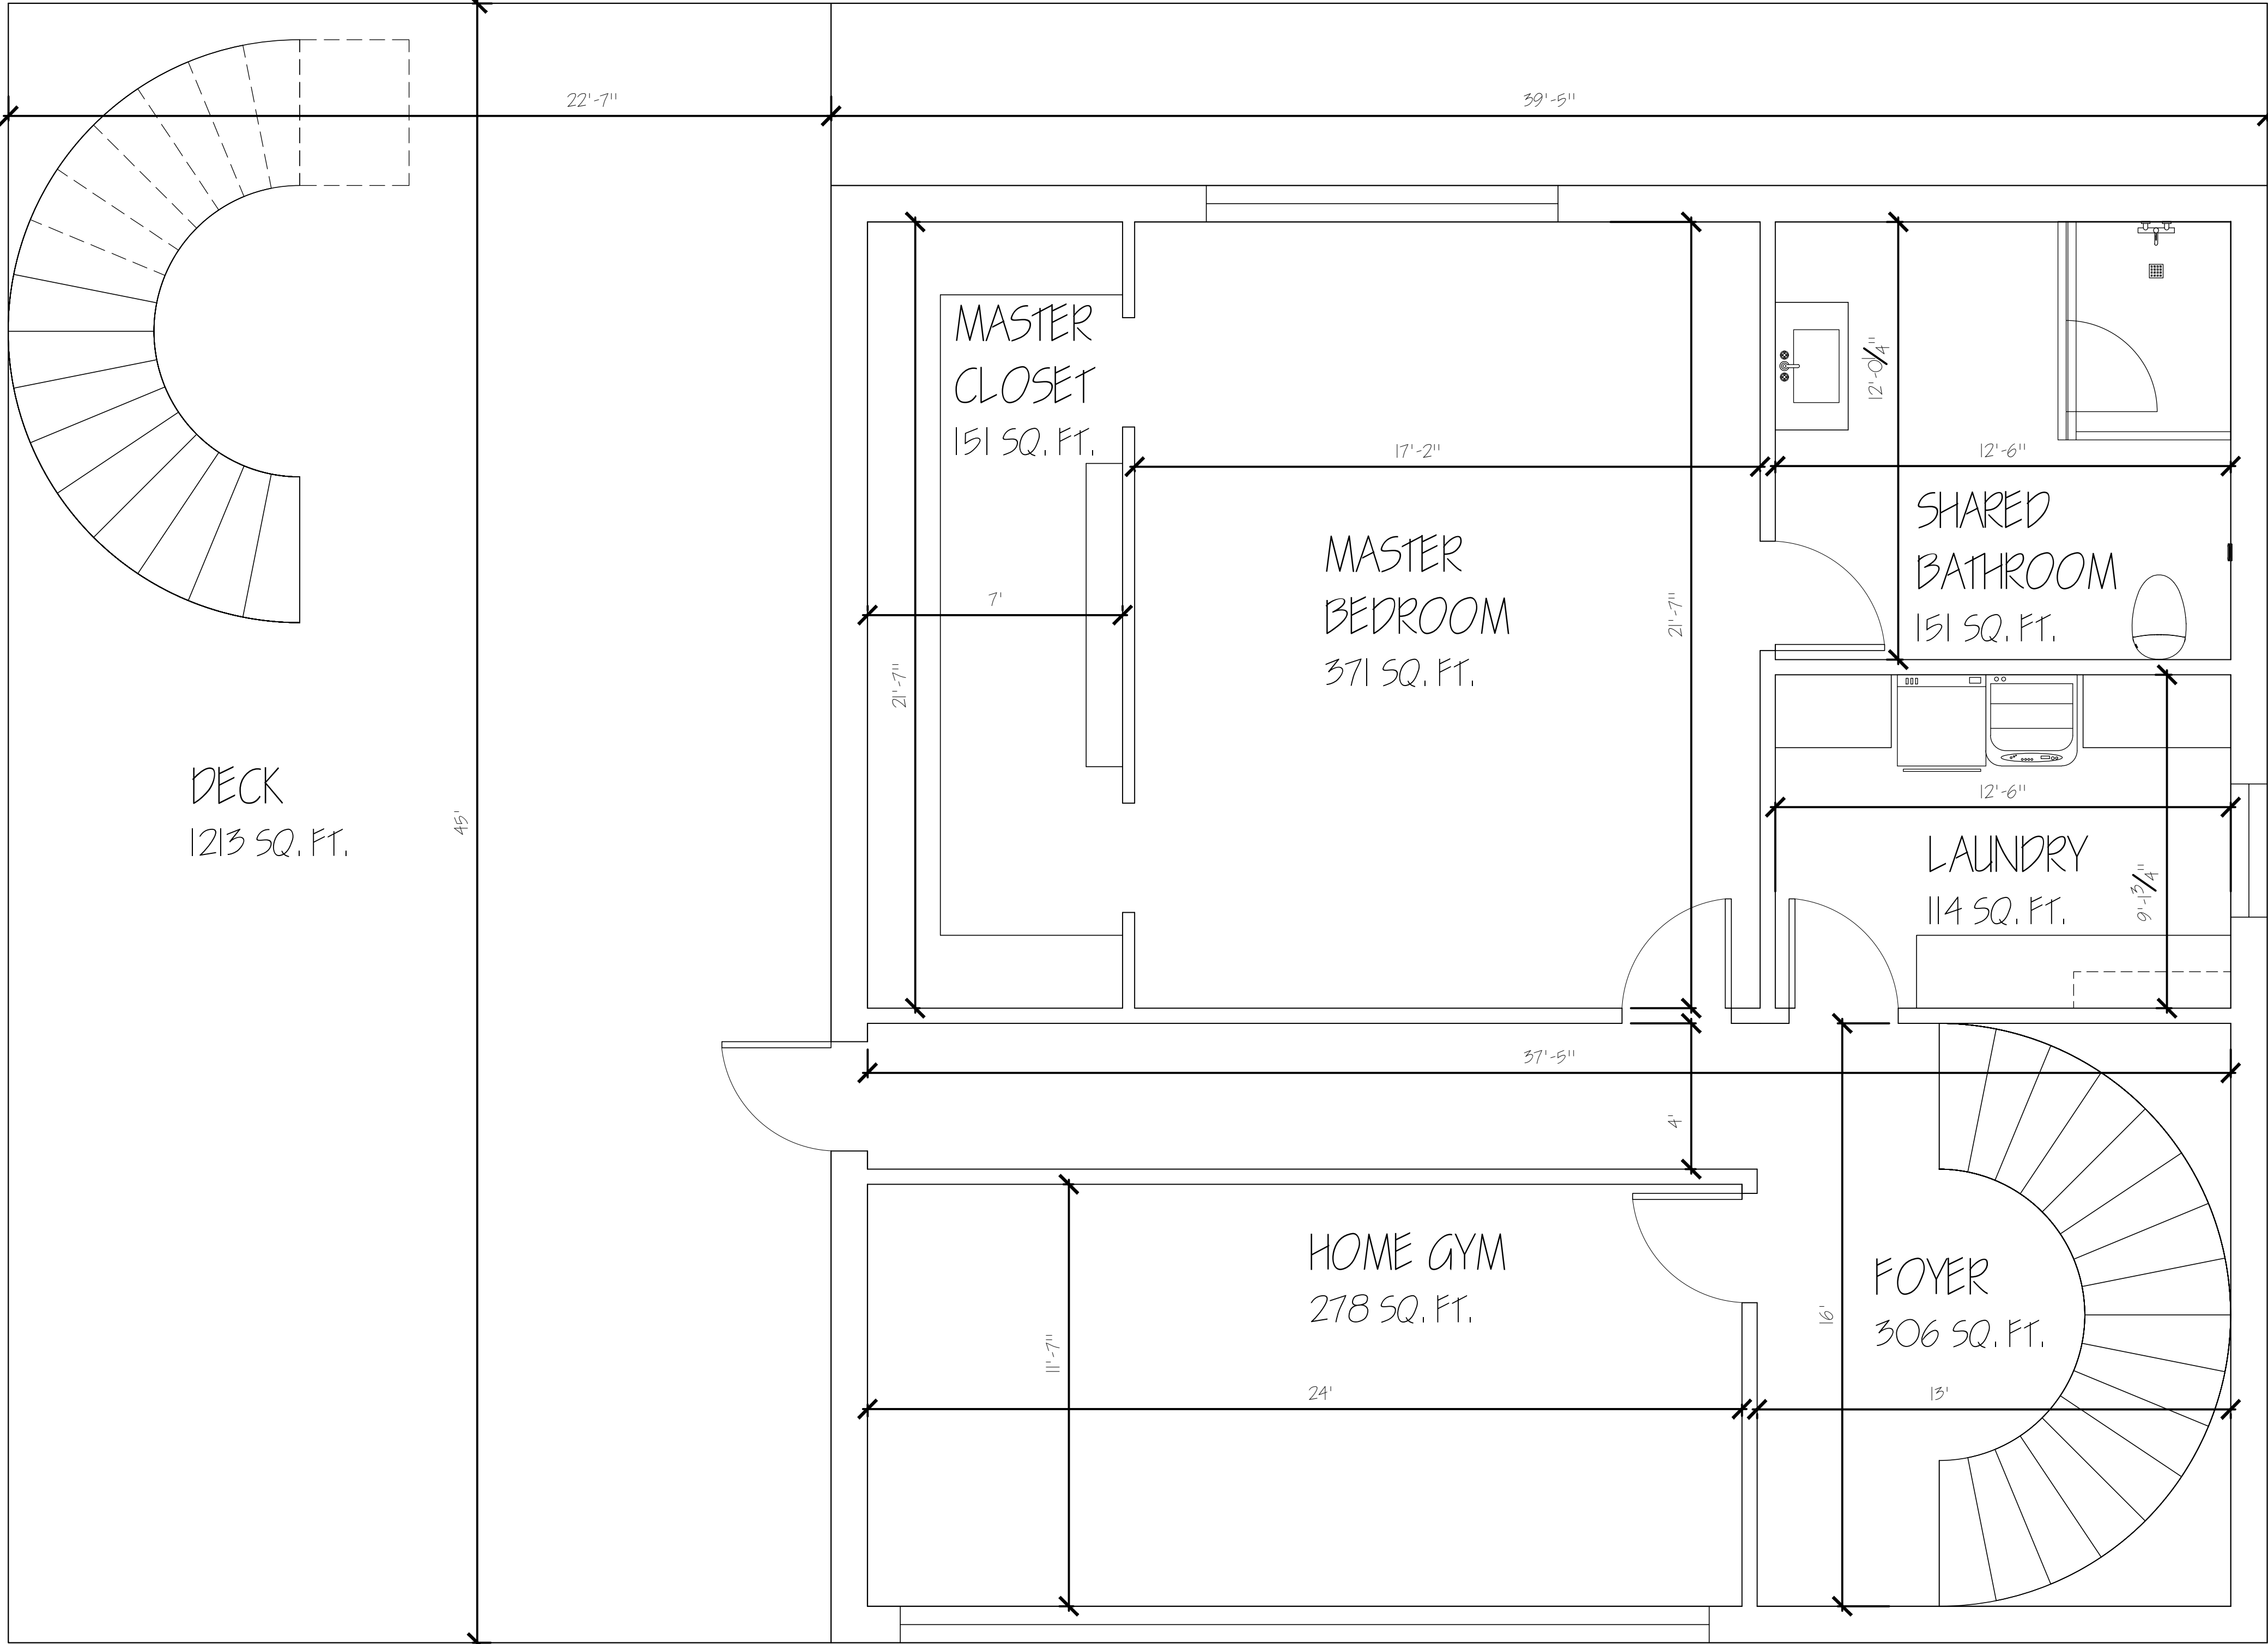

GENERAL NOTES

- FOR CEILING HEIGHTS REFER TO 2ND FLOOR RCP ID-10.2.
- ALL EXTERIOR WALLS ARE 12" IN THICKNESS.
- ALL INTERIOR WALLS ARE 5" IN THICKNESS.
- ALL INTERIOR PLUMBING WALLS ARE 8" IN THICKNESS.
- DO NOT SCALE THE DRAWING.
- ALL INTERIOR ROOM DOOR CLEARANCES ARE 36" WIDE U.N.O.
- FOR ROOM FINISHES REFER TO 1ST FLOOR FINISH PLAN ID-4.1
- MASTER BATHROOM HAS NON-SLIP TILE FLOORING.

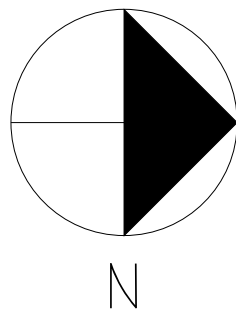

1 BASEMENT PARTITION PLAN
SCALE: 1/4" = 1'-0"

RESIDENTIAL COURSE PROJECT
THE ESCOFFIER RESIDENCE

PROJECT:
RESIDENTIAL DESIGN
INDS 2313

REVISIONS:

6		
5		
4		
3		
2		
1		

DATE: NOV 5TH, 2024

DRAFTED BY:


ALHAN VAZQUEZ

SHEET CONTENTS:

PARTITION PLAN
BASEMENT

SHEET:

ID-1.3

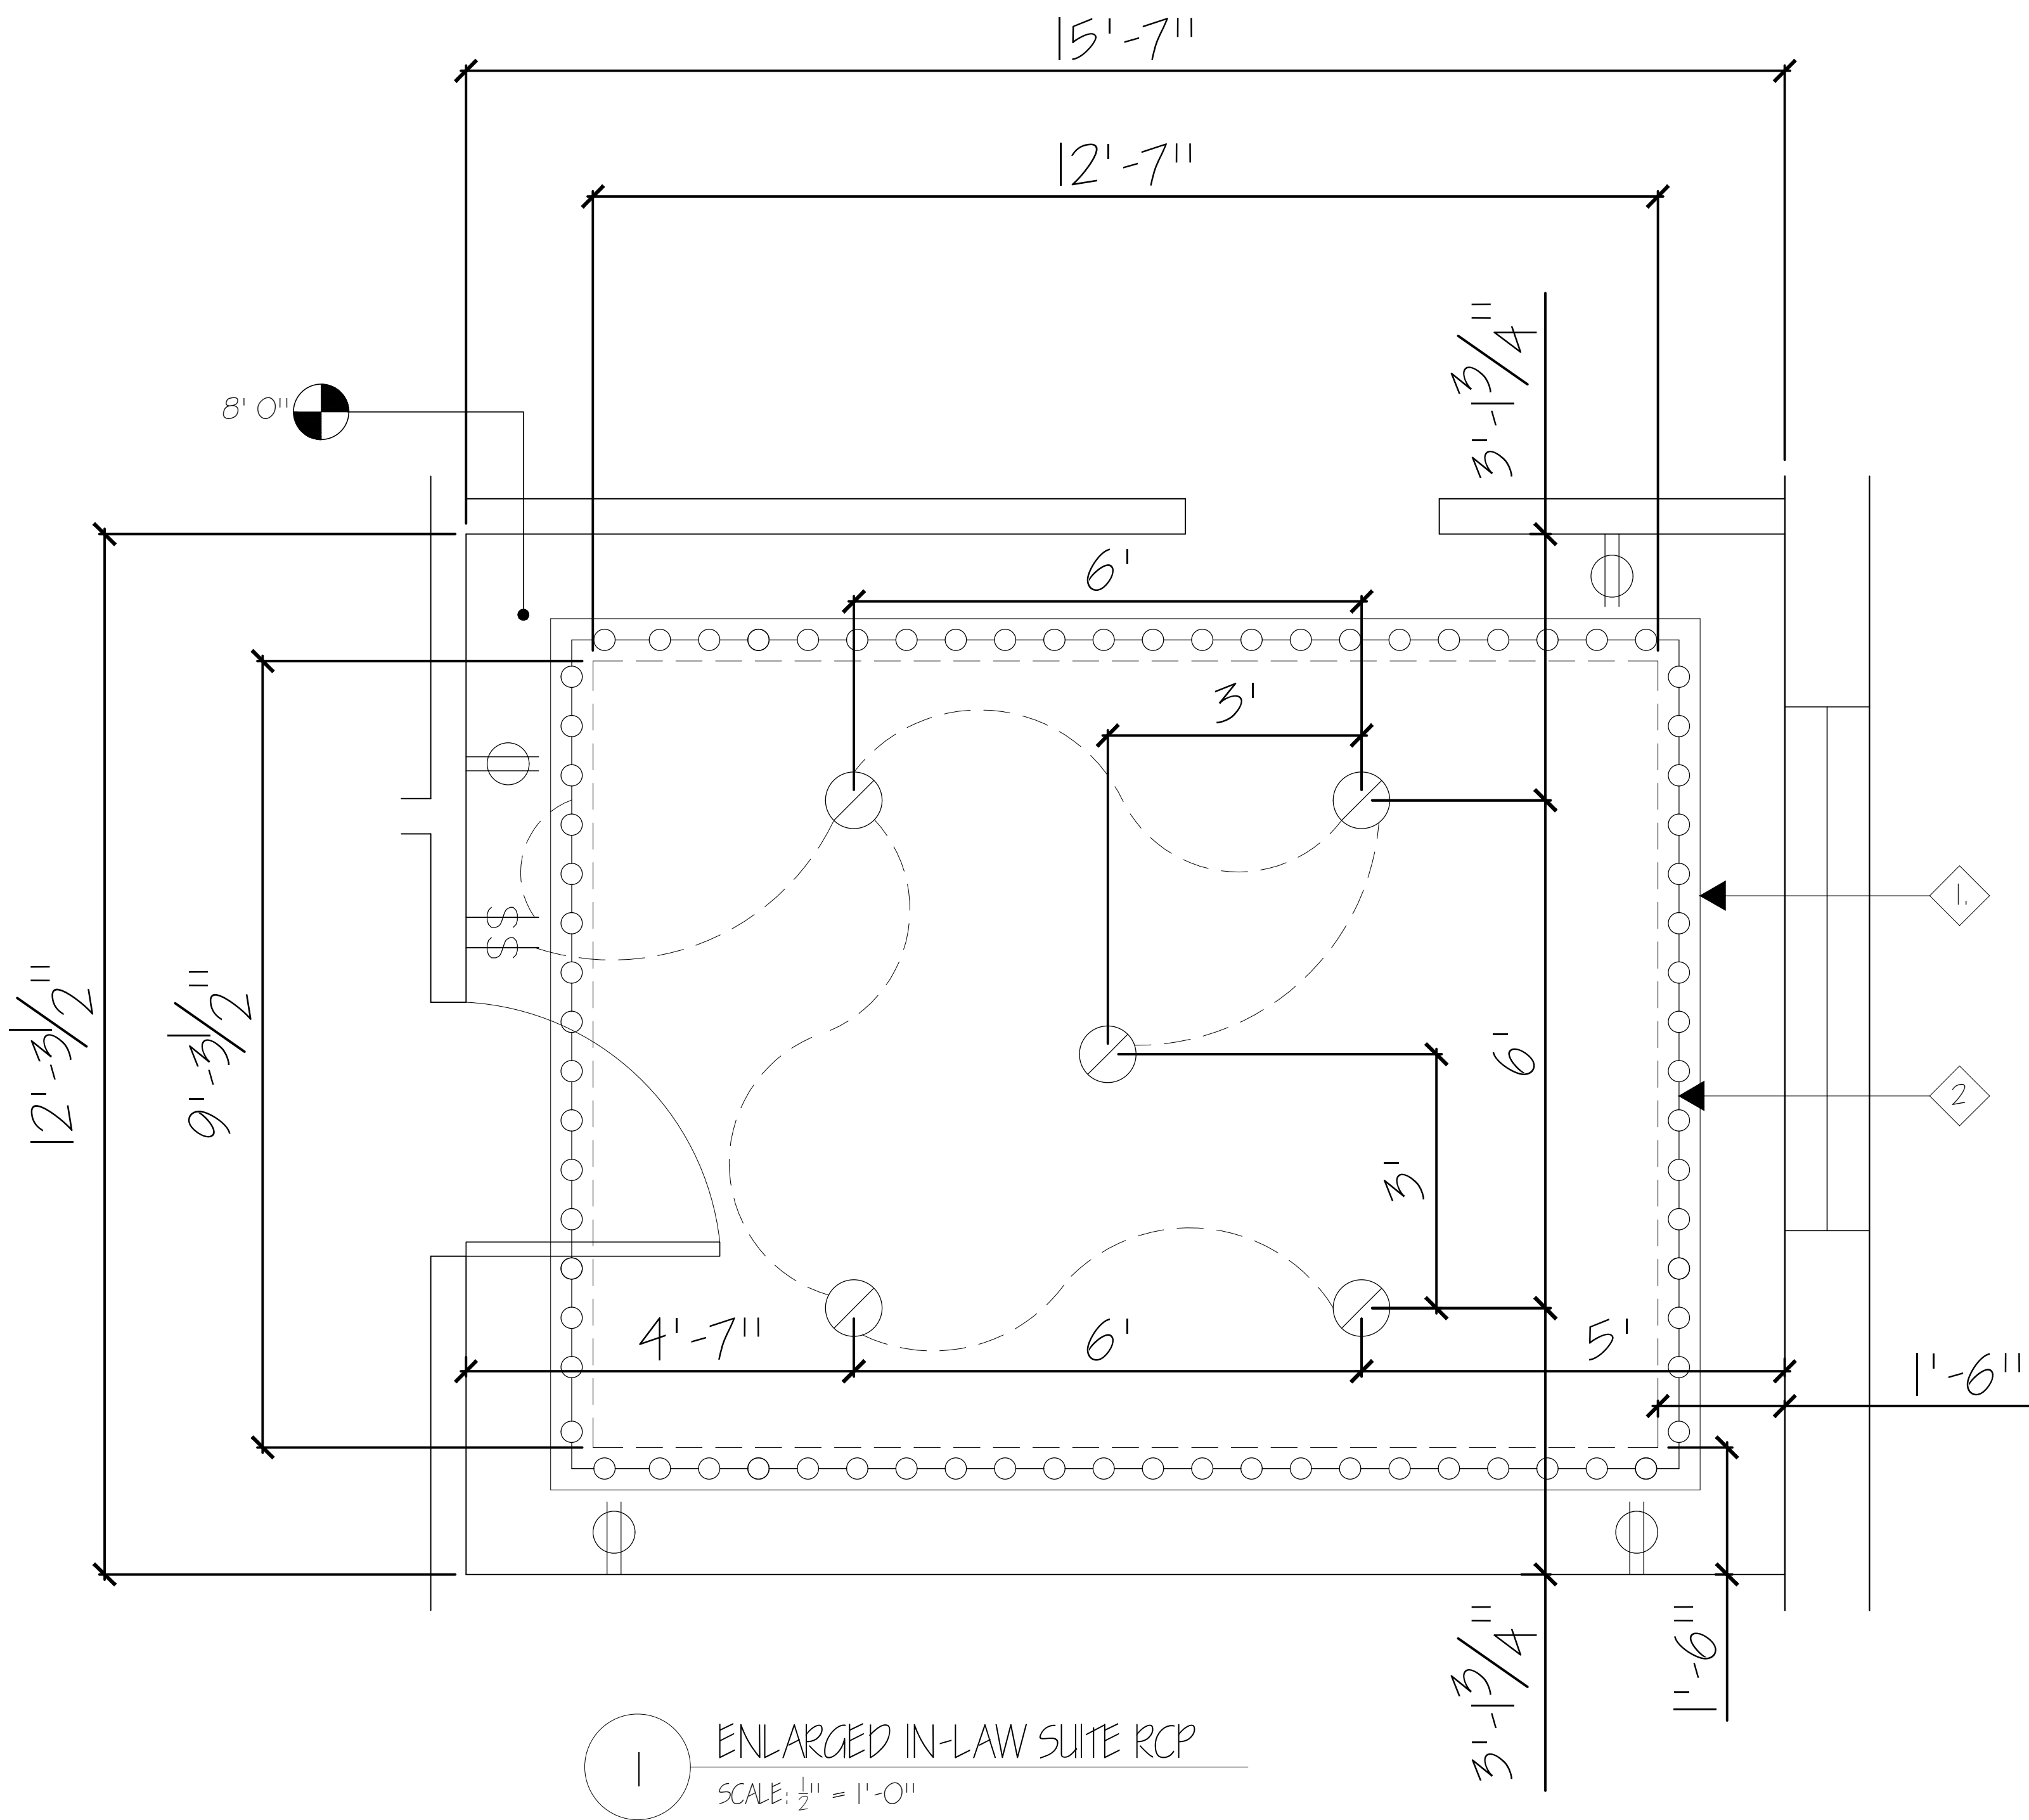


GENERAL NOTES

- ALL DIMENSIONS ARE TO THE CENTERLINE OF FIXTURE, U.N.O.
- REFER TO MANUFACTURER INSTALLATION INSTRUCTIONS FOR LIGHT FIXTURES AND LAMP CONFIGURATIONS.
- ALL CEILING HEIGHTS TO BE 9'-0", U.N.O.
- ALL OUTLETS ARE AT 15" FROM THE FLOOR U.N.O.
- ALL CEILING TO BE DONE IN A WHITE PLASTER FINISH U.N.O.

PLAN NOTES

1. HEIGHT ENCOMPASSING COVE LIGHTING SET AT 9'-0", U.N.O.
2. COVE LIGHTING SPACED AT 3" FROM CEILING CAVITY.

RCP FIXTURE LEGEND	
ITEM	DESCRIPTION
⊙	6" RECESSED LIGHT
○-○-○-○	COVE LIGHTING
\$	LIGHT SWITCH
⌘	DUPLEX OUTLET

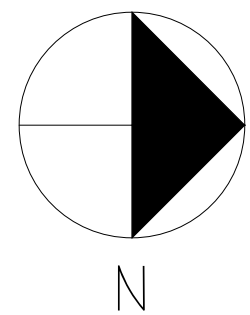

PROJECT:
RESIDENTIAL COURSE PROJECT
THE ESCOFFIER RESIDENCE

RESIDENTIAL DESIGN

INDS 2313

REVISIONS:

6		
5		
4		
3		
2		
1		

DATE: NOV 5TH, 2024

DRAFTED BY:

ALHAN VAZQUEZ

SHEET CONTENTS:

ENLARGED IN-LAW
SUITE RCP

SHEET:

ID-2.1



RESIDENTIAL COURSE PROJECT
THE ESCOFFIER RESIDENCE

RESIDENTIAL DESIGN

INDS 2313

REVISIONS:

6		
5		
4		
3		
2		
1		

DATE: NOV 5TH, 2024

DRAFTED BY:


ALHAN VAZQUEZ

SHEET CONTENTS:

1ST FLOOR
ELECTRICAL PLAN

SHEET:

1D-3.1

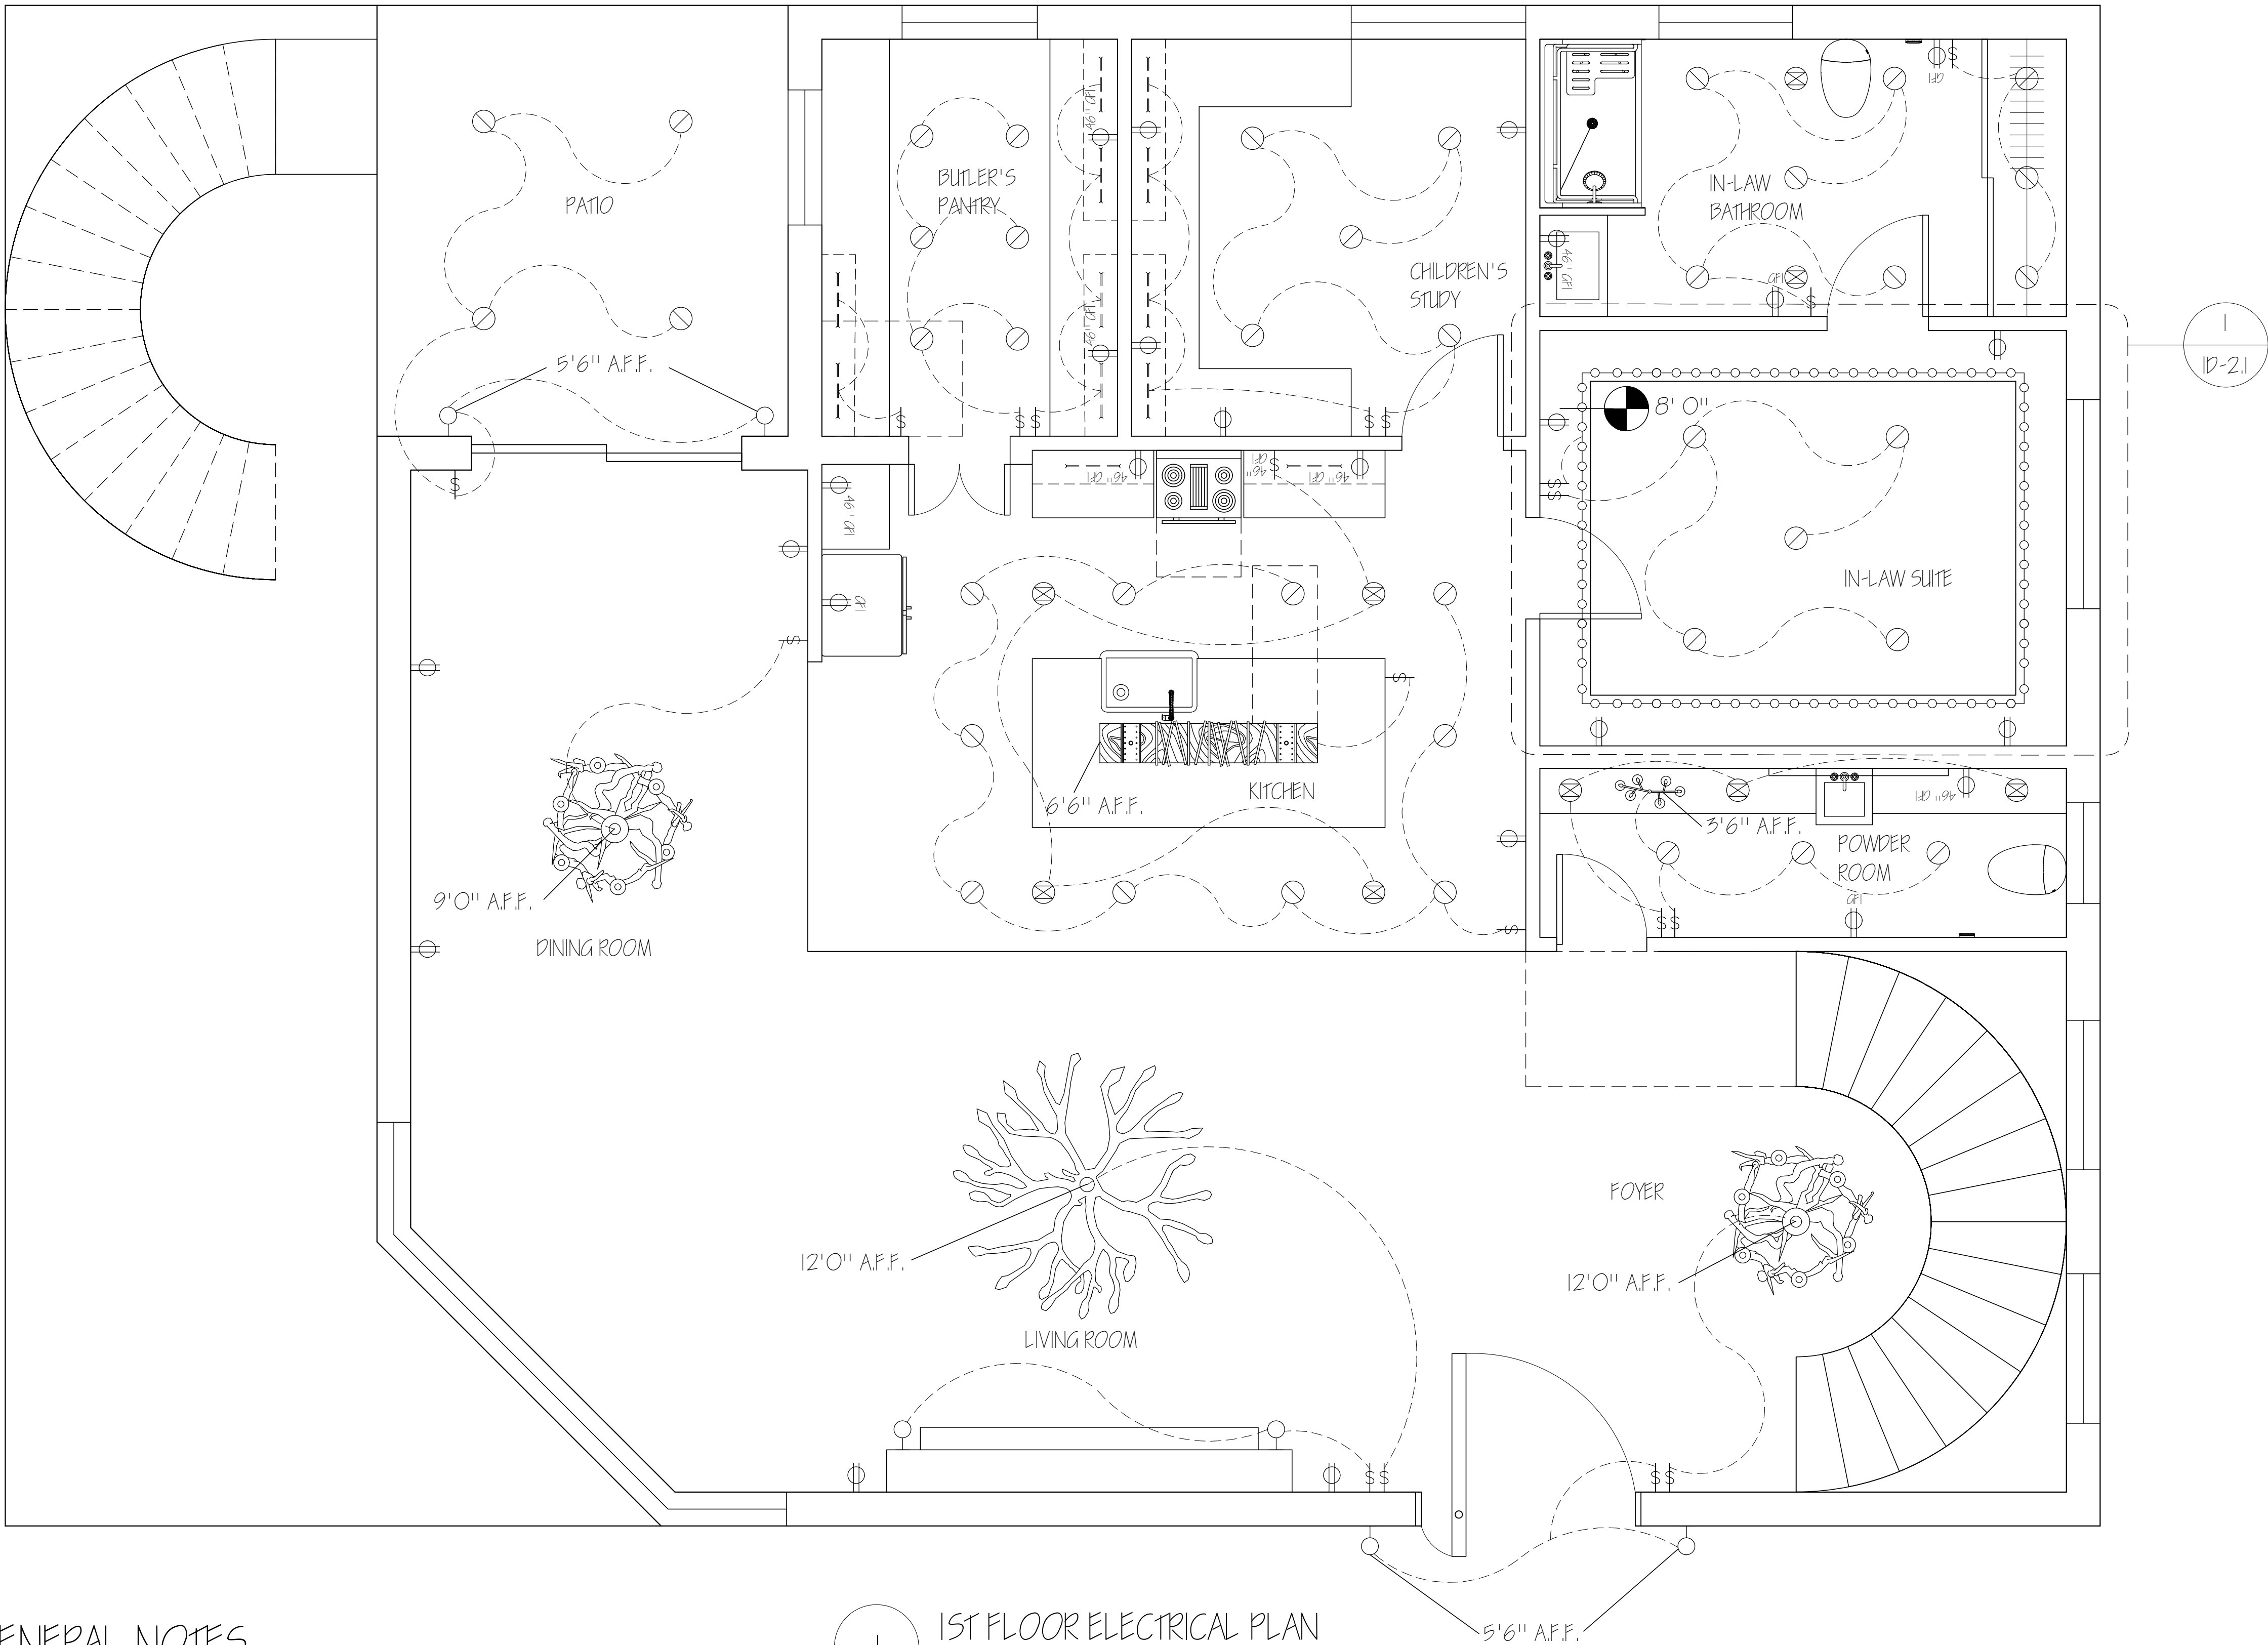



RCP FIXTURE LEGEND	
ITEM	DESCRIPTION
⊙	6" RECESSED LIGHT
⊕	WALL SCONCE
---	LED UNDER CABINET LIGHT
	LIVING ROOM ANTLER CHANDELIER
	FOYER CHANDELIER
	KITCHEN ISLAND CHANDELIER
	DINING ROOM CHANDELIER
	POWDER ROOM CHANDELIER
∘∘∘∘	COVE LIGHTING
⊗	EXHAUST VENT
§	LIGHT SWITCH
⊕	DUPLEX OUTLET
⊕ ^(R)	GFCI OUTLET

GENERAL NOTES

- ALL OUTLETS TO BE INSTALLED AT 15" U.N.O.
- ALL LIGHT FIXTURES TO BE DIMMABLE U.N.O.
- INSTALLATION OF ALL WORK SHALL BE IN ACCORDANCE WITH LOCAL CODES, ORDINANCES AND REGULATIONS.
- ALL EQUIPMENT SHALL BE U.L. LISTED.
- REFER TO ENLARGED RCP 1D-2.1 FOR ADDITIONAL CEILING LIGHT FIXTURE INFORMATION.
- FOR DIMENSIONS TO LIGHTING FIXTURES REFER TO THE DRAWING 1ST FLOOR RCP 1D-10.1.
- LED UNDER CABINET LIGHTS PLACED UNDERNEATH TOP CABINETS.
- CHAMPAGNE BRONZE COVER PLATES PLACED AT EACH OUTLET THROUGHOUT THE SPACE.

1 1ST FLOOR ELECTRICAL PLAN
SCALE: 1/4" = 1'-0"

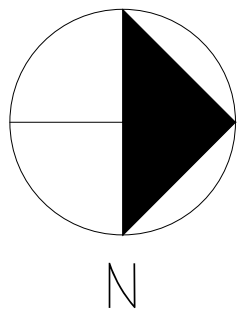

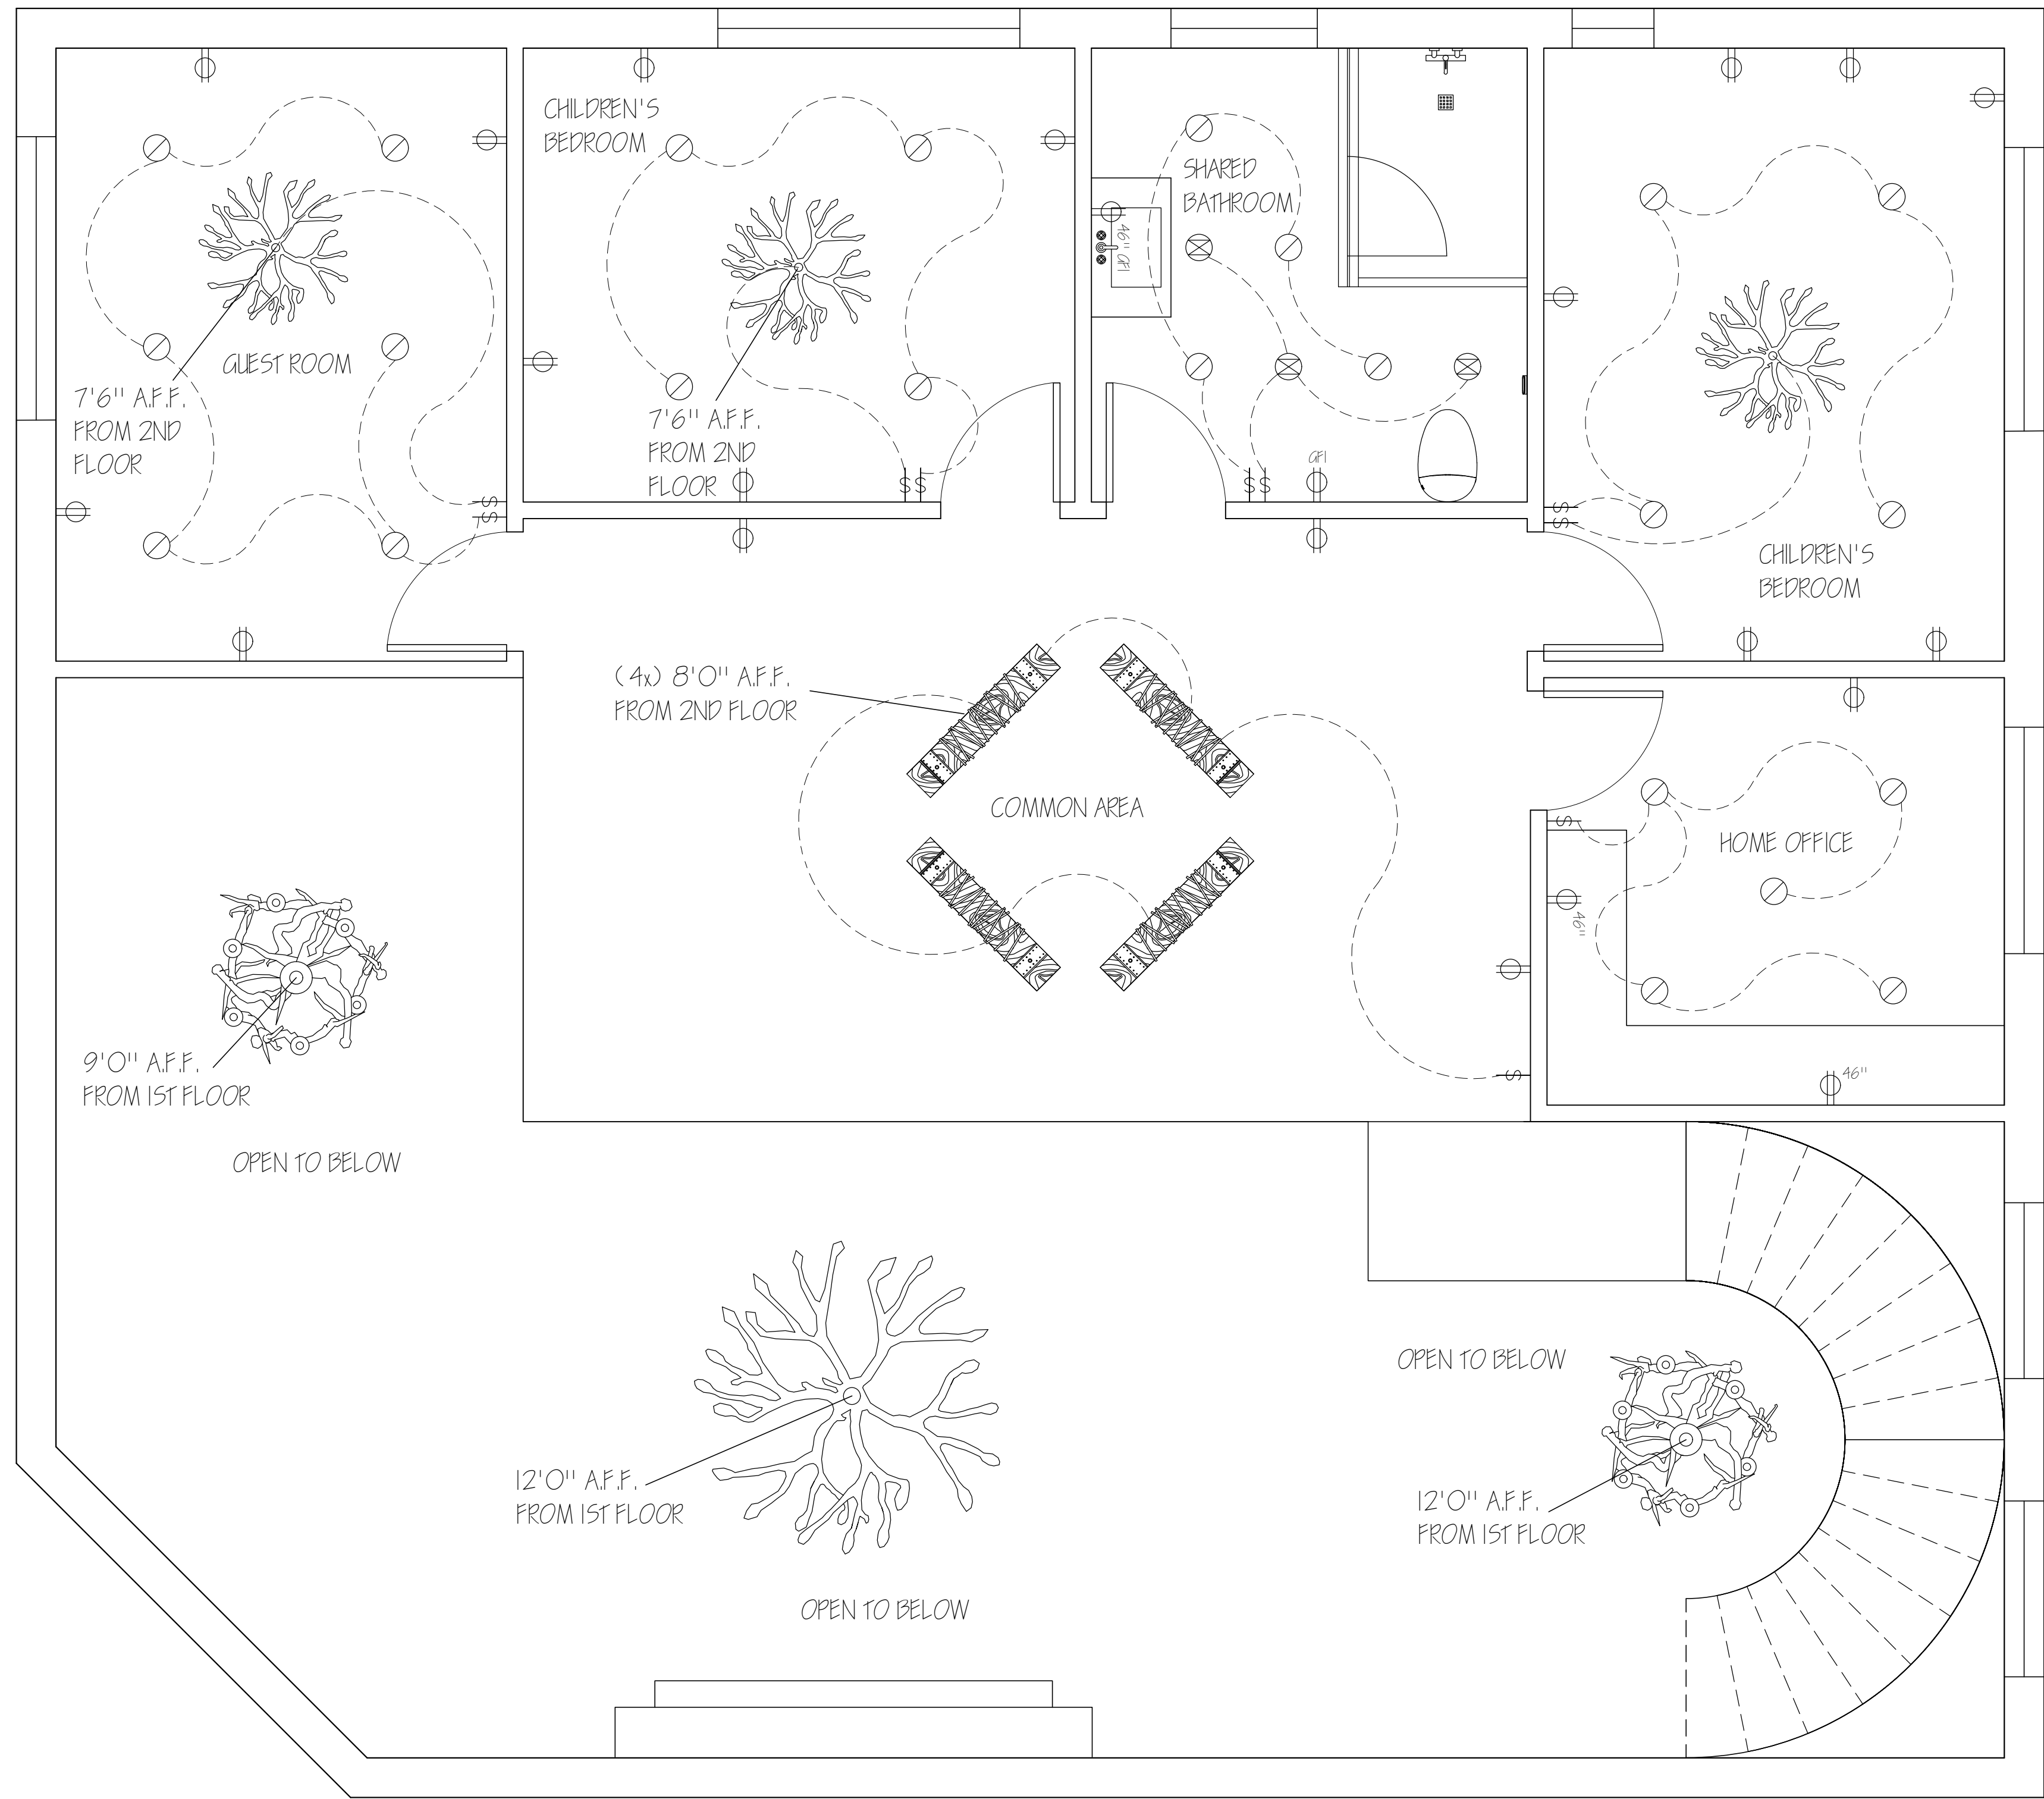


GENERAL NOTES

- ALL OUTLETS TO BE INSTALLED AT 15" U.N.O.
- ALL LIGHT FIXTURES TO BE DIMMABLE U.N.O.
- INSTALLATION OF ALL WORK SHALL BE IN ACCORDANCE WITH LOCAL CODES, ORDINANCES AND REGULATIONS.
- ALL EQUIPMENT SHALL BE U.L. LISTED.
- FOR DIMENSIONS TO LIGHTING FIXTURES REFER TO THE DRAWING 2ND FLOOR RCP ID-10.2.
- LED UNDER CABINET LIGHTS PLACED UNDERNEATH TOP CABINETS.
- CHAMPAGNE BRONZE COVER PLATES PLACED AT EACH OUTLET THROUGHOUT THE SPACE.

1 2ND FLOOR ELECTRICAL PLAN
SCALE: $\frac{1}{4}" = 1'-0"$

RCP FIXTURE LEGEND	
ITEM	DESCRIPTION
	6" RECESSED LIGHT
	WALL SCONCE
	LED UNDER CABINET LIGHT
	LIVING ROOM ANTLER CHANDELIER
	FOYER CHANDELIER
	KITCHEN ISLAND CHANDELIER
	DINING ROOM CHANDELIER
	POWDER ROOM CHANDELIER
	COVE LIGHTING
	EXHAUST VENT
	LIGHT SWITCH
	DUPLEX OUTLET
	GFCI OUTLET

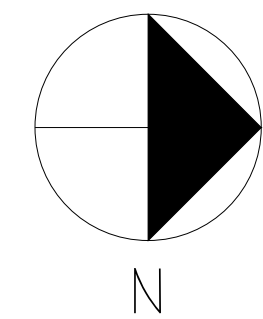

PROJECT:
RESIDENTIAL COURSE PROJECT
THE ESCOFFIER RESIDENCE

RESIDENTIAL DESIGN
INDS 2313

REVISIONS:

6		
5		
4		
3		
2		
1		

DATE: NOV 5TH, 2024

DRAFTED BY:


ALHAN VAZQUEZ

SHEET CONTENTS:

2ND FLOOR
ELECTRICAL PLAN

SHEET:

ID-3.2

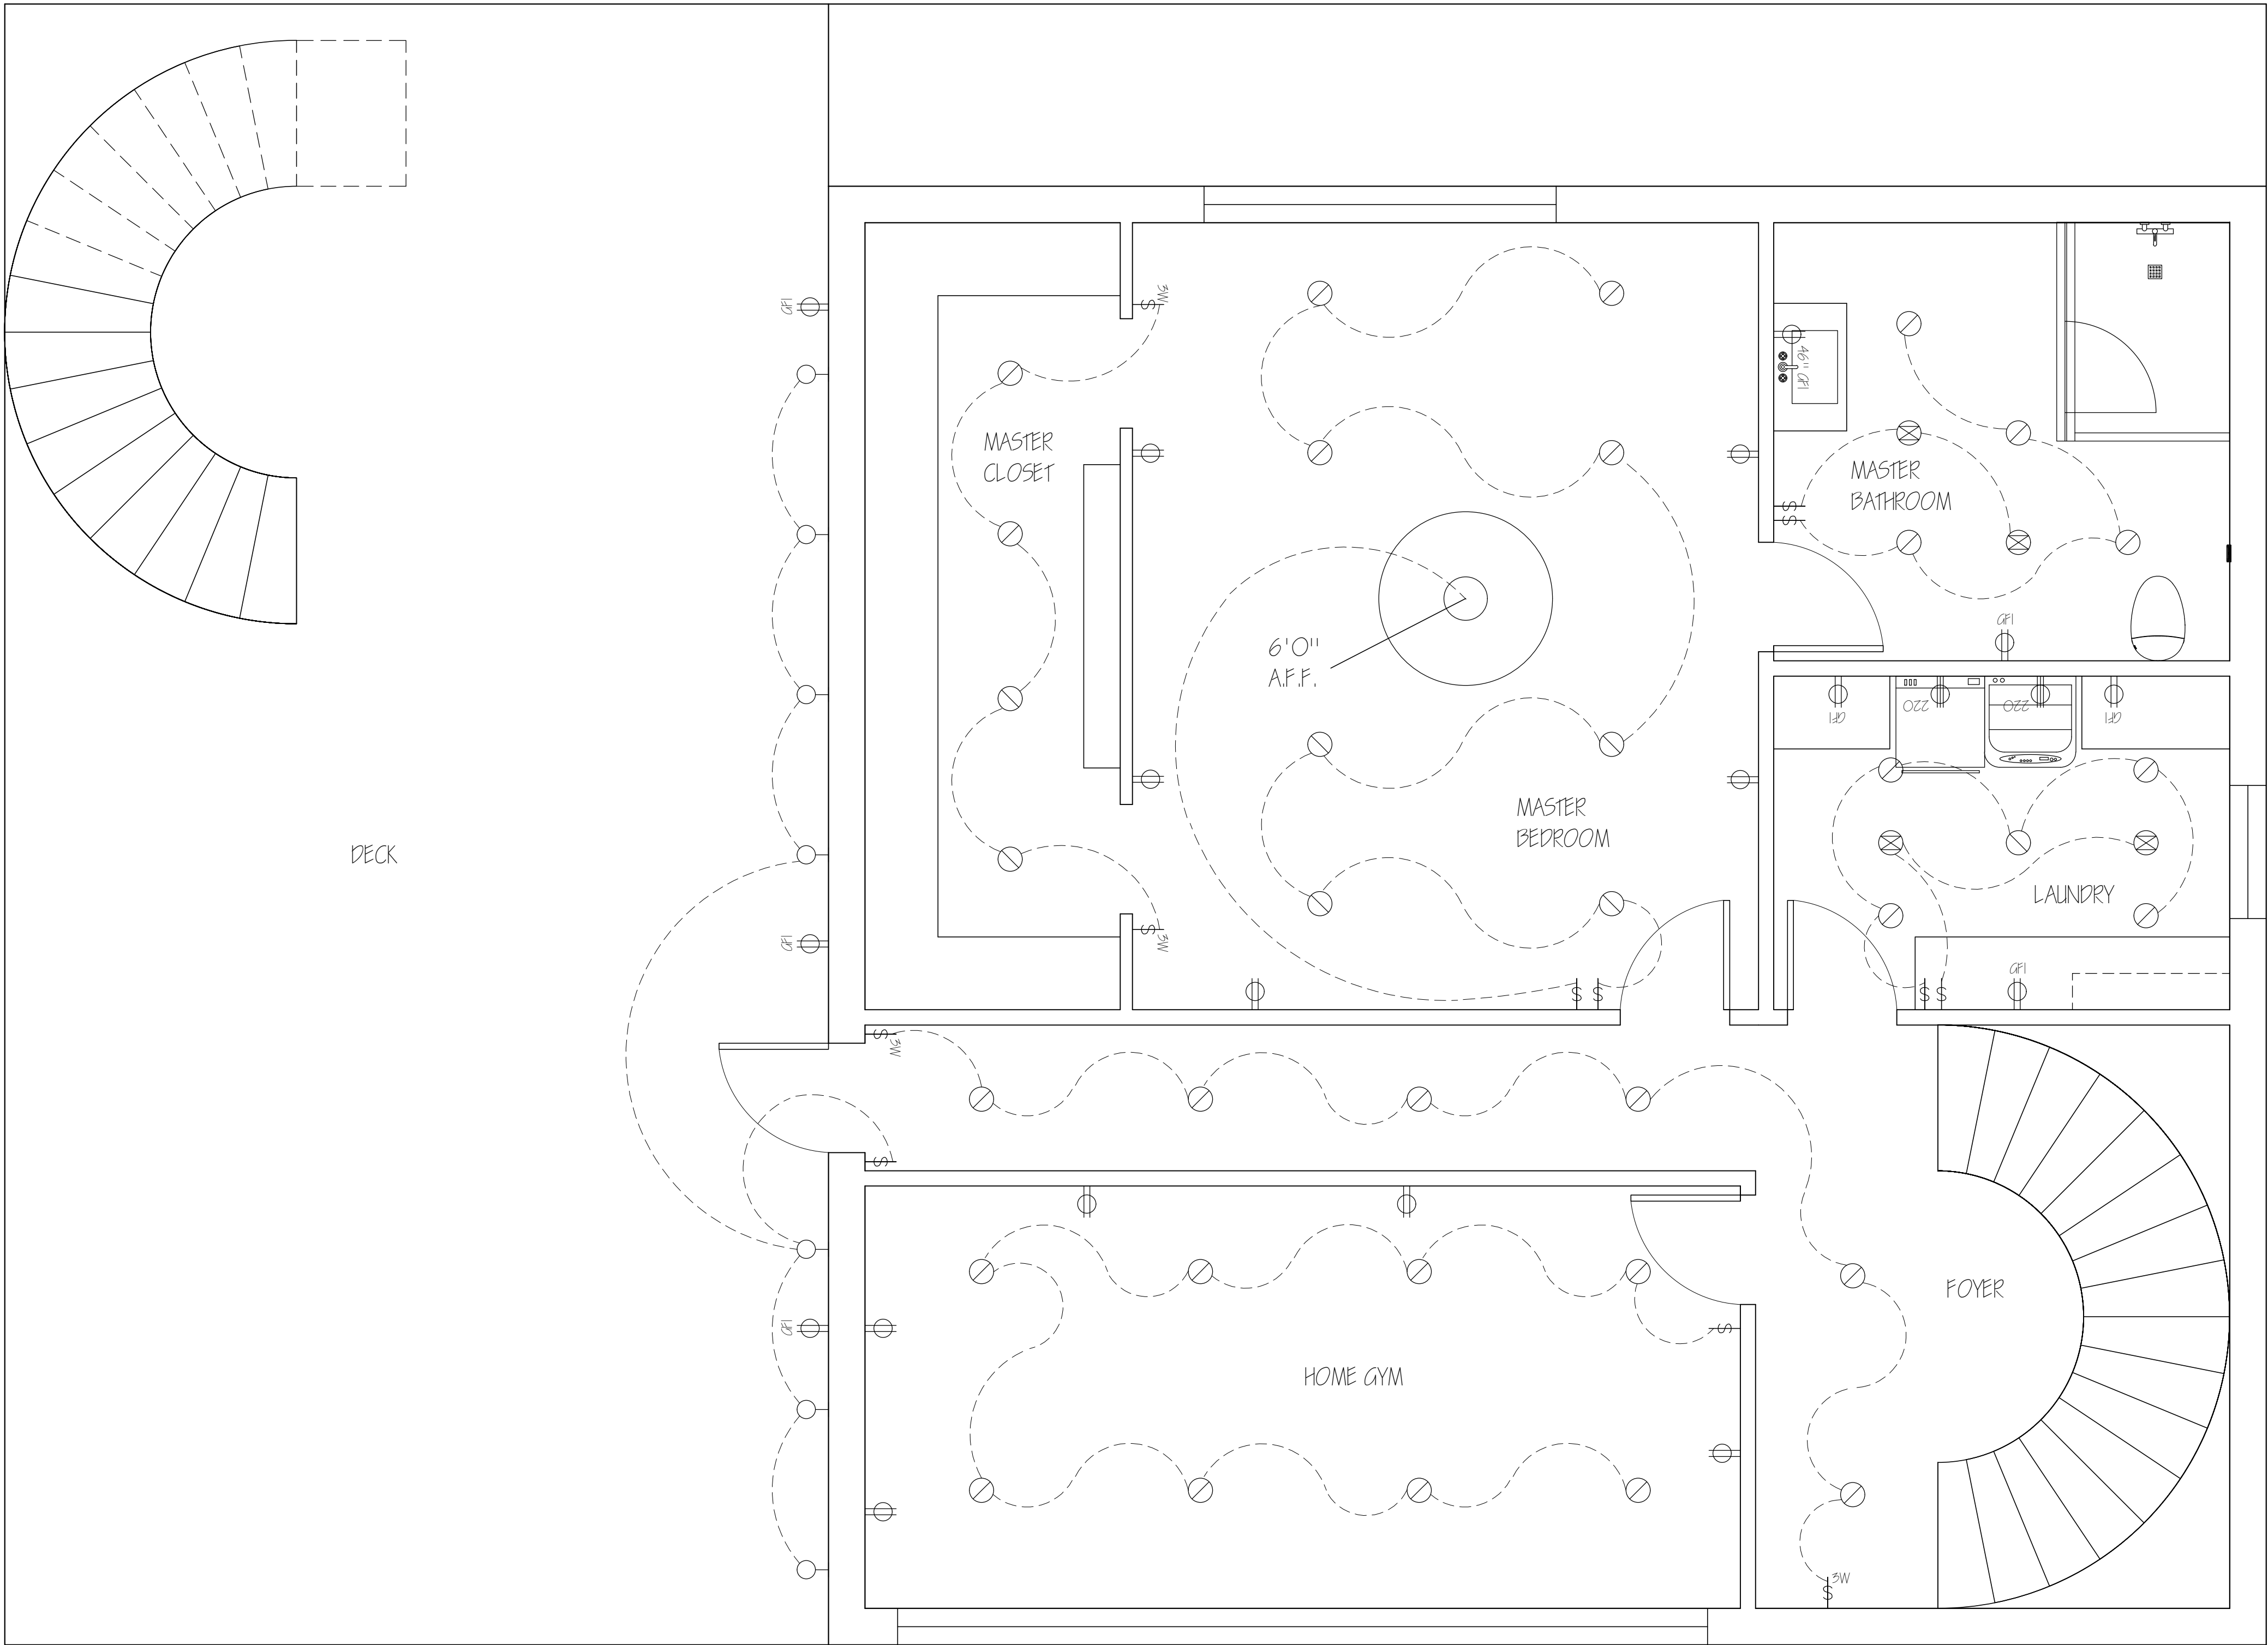


GENERAL NOTES

- ALL OUTLETS TO BE INSTALLED AT 15" U.N.O.
- ALL LIGHT FIXTURES TO BE DIMMABLE U.N.O.
- INSTALLATION OF ALL WORK SHALL BE IN ACCORDANCE WITH LOCAL CODES, ORDINANCES AND REGULATIONS.
- ALL EQUIPMENT SHALL BE U.L. LISTED.
- FOR DIMENSIONS TO LIGHTING FIXTURES REFER TO THE DRAWING BASEMENT RCP ID-10.3.
- LED UNDER CABINET LIGHTS PLACED UNDERNEATH TOP CABINETS.
- CHAMPAGNE BRONZE COVER PLATES PLACED AT EACH OUTLET THROUGHOUT THE SPACE.
- EXTERIOR OUTLETS HAVE A COVER TO PROTECT FROM THE WEATHER.

1 BASEMENT ELECTRICAL PLAN
SCALE: $\frac{1}{4}" = 1'-0"$

RCP FIXTURE LEGEND	
ITEM	DESCRIPTION
	6" RECESSED LIGHT
	WALL SCONCE
	LED UNDER CABINET LIGHT
	LIVING ROOM ANTLER CHANDELIER
	FOYER CHANDELIER
	KITCHEN ISLAND CHANDELIER
	DINING ROOM CHANDELIER
	POWDER ROOM CHANDELIER
	COVE LIGHTING
	EXHAUST VENT
	LIGHT SWITCH
	DUPLEX OUTLET
	GFCI OUTLET
	220V OUTLET
	3 WAY SWITCH

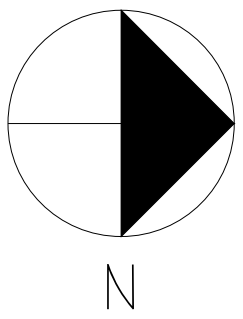

PROJECT:
RESIDENTIAL COURSE PROJECT
THE ESCOFFIER RESIDENCE

RESIDENTIAL DESIGN
INDS 2313

REVISIONS:

6		
5		
4		
3		
2		
1		

DATE: NOV 5TH, 2024

DRAFTED BY:


ALHAN VAZQUEZ

SHEET CONTENTS:

BASEMENT
ELECTRICAL PLAN

SHEET:

ID-3.3

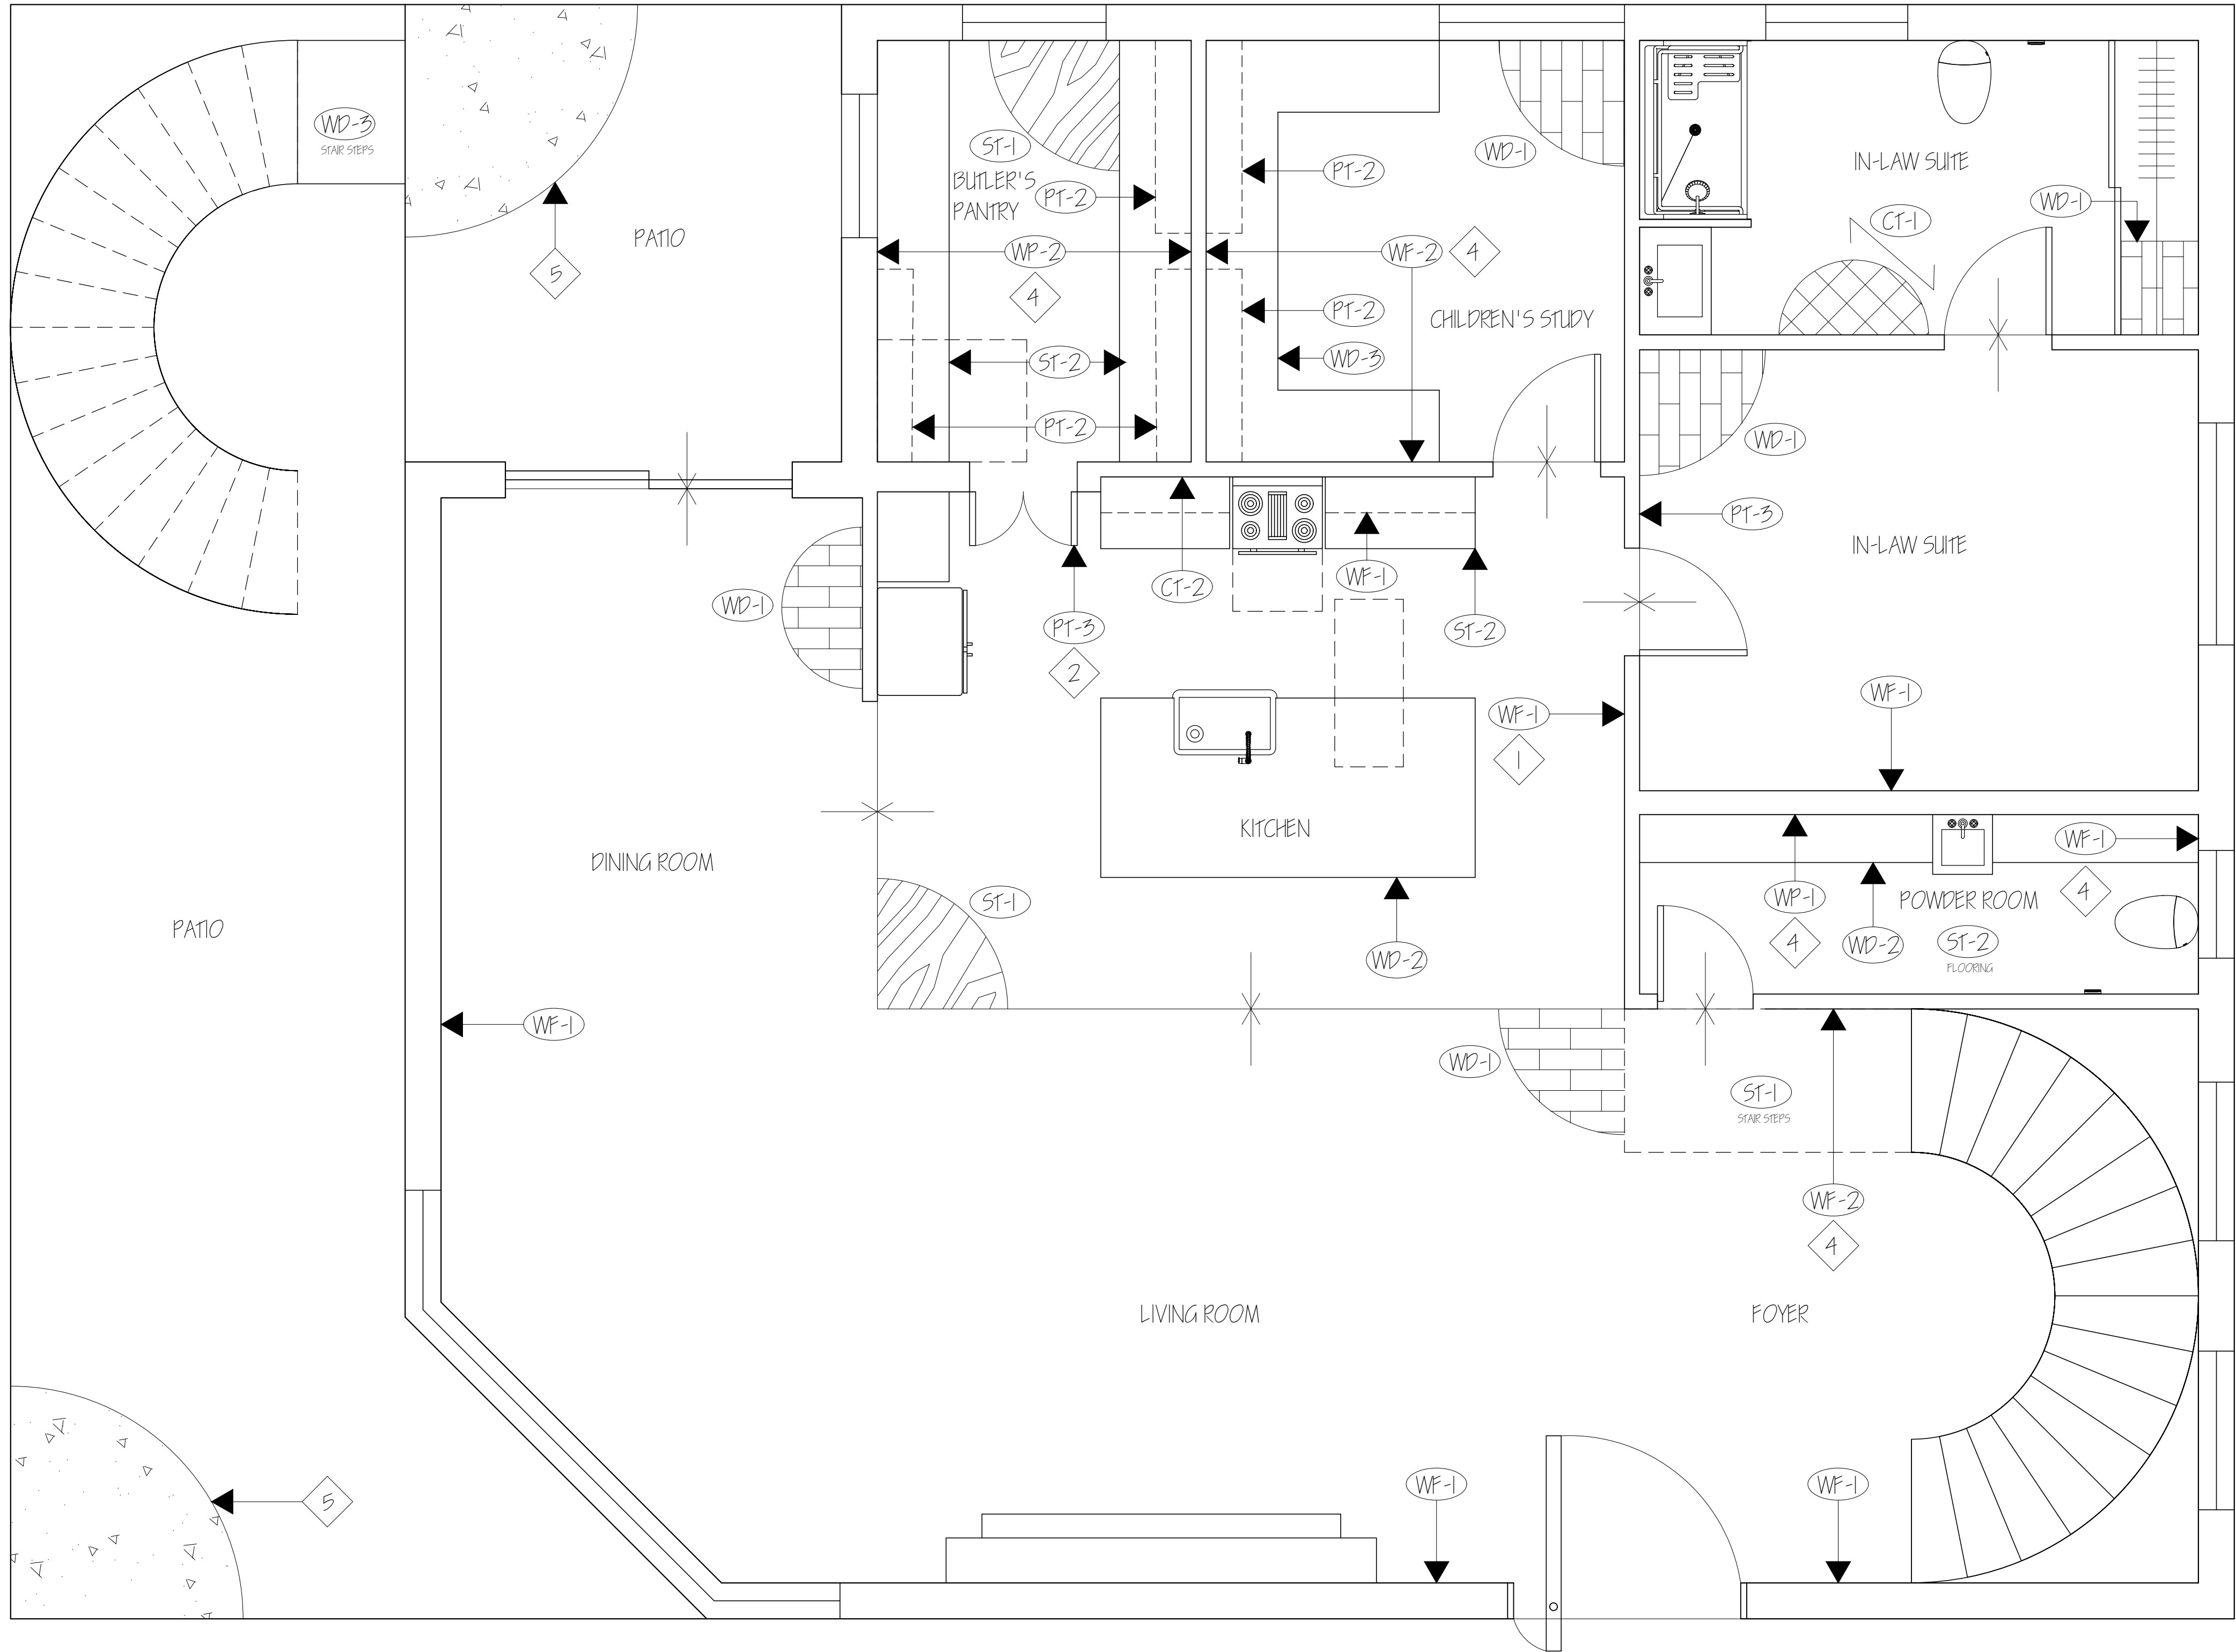


1 1ST FLOOR MATERIAL FINISH PLAN
SCALE: 1/4" = 1'-0"

GENERAL NOTES

- ALL PARTITIONS TO BE PAINTED PT-1, U.N.O.
- ALL FLOORS TO BE WD-1, U.N.O.
- REFERENCE INTERIOR ELEVATION SHEETS FOR ADDITIONAL FINISH INFORMATION.
- ALL CEILING TO BE PAINTED PT-1 U.N.O.
- ALL FLOORING TRANSITIONS THAT OCCUR AT DOORWAY SHALL BE CENTERED UNDER THE DOOR IN ITS CLOSED POSITION.
- FOR ENLARGED MATERIAL FINISH SCHEDULE REFER TO ID-8.1

PLAN NOTES

1. ALL WALLS IN THIS ROOM RECEIVE THIS FINISH.
2. ALL DOORS INSIDE THE KITCHEN ARE PAINTED IN PT-3 ONLY IN THE SIDE OF THE DOOR FACING THE KITCHEN.
3. ALL TILE TO BE GROUTED WITH GR-1.
4. THE ENTIRE WALL GETS THIS FINISH APPLIED.
5. EXTERIOR HEAVY CONCRETE FINISH.

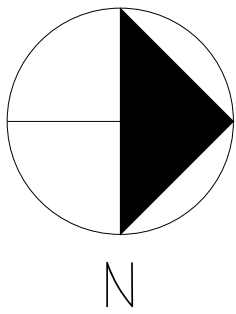

MATERIAL FINISH SCHEDULE					
KEY	MATERIAL	MANUFACTURER	NUMBER/ COLOR	SIZE	REMARKS
WF-1	VENETIAN PLASTER FINISH COVERING	COSIO	COS 5844 STONE	54" WIDTH	REVERSE HANG, RANDOM MATCH
WF-2	MAHOGANY WOOD PANEL	VENO	MAHOGANY, REAL WOOD PANEL	94" X 24" X 1"	BLACK MOF AND FELT BACKING
PT-1	PAINT	SHERWIN WILLIAMS	SW 7757 HIGH REFLECTIVE WHITE		1 PRIMER COAT, 2 FINISH COATS
PT-2	PAINT	SHERWIN WILLIAMS	SW 6965 HYPER BLUE, EGGSHELL		1 PRIMER COAT, 2 FINISH COATS
PT-3	PAINT	SHERWIN WILLIAMS	SW 6793 BLUEBELL, EGGSHELL		1 PRIMER COAT, 2 FINISH COATS
WP-1	PATTERNED WALL PAPER	MAHONE'S INTERIOR DESIGN	CHESAPEAKE ANTLER DAMASK NAVY	20.5" WIDTH	56.4 SQ. FT. ROLL
WP-2	PATTERNED WALL PAPER	WALLPAPER BOLLEVARD	MARE NAVY WAVE	20.5" WIDTH	STRAIGHT, NON-WOVEN
WP-3	PATTERNED WALL PAPER	REBEL WALLS	BIRCH TREES R19070	19.7" WIDTH	MATTE FINISH
WP-4	PATTERNED WALL PAPER	MAHONE'S INTERIOR DESIGN	PEACOCK NAVY YORK	25.25" REPEAT	60.74 SQ. FT. ROLL
ST-1	STONE FLOORING	LA FABBRICA	ONICLE IRIDE COBALTO STONE	65" X 125"	LATERAL REPEATS
ST-2	STONE (COUNTERS AND FLOORING)	G STONE	CALACATTA SEVILLA STONE		IMPORT SLABS
ST-3	STONE FLOORING	LA FABBRICA	NAUTILUS STONE	65" X 125"	LATERAL REPEATS
CT-1	CERAMIC TILE (FLOORING)	FLOOR & DECOR	STRAITFORD PORCELAIN TILE	8" X 8"	1/2" GROUT JOINTS
CT-2	CERAMIC TILE (BACKSLASH)	TILEBAR	HEX ART DECO AZUL HEXAGON	8" HEXAGON	MATTE TILE
GR-1	GROUT	TEXRITE	#013 SILVER GRAY	1/2" GROUT JOINTS	EPOXY
WD-1	RECLAIMED WOOD FLOORING	REC WOOD	KENTUCKY BOURBON RECLAIMED WOOD PANELS	20 SQ FT.	NATURALLY WORN FINISH
WD-2	LIVE EDGE WOOD COUNTERS	LITTLE BRANCH FARM	LIVE EDGE WOOD COUNTERS		NATURAL WOOD
WD-3	WALNUT WOOD	FLOOR & DECOR	ROYAL WALNUT WOOD		POLISHED FINISH
WD-4	SERRA SANDS WOOD FLOORING	WOOD CABINERY	SERRA SANDS SKU: WM1120	24 SQ FT.	WOOD EMBROSS
WD-5	PINE BOARD CABINET DOORS	WOOD CABINERY	RUSTIC PINE BOARD	CUSTOM	CUSTOM CABINETS



PROJECT:
RESIDENTIAL COURSE PROJECT
THE ESCOFFIER RESIDENCE

RESIDENTIAL DESIGN
INDS 2313

REVISIONS:

6		
5		
4		
3		
2		
1		

DATE: NOV 5TH, 2024

DRAFTED BY:

ALHAN VAZQUEZ

SHEET CONTENTS:

FINISH PLAN
1ST FLOOR

SHEET:

ID-4.1



RESIDENTIAL COURSE PROJECT
THE ESCOFFIER RESIDENCE

RESIDENTIAL DESIGN
INDS 2313

REVISIONS:		
6		
5		
4		
3		
2		
1		

DATE: NOV 5TH, 2024

DRAFTED BY:

ALHAN VAZQUEZ

SHEET CONTENTS:

FINISH PLAN
2ND FLOOR

SHEET:

ID-4.2

PROJECT:

DRAFTED BY:

SHEET CONTENTS:

SHEET:

ID-4.2

DATE: NOV 5TH, 2024

ALHAN VAZQUEZ

FINISH PLAN
2ND FLOOR



ID-4.2

GENERAL NOTES

- ALL PARTITIONS TO BE PAINTED PT-1, U.N.O.
- ALL FLOORS TO BE WF-1, U.N.O.
- REFERENCE INTERIOR ELEVATION SHEETS FOR ADDITIONAL FINISH INFORMATION.
- ALL CEILING TO BE PAINTED PT-1 U.N.O.
- ALL FLOORING TRANSITIONS THAT OCCUR AT DOORWAY SHALL BE CENTERED UNDER THE DOOR IN ITS CLOSED POSITION.
- FOR ENLARGED MATERIAL FINISH SCHEDULE REFER TO ID-8.1


PLAN NOTES

- ALL TILE TO BE GROUTED WITH GR-1.
- THE ENTIRE WALL GETS THIS FINISH APPLIED.

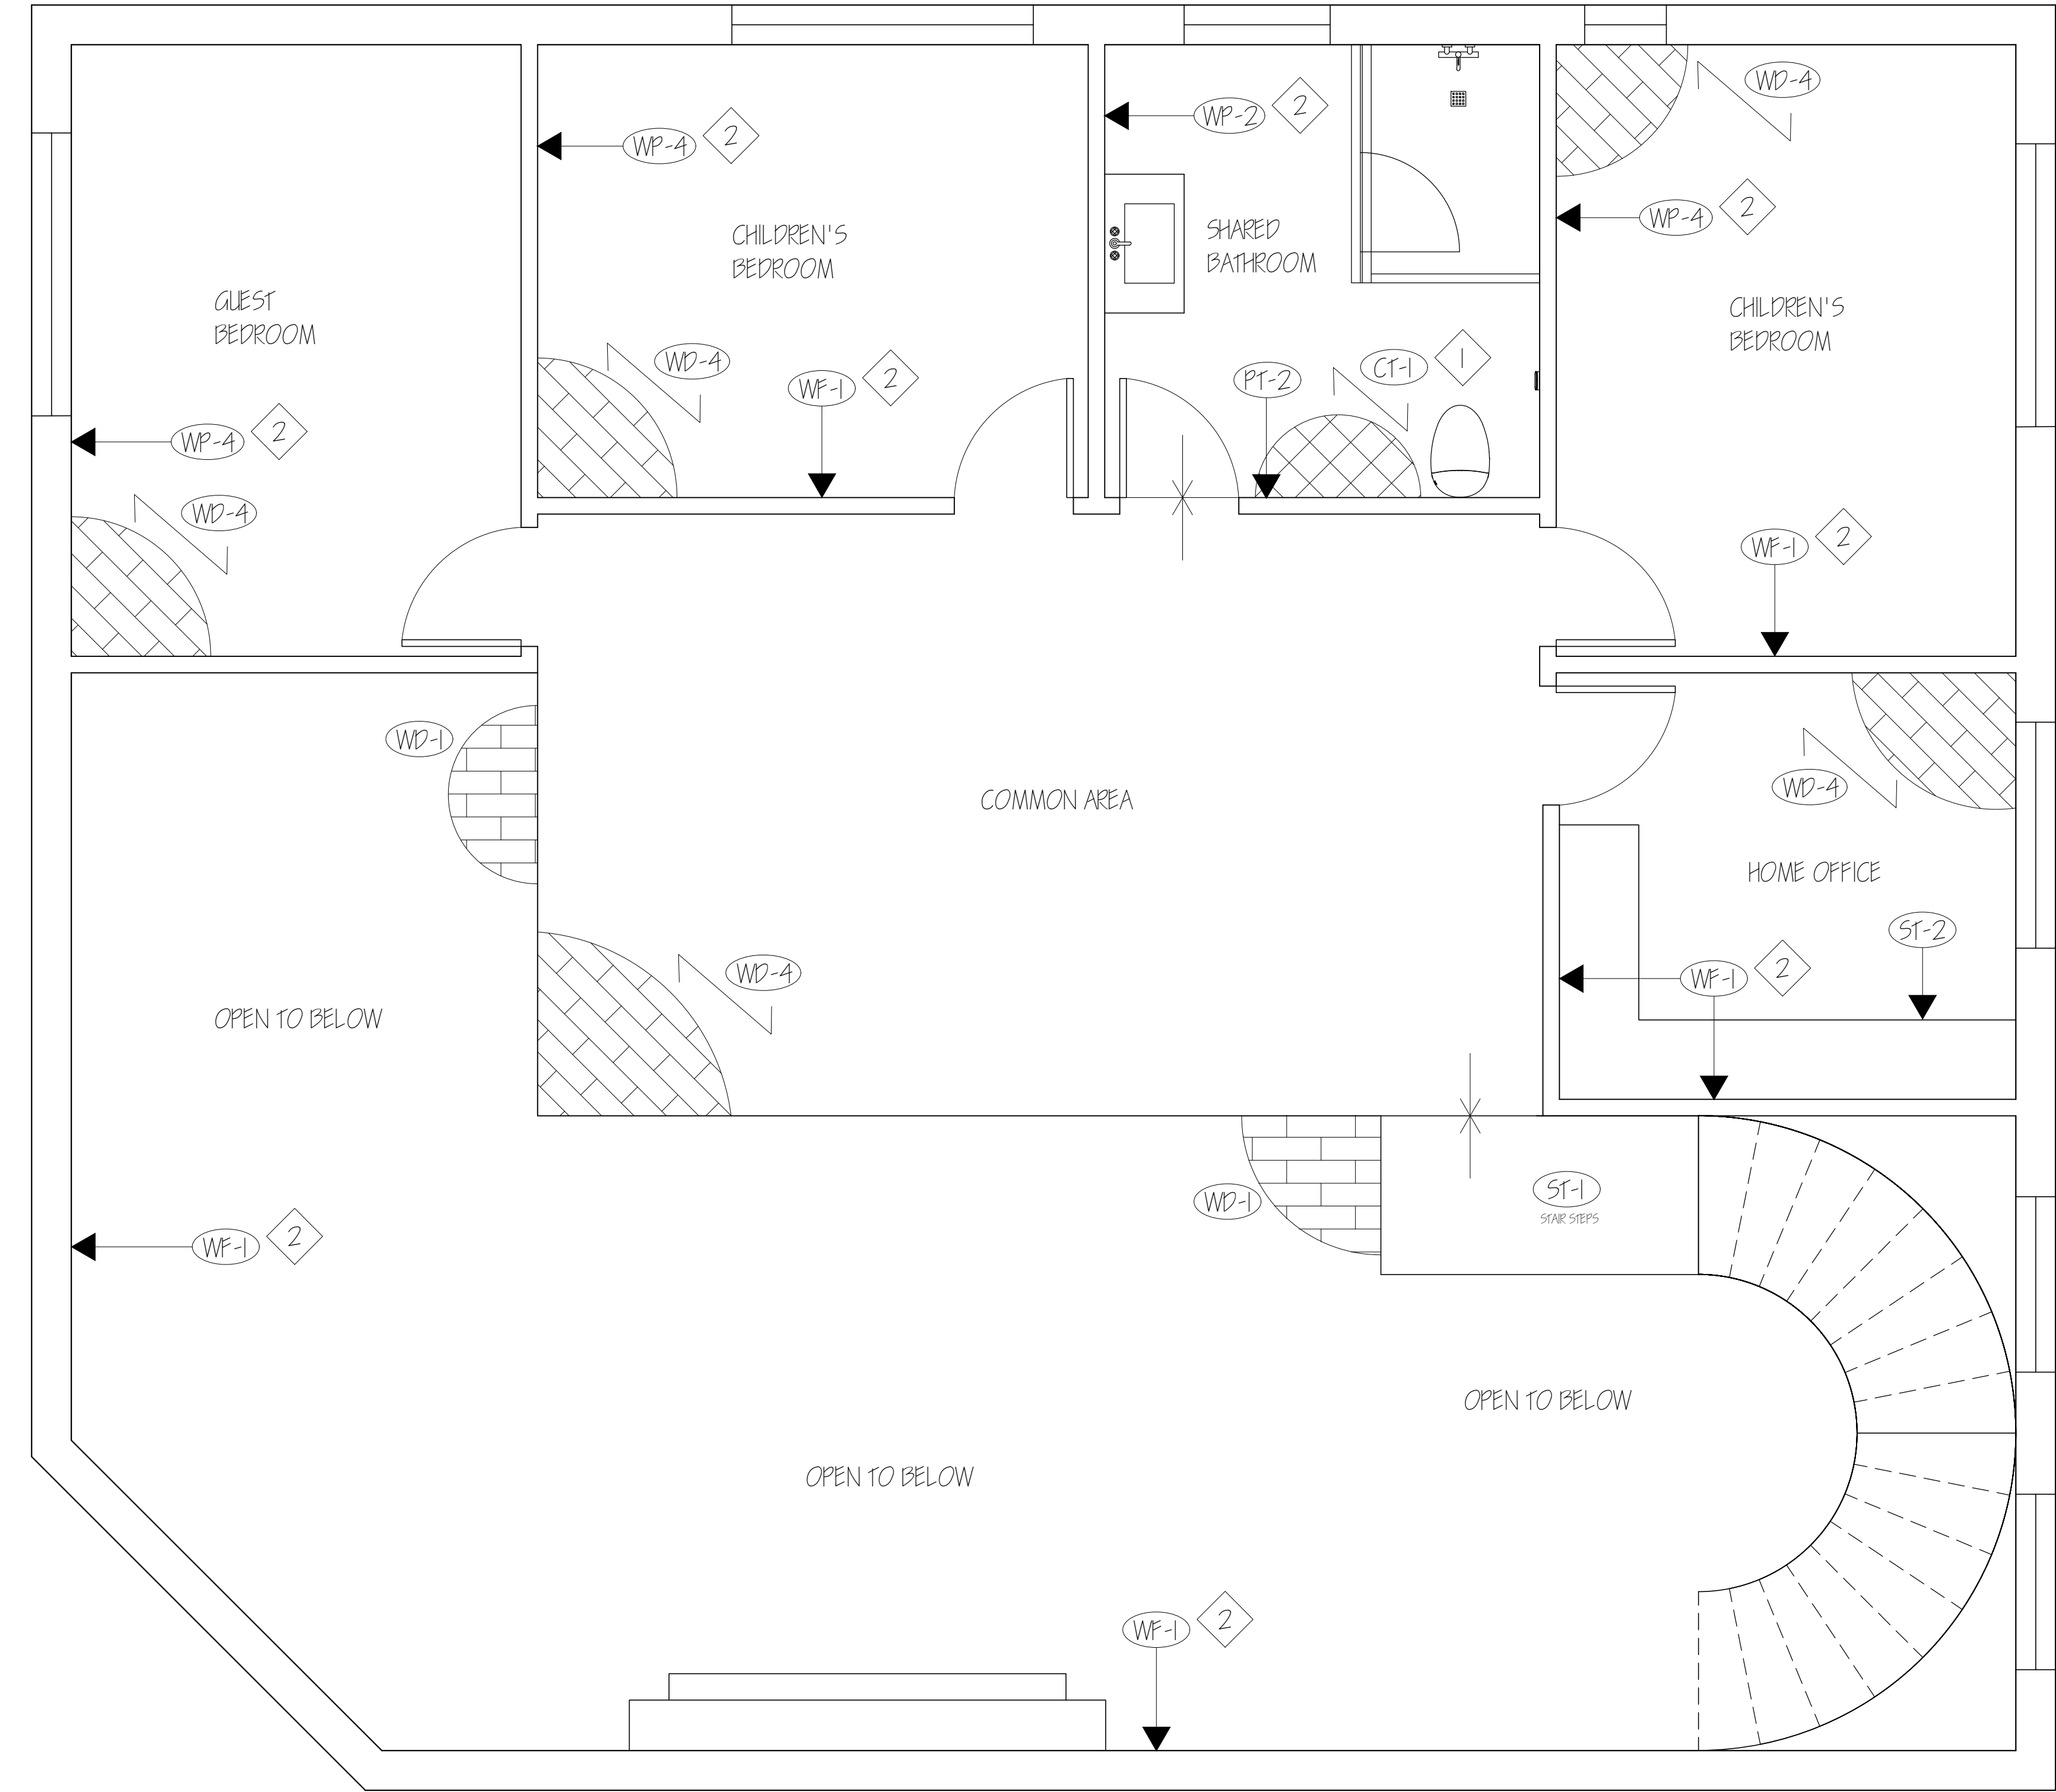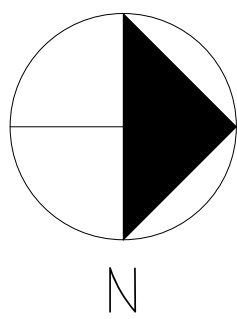

1 2ND FLOOR MATERIAL FINISH PLAN
SCALE: $\frac{1}{4}" = 1'-0"$

MATERIAL FINISH SCHEDULE					
KEY	MATERIAL	MANUFACTURER	NUMBER/ COLOR	SIZE	REMARKS
WF-1	VENETIAN PLASTER FINISH COVERING	COSIO	COS 5844 STONE	64" WIDTH	REVERSE HANG, RANDOM MATCH
WF-2	MAHOGANY WOOD PANEL	VENO	MAHOGANY, REAL WOOD PANEL	94" X 24" X 1"	BLACK MDP AND FELT BACKING
PT-1	PAIN	SHERWIN WILLIAMS	SW 7757 HIGH REFLECTIVE WHITE EGGSHELL		1 PRIMER COAT, 2 FINISH COATS
PT-2	PAIN	SHERWIN WILLIAMS	SW 6965 HYPER BLUE, EGGSHELL		1 PRIMER COAT, 2 FINISH COATS
PT-3	PAIN	SHERWIN WILLIAMS	SW 6793 BLUEBELL, EGGSHELL		1 PRIMER COAT, 2 FINISH COATS
WP-1	PATTERNED WALL PAPER	MAHONE'S INTERIOR DESIGN	CHESAPEAKE ANTLER DAMASK NAVY	20.5" WIDTH	56.4 SQ. FT. ROLL
WP-2	PATTERNED WALL PAPER	WALLPAPER BOULEVARD	MARE NAVY WAVE	20.5" WIDTH	STRAIGHT, NON-WOVEN
WP-3	PATTERNED WALL PAPER	REBEL WALLS	BIRCH TREES R19070	19.7" WIDTH	MATTE FINISH
WP-4	PATTERNED WALL PAPER	MAHONE'S INTERIOR DESIGN	PEACOCK NAVY YORK	25.25" REPEAT	60.74 SQ. FT. ROLL
ST-1	STONE FLOORING	LA FABBRICA	ONICLE RIDE COBALTO STONE	63" X 123"	LATERAL REPEATS
ST-2	STONE (COUNTERS AND FLOORING)	G STONE	CALACATTA SEVILLA STONE		IMPORT SLABS
ST-3	STONE FLOORING	LA FABBRICA	NAUTILUS STONE	63" X 123"	LATERAL REPEATS
CT-1	CERAMIC TILE (FLOORING)	FLOOR & DECOR	STRATFORD PORCELAIN TILE	8" X 8"	$\frac{1}{8}"$ GROUT JOINTS
CT-2	CERAMIC TILE (BACKSPLASH)	TILEBAR	HEX ART DECO AZUL HEXAGON	8" HEXAGON	MATTE TILE
GR-1	GROUT	TEXRITE	#013 SILVER GRAY	$\frac{1}{8}"$ GROUT JOINTS	EPOXY
WD-1	RECLAIMED WOOD FLOORING	REC WOOD	KENTUCKY BOURBON RECLAIMED WOOD PANELS	20 SQ.FT.	NATURALLY WORN FINISH
WD-2	LIVE EDGE WOOD COUNTERS	LITTLE BRANCH FARM	LIVE EDGE WOOD COUNTERS		NATURAL WOOD
WD-3	WALNUT WOOD	ROYAL WALNUT WOOD	ROYAL WALNUT WOOD		POLISHED FINISH
WD-4	SERRA SANDS WOOD FLOORING	TILES OF EUROPE	SERRA SANDS SKU WM11120	24 SQ.FT.	WOOD EMBROSS
WD-5	PINE BOARD CABINET DOORS	MOD CABINETRY	RUSTIC PINE BOARD	CUSTOM	CUSTOM CABINETS


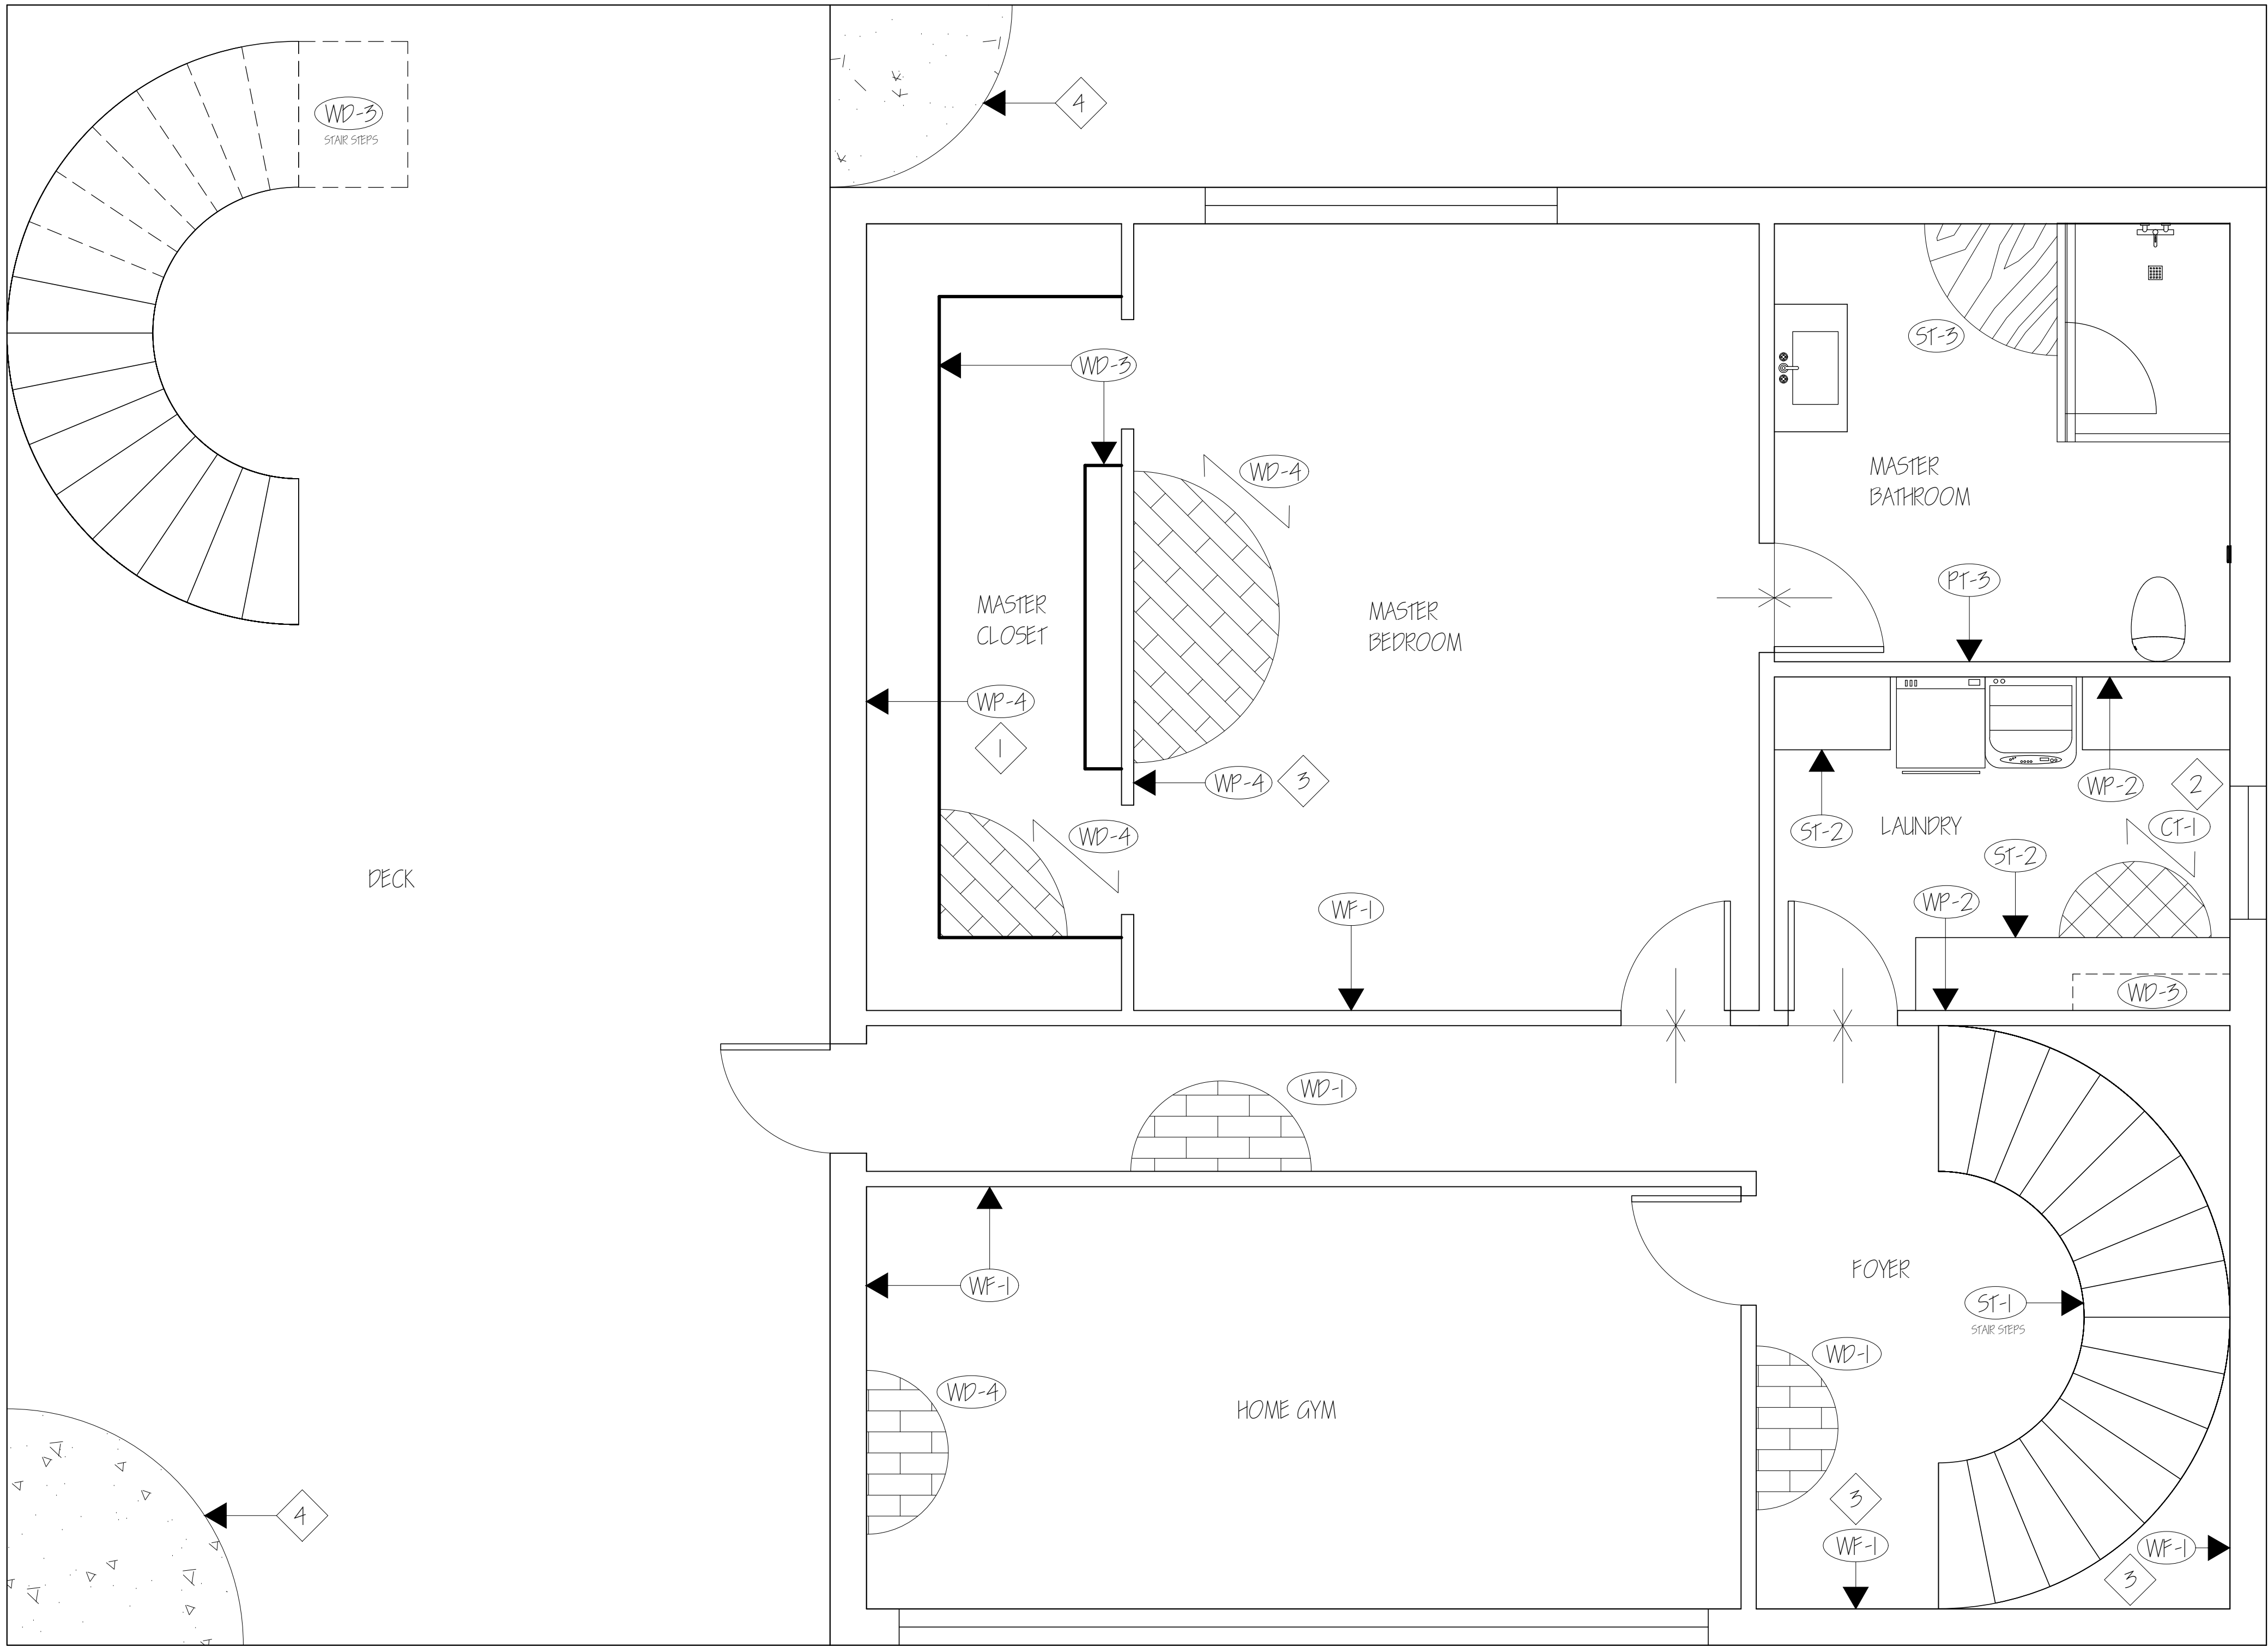


GENERAL NOTES

- ALL PARTITIONS TO BE PAINTED PT-1, U.N.O.
- ALL FLOORS TO BE WD-1, U.N.O.
- REFERENCE INTERIOR ELEVATION SHEETS FOR ADDITIONAL FINISH INFORMATION.
- ALL CEILING TO BE PAINTED PT-1 U.N.O.
- ALL FLOORING TRANSITIONS THAT OCCUR AT DOORWAY SHALL BE CENTERED UNDER THE DOOR IN ITS CLOSED POSITION.
- FOR ENLARGED MATERIAL FINISH SCHEDULE REFER TO ID-B.1

PLAN NOTES

1. ALL WALLS IN THIS ROOM RECEIVE THIS FINISH.
2. ALL TILE TO BE GROUTED WITH GR-1.
3. THE ENTIRE WALL GETS THIS FINISH APPLIED.
4. EXTERIOR HEAVY CONCRETE FINISH.

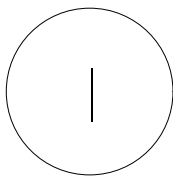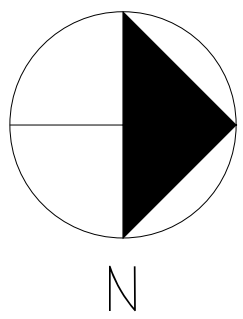

BASEMENT MATERIAL FINISH PLAN

SCALE: 1/4" = 1'-0"

MATERIAL FINISH SCHEDULE					
KEY	MATERIAL	MANUFACTURER	NUMBER/ COLOR	SIZE	REMARKS
WF-1	VENETIAN PLASTER FINISH COVERING	COSO	COS 5844 STONE	64" WIDTH	REVERSE HANG, RANDOM MATCH
WF-2	MAHOGANY WOOD PANEL	VENO	MAHOGANY, REAL WOOD PANEL	94" X 24" X 1"	BLACK MOF AND FELT BACKING
PT-1	PAIN	SHERWIN WILLIAMS	SW 7797 HIGH REFLECTIVE WHITE		1 PRIMER COAT, 2 FINISH COATS
PT-2	PAIN	SHERWIN WILLIAMS	EGGSHELL		1 PRIMER COAT, 2 FINISH COATS
PT-3	PAIN	SHERWIN WILLIAMS	SW 6965 HYPER BLUE, EGGSHELL		1 PRIMER COAT, 2 FINISH COATS
WP-1	PATTERNED WALL PAPER	MAHONE'S INTERIOR DESIGN	CHESAPEAKE ANTLER DAMASK NAVY	20.5" WIDTH	96.4 SQ. FT. ROLL
WP-2	PATTERNED WALL PAPER	WALLPAPER BOULEVARD	WARE NAVY WAVE	20.5" WIDTH	STRAIGHT, NON-WOVEN
WP-3	PATTERNED WALL PAPER	REBEL WALLS	BIRCH TREES R19070	19.7" WIDTH	MATTE FINISH
WP-4	PATTERNED WALL PAPER	MAHONE'S INTERIOR DESIGN	PEACOCK NAVY YORK	25.25" REPEAT	60.74 SQ. FT. ROLL
ST-1	STONE FLOORING	LA FABBRICA	ONICLE RIDGE COBALTO STONE	65" X 125"	LATERAL REPEATS
ST-2	STONE (COUNTERS AND FLOORING)	G STONE	CALACATTA SEVILLA STONE		IMPORT SLABS
ST-3	STONE FLOORING	LA FABBRICA	NAUTILUS STONE	65" X 125"	LATERAL REPEATS
CT-1	CERAMIC TILE (FLOORING)	FLOOR & DECOR	STRATFORD PORCELAIN TILE	8" X 8"	1/4" GROUT JOINTS
CT-2	CERAMIC TILE (BACKSLASH)	TILEBAR	HEX ART DECO AZUL HEXAGON	8" HEXAGON	MATTE TILE
GR-1	GROUT	TEXRITE	#013 SILVER GRAY	1/4" GROUT JOINTS	EPOXY
WD-1	RECLAIMED WOOD FLOORING	REC WOOD	KENTUCKY BOURBON RECLAIMED WOOD PANELS	20 SQ FT.	NATURALLY WORN FINISH
WD-2	LIVE EDGE WOOD COUNTERS	LITTLE BRANCH FARM	LIVE EDGE WOOD COUNTERS		NATURAL WOOD
WD-3	WALNUT WOOD	FLOOR & DECOR	ROYAL WALNUT WOOD		POLISHED FINISH
WD-4	SIERRA SANDS WOOD FLOORING	TILES OF EUROPE	SIERRA SANDS SKUL W11120	24 SQ FT.	WOOD EMPRESS
WD-5	PINE BOARD CABINET DOORS	MOD CABINETRY	RUSTIC PINE BOARD	CUSTOM	CUSTOM CABINETS



PROJECT:
RESIDENTIAL COURSE PROJECT
THE ESCOFFIER RESIDENCE

RESIDENTIAL DESIGN

INDS 2313

REVISIONS:

6		
5		
4		
3		
2		
1		

DATE: NOV 5TH, 2024

DRAFTED BY:


ALHAN VAZQUEZ

SHEET CONTENTS:

FINISH PLAN
BASEMENT


SHEET:

ID-4.3

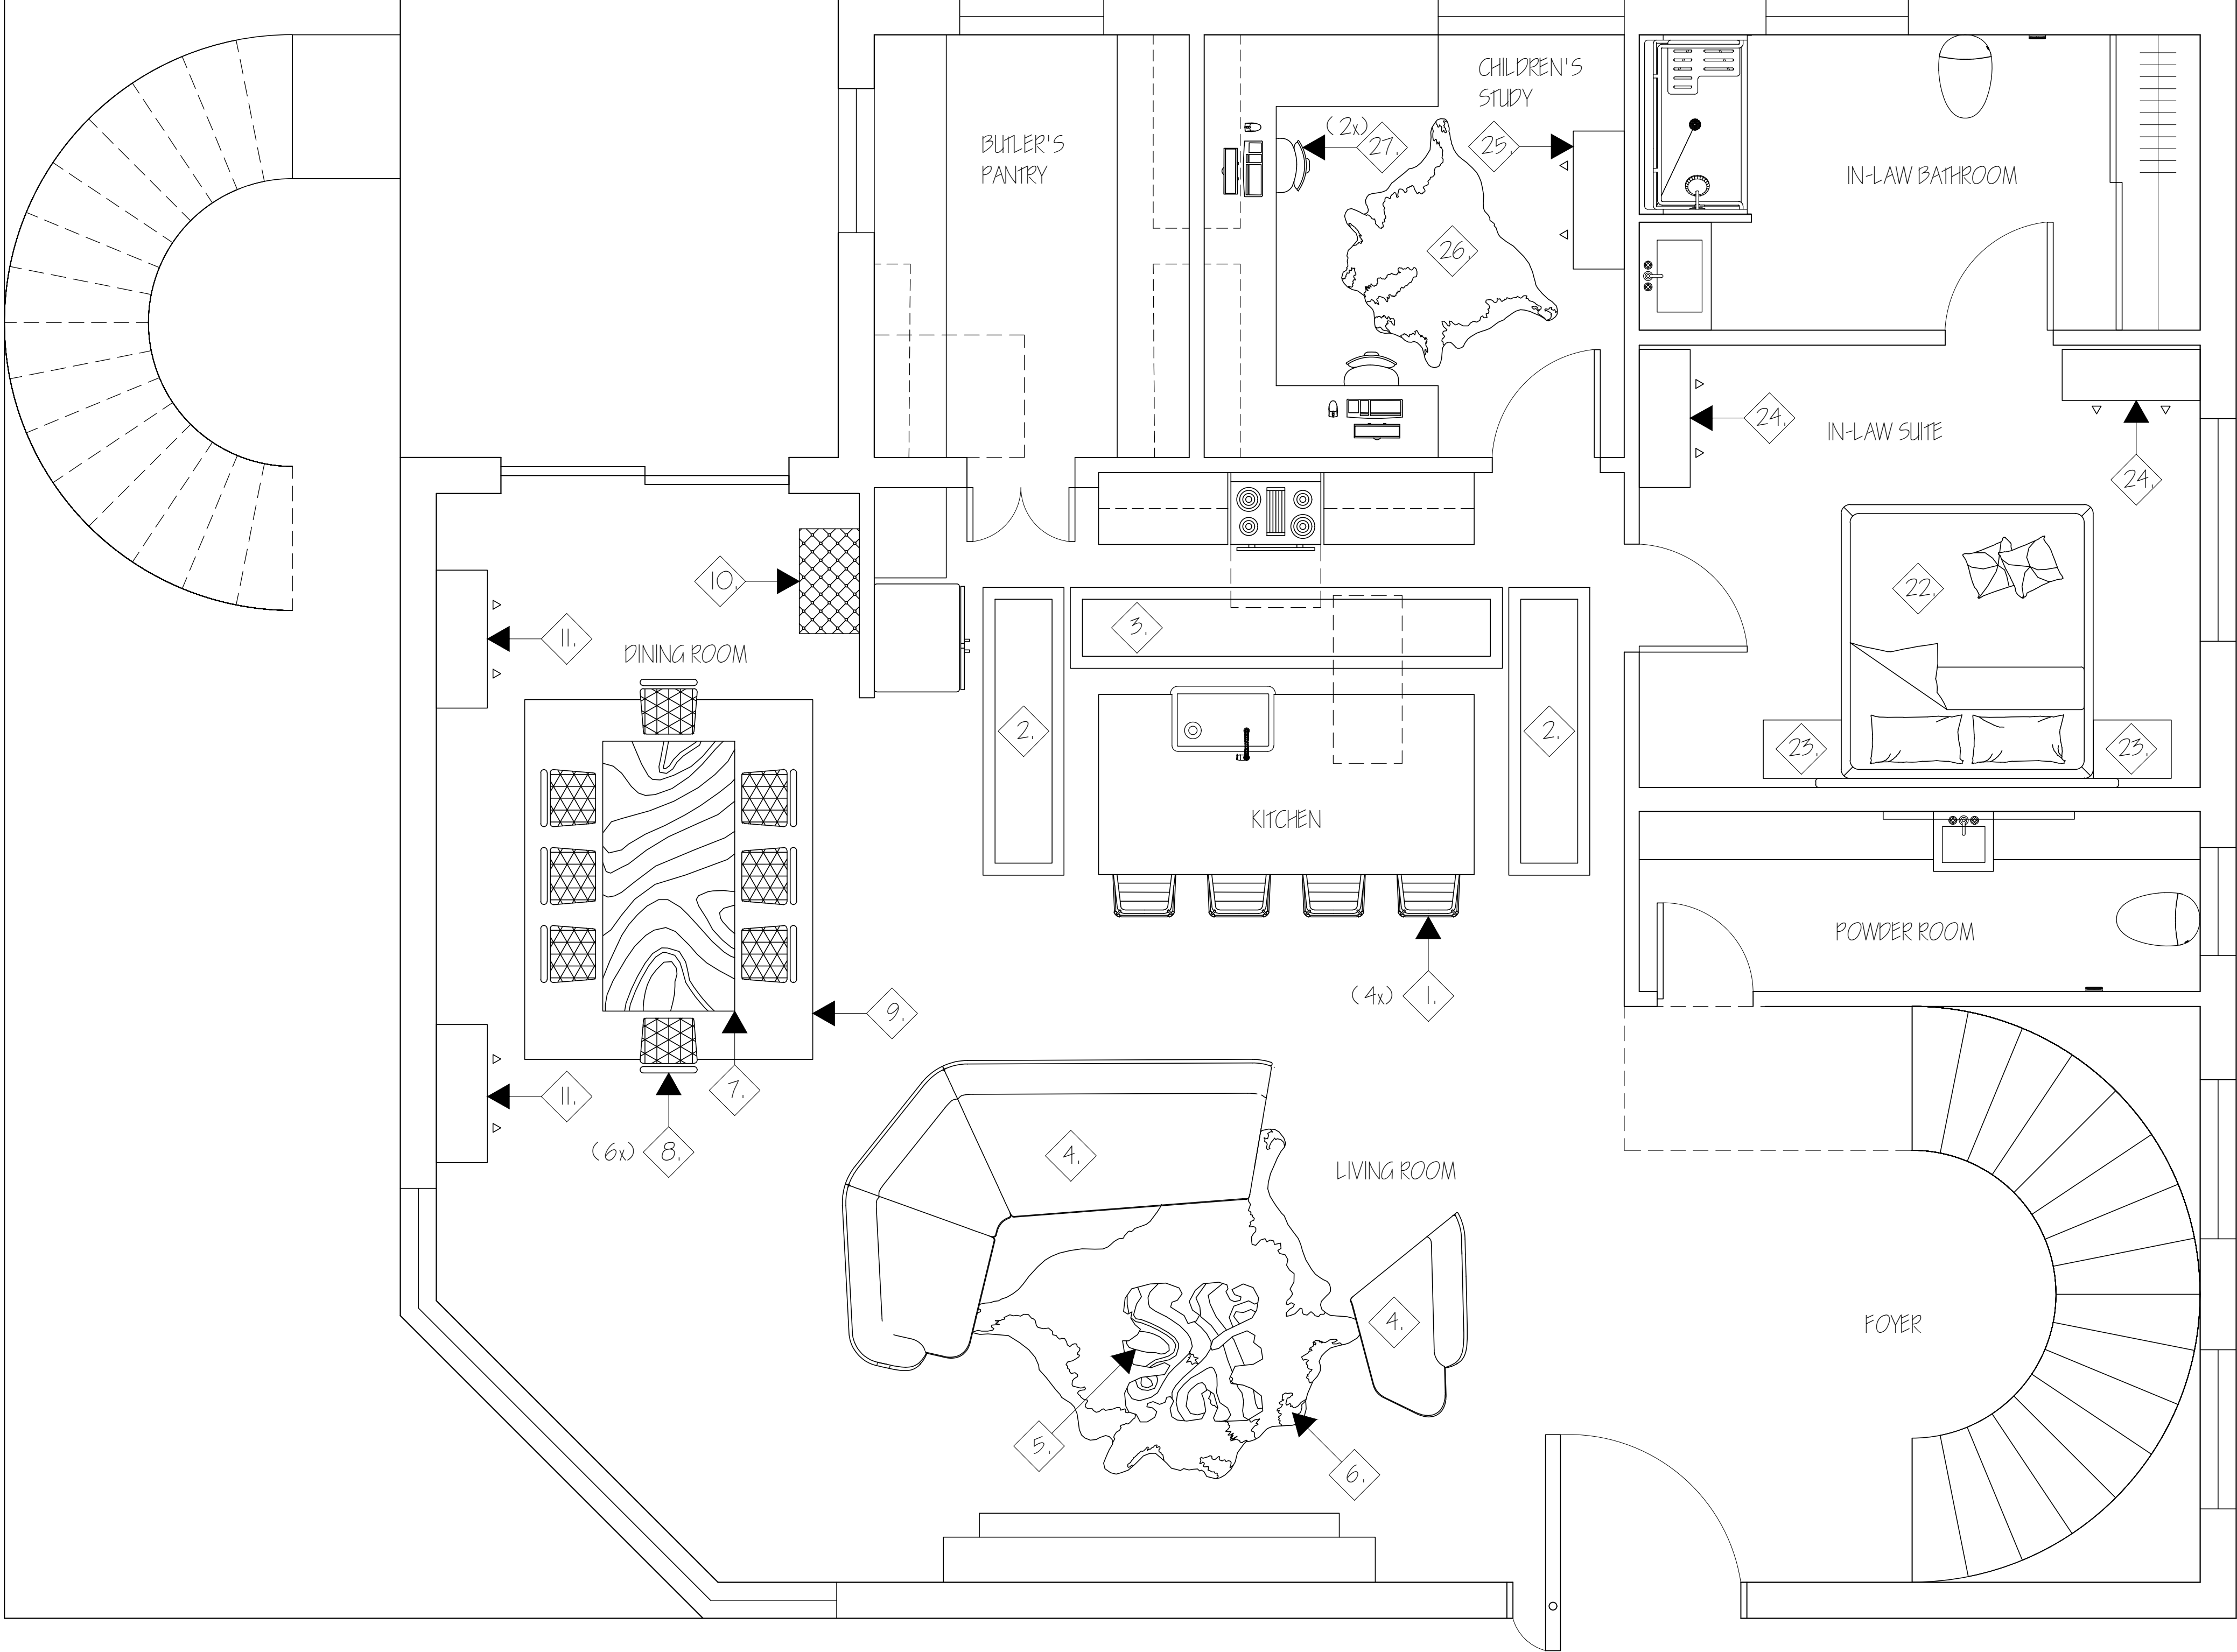

1 1ST FLOOR FURNITURE PLAN
SCALE: 1/4" = 1'-0"

- GENERAL NOTES
- FOR FURNITURE PLACEMENT REFERENCE ONLY.
 - FOR FURNITURE SPECIFICATIONS AND REFERENCES REFER TO FURNITURE SCHEDULE ID-9.1
 - DO NOT SCALE THE DRAWING.

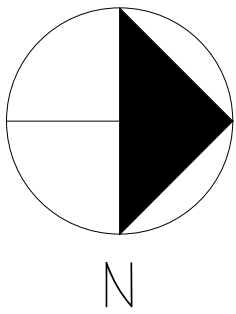

PROJECT:
RESIDENTIAL COURSE PROJECT
THE ESCOFFIER RESIDENCE

RESIDENTIAL DESIGN
INDS 2313

REVISIONS:

6		
5		
4		
3		
2		
1		

DATE: NOV 5TH, 2024

DRAFTED BY:


ALHAN VAZQUEZ

SHEET CONTENTS:

FURNITURE PLAN
1ST FLOOR


SHEET:

ID-5.1

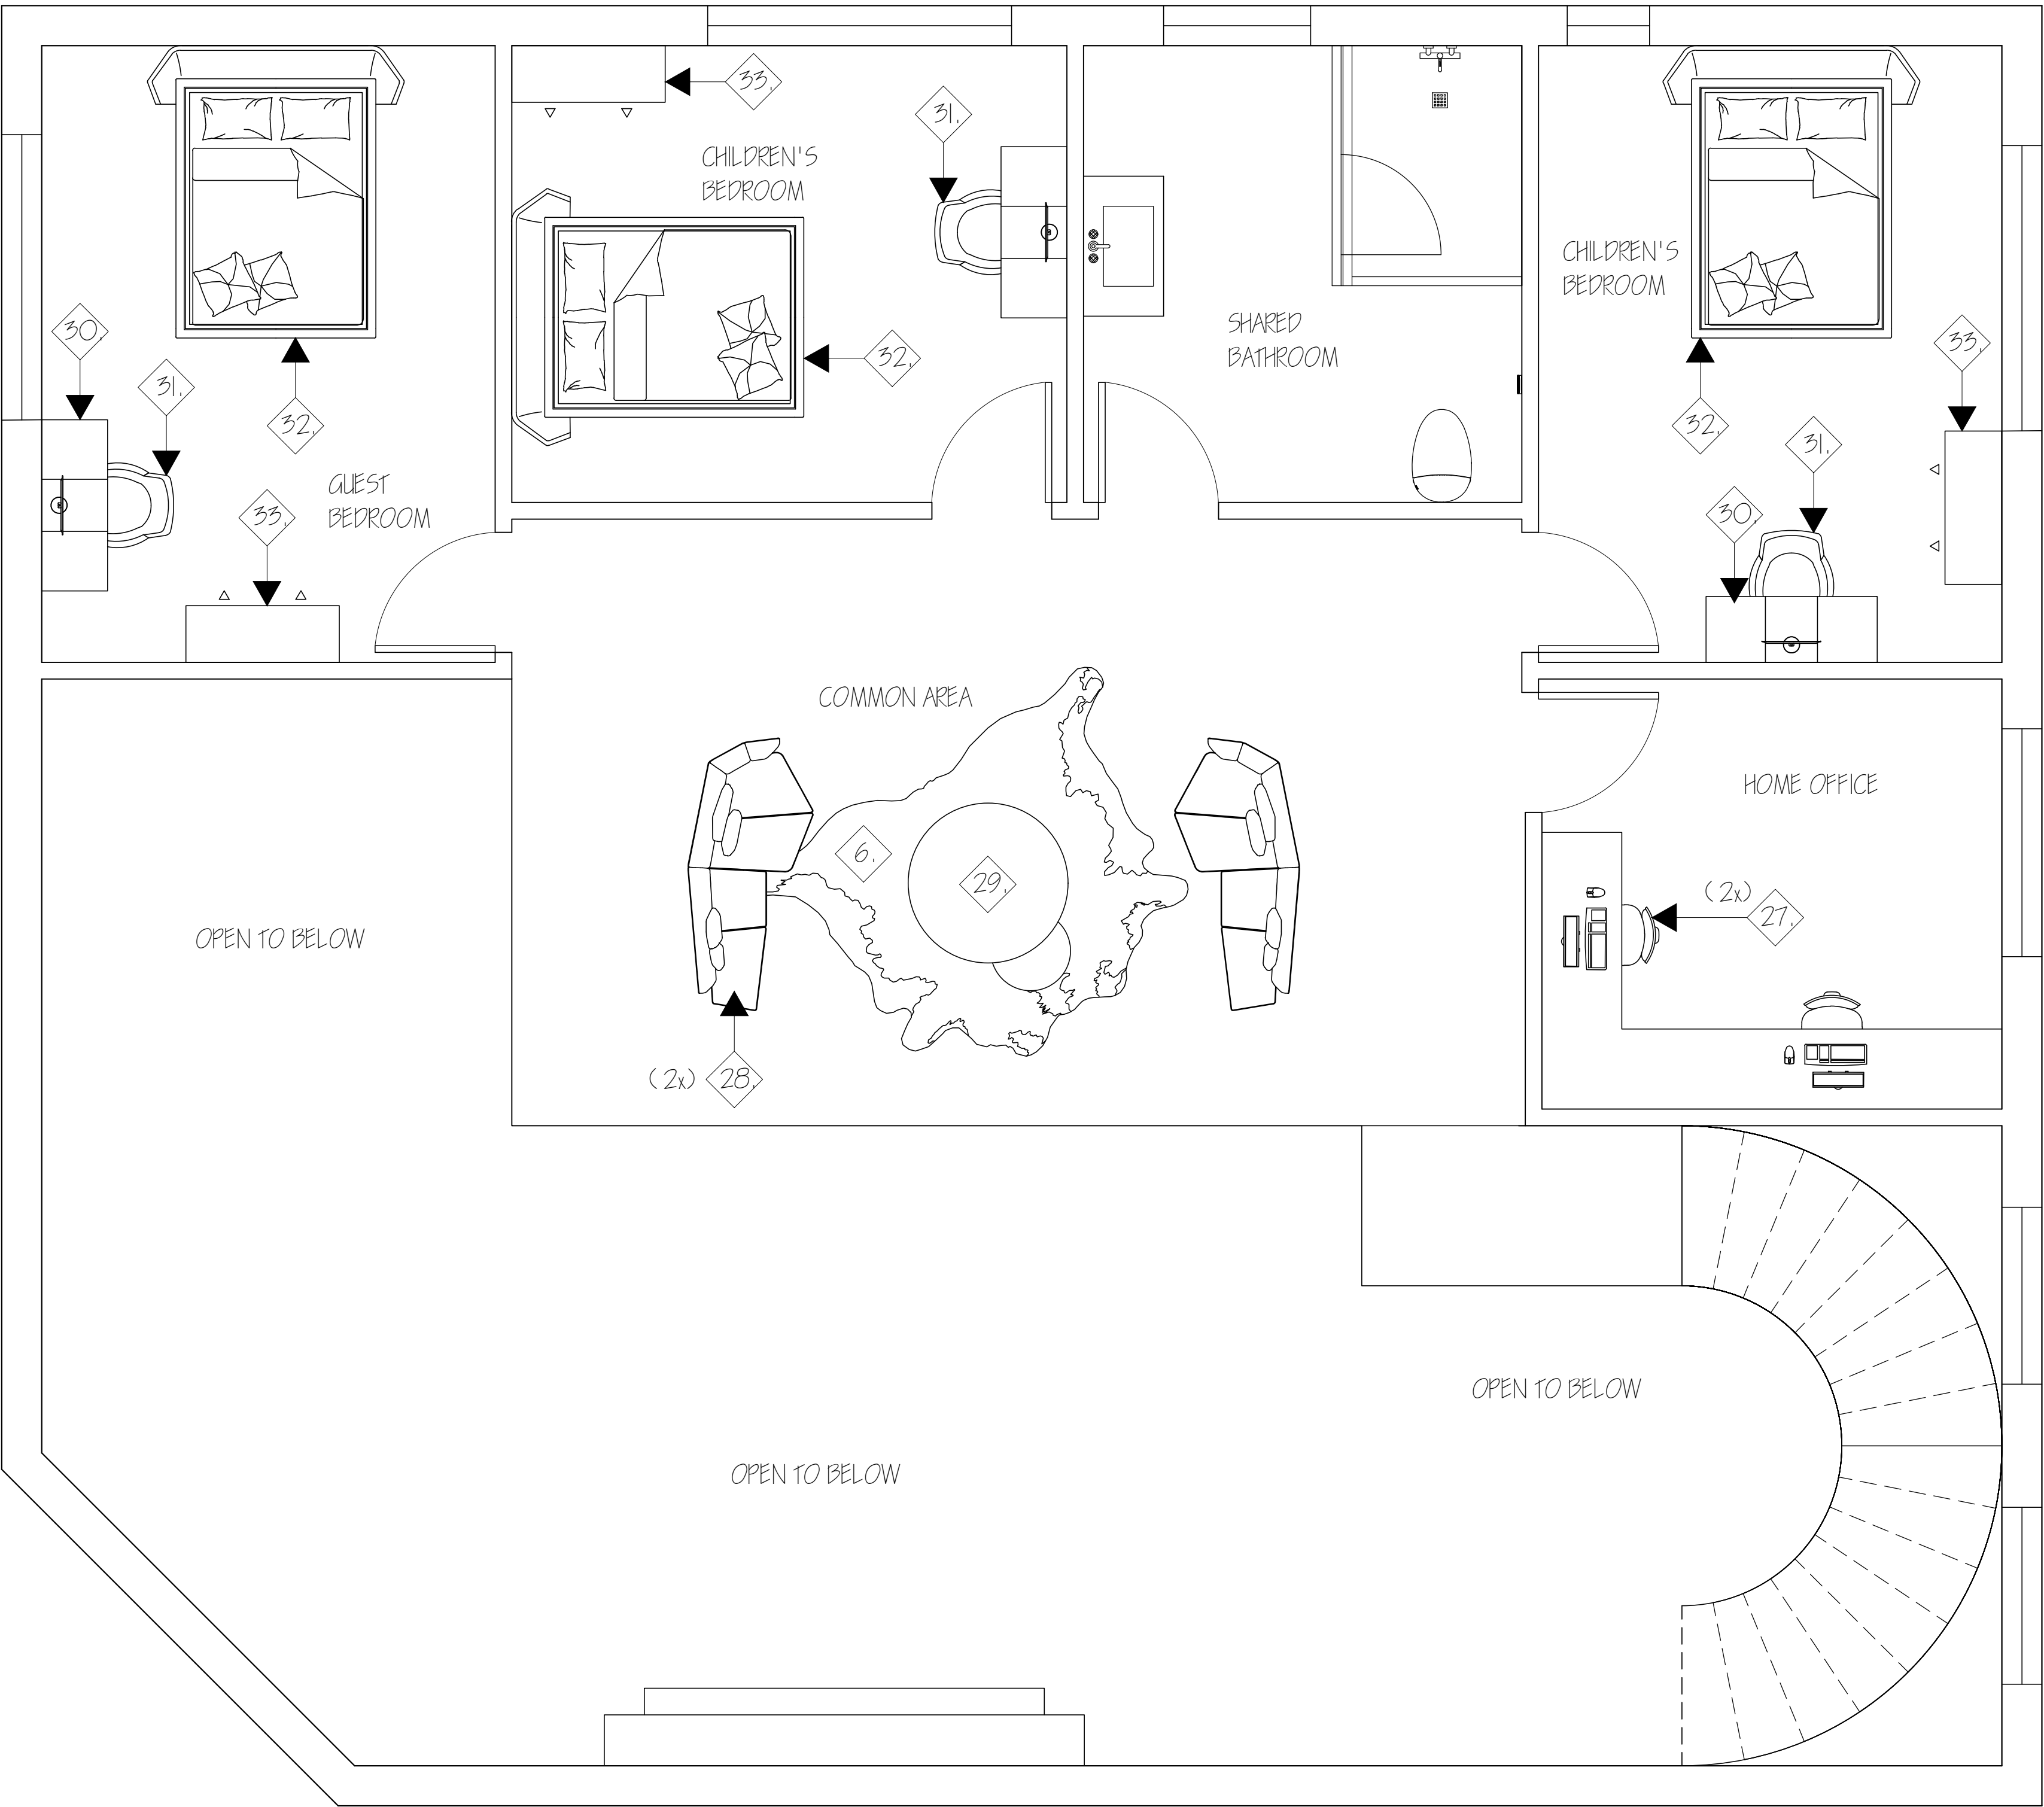

GENERAL NOTES

- FOR FURNITURE PLACEMENT REFERENCE ONLY.
- FOR FURNITURE SPECIFICATIONS AND REFERENCES REFER TO FURNITURE SCHEDULE ID-9.1
- DO NOT SCALE THE DRAWING.

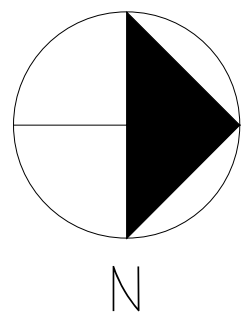

1 2ND FLOOR FURNITURE PLAN
SCALE: 1/4" = 1'-0"



PROJECT:
RESIDENTIAL COURSE PROJECT
THE ESCOFFIER RESIDENCE

RESIDENTIAL DESIGN
INDS 2313


REVISIONS:		
6		
5		
4		
3		
2		
1		

DATE: NOV 5TH, 2024

DRAFTED BY:
ALHAN VAZQUEZ


SHEET CONTENTS:
FURNITURE PLAN
2ND FLOOR

SHEET:
ID-5.2

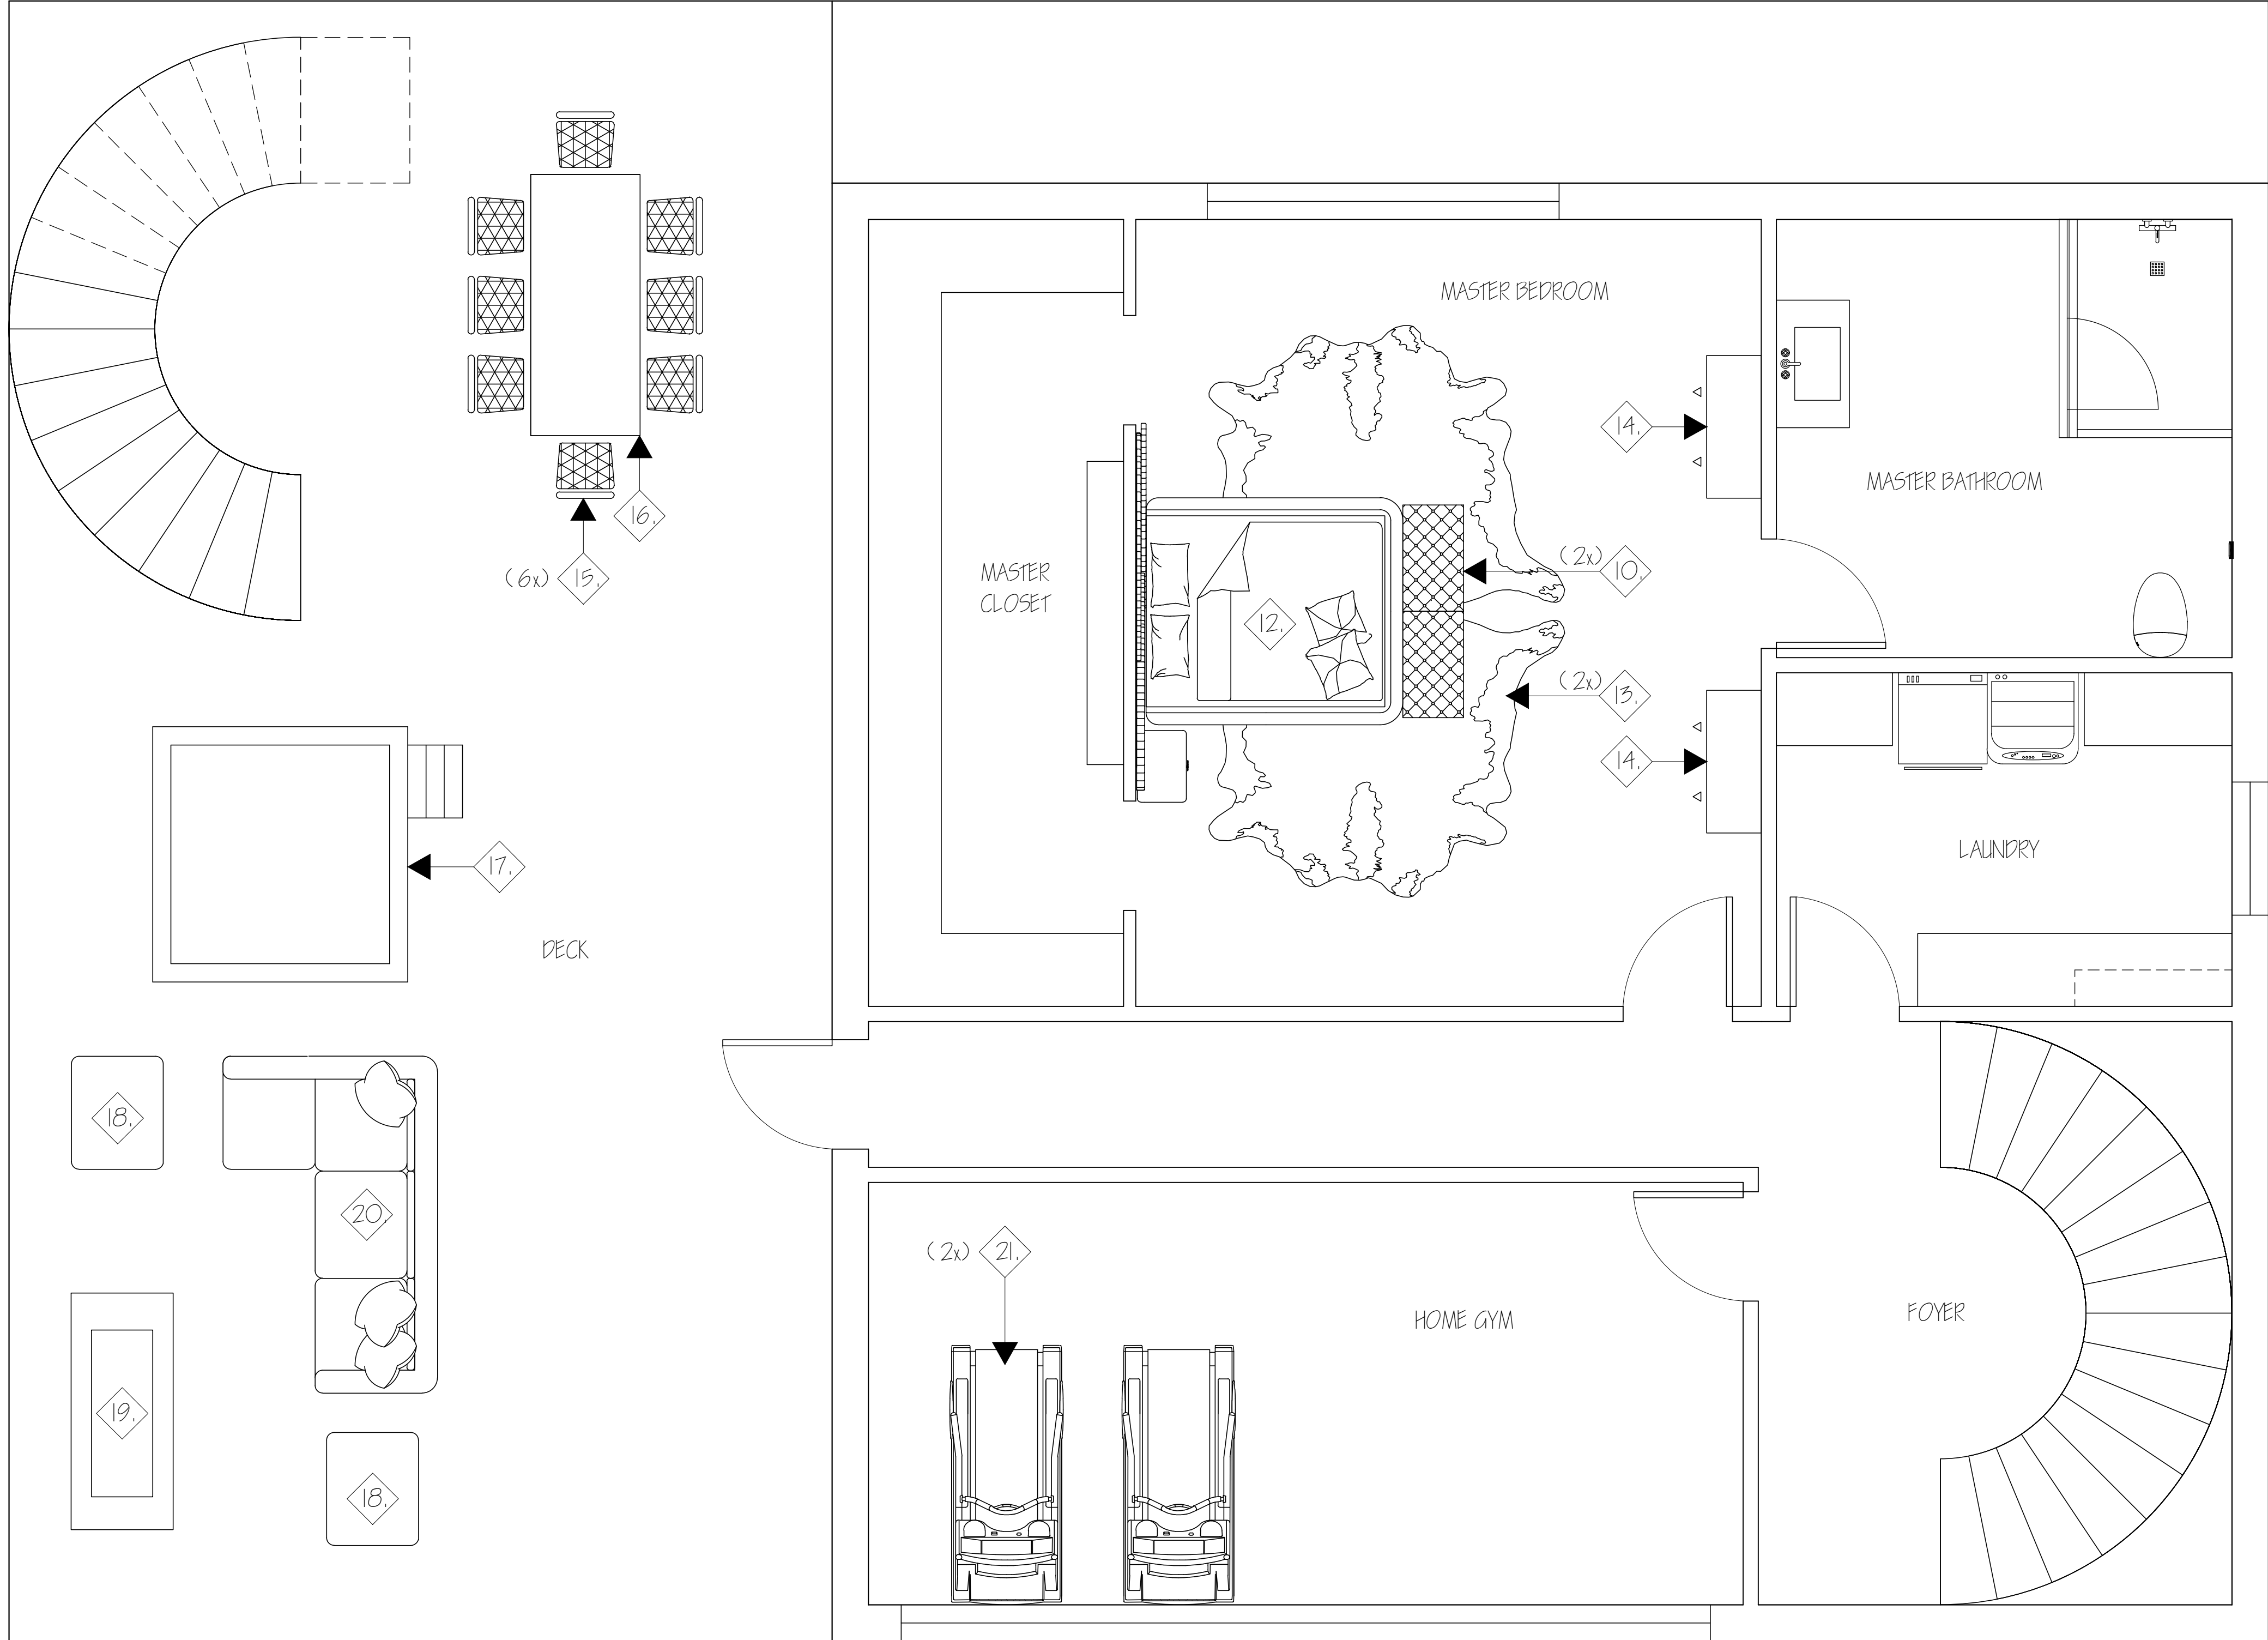

1 BASEMENT FURNITURE PLAN
SCALE: $\frac{1}{4}" = 1'-0"$

- GENERAL NOTES
- FOR FURNITURE PLACEMENT REFERENCE ONLY.
 - FOR FURNITURE SPECIFICATIONS AND REFERENCES REFER TO FURNITURE SCHEDULE ID-9.1
 - DO NOT SCALE THE DRAWING.

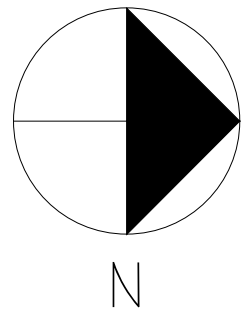

PROJECT:
RESIDENTIAL COURSE PROJECT
THE ESCOFFIER RESIDENCE

RESIDENTIAL DESIGN
INDS 2313

REVISIONS:

6		
5		
4		
3		
2		
1		

DATE: NOV 5TH, 2024

DRAFTED BY:

ALHAN VAZQUEZ

SHEET CONTENTS:

FURNITURE PLAN
BASEMENT

SHEET:

ID-5.3



PROJECT:
RESIDENTIAL COURSE PROJECT
THE ESCOFFIER RESIDENCE

RESIDENTIAL DESIGN

INDS 2313

REVISIONS:

6		
5		
4		
3		
2		
1		

DATE: NOV 5TH, 2024

DRAFTED BY:


ALHAN VAZQUEZ

SHEET CONTENTS:

KITCHEN ELEVATIONS

SHEET:

ID-6.1

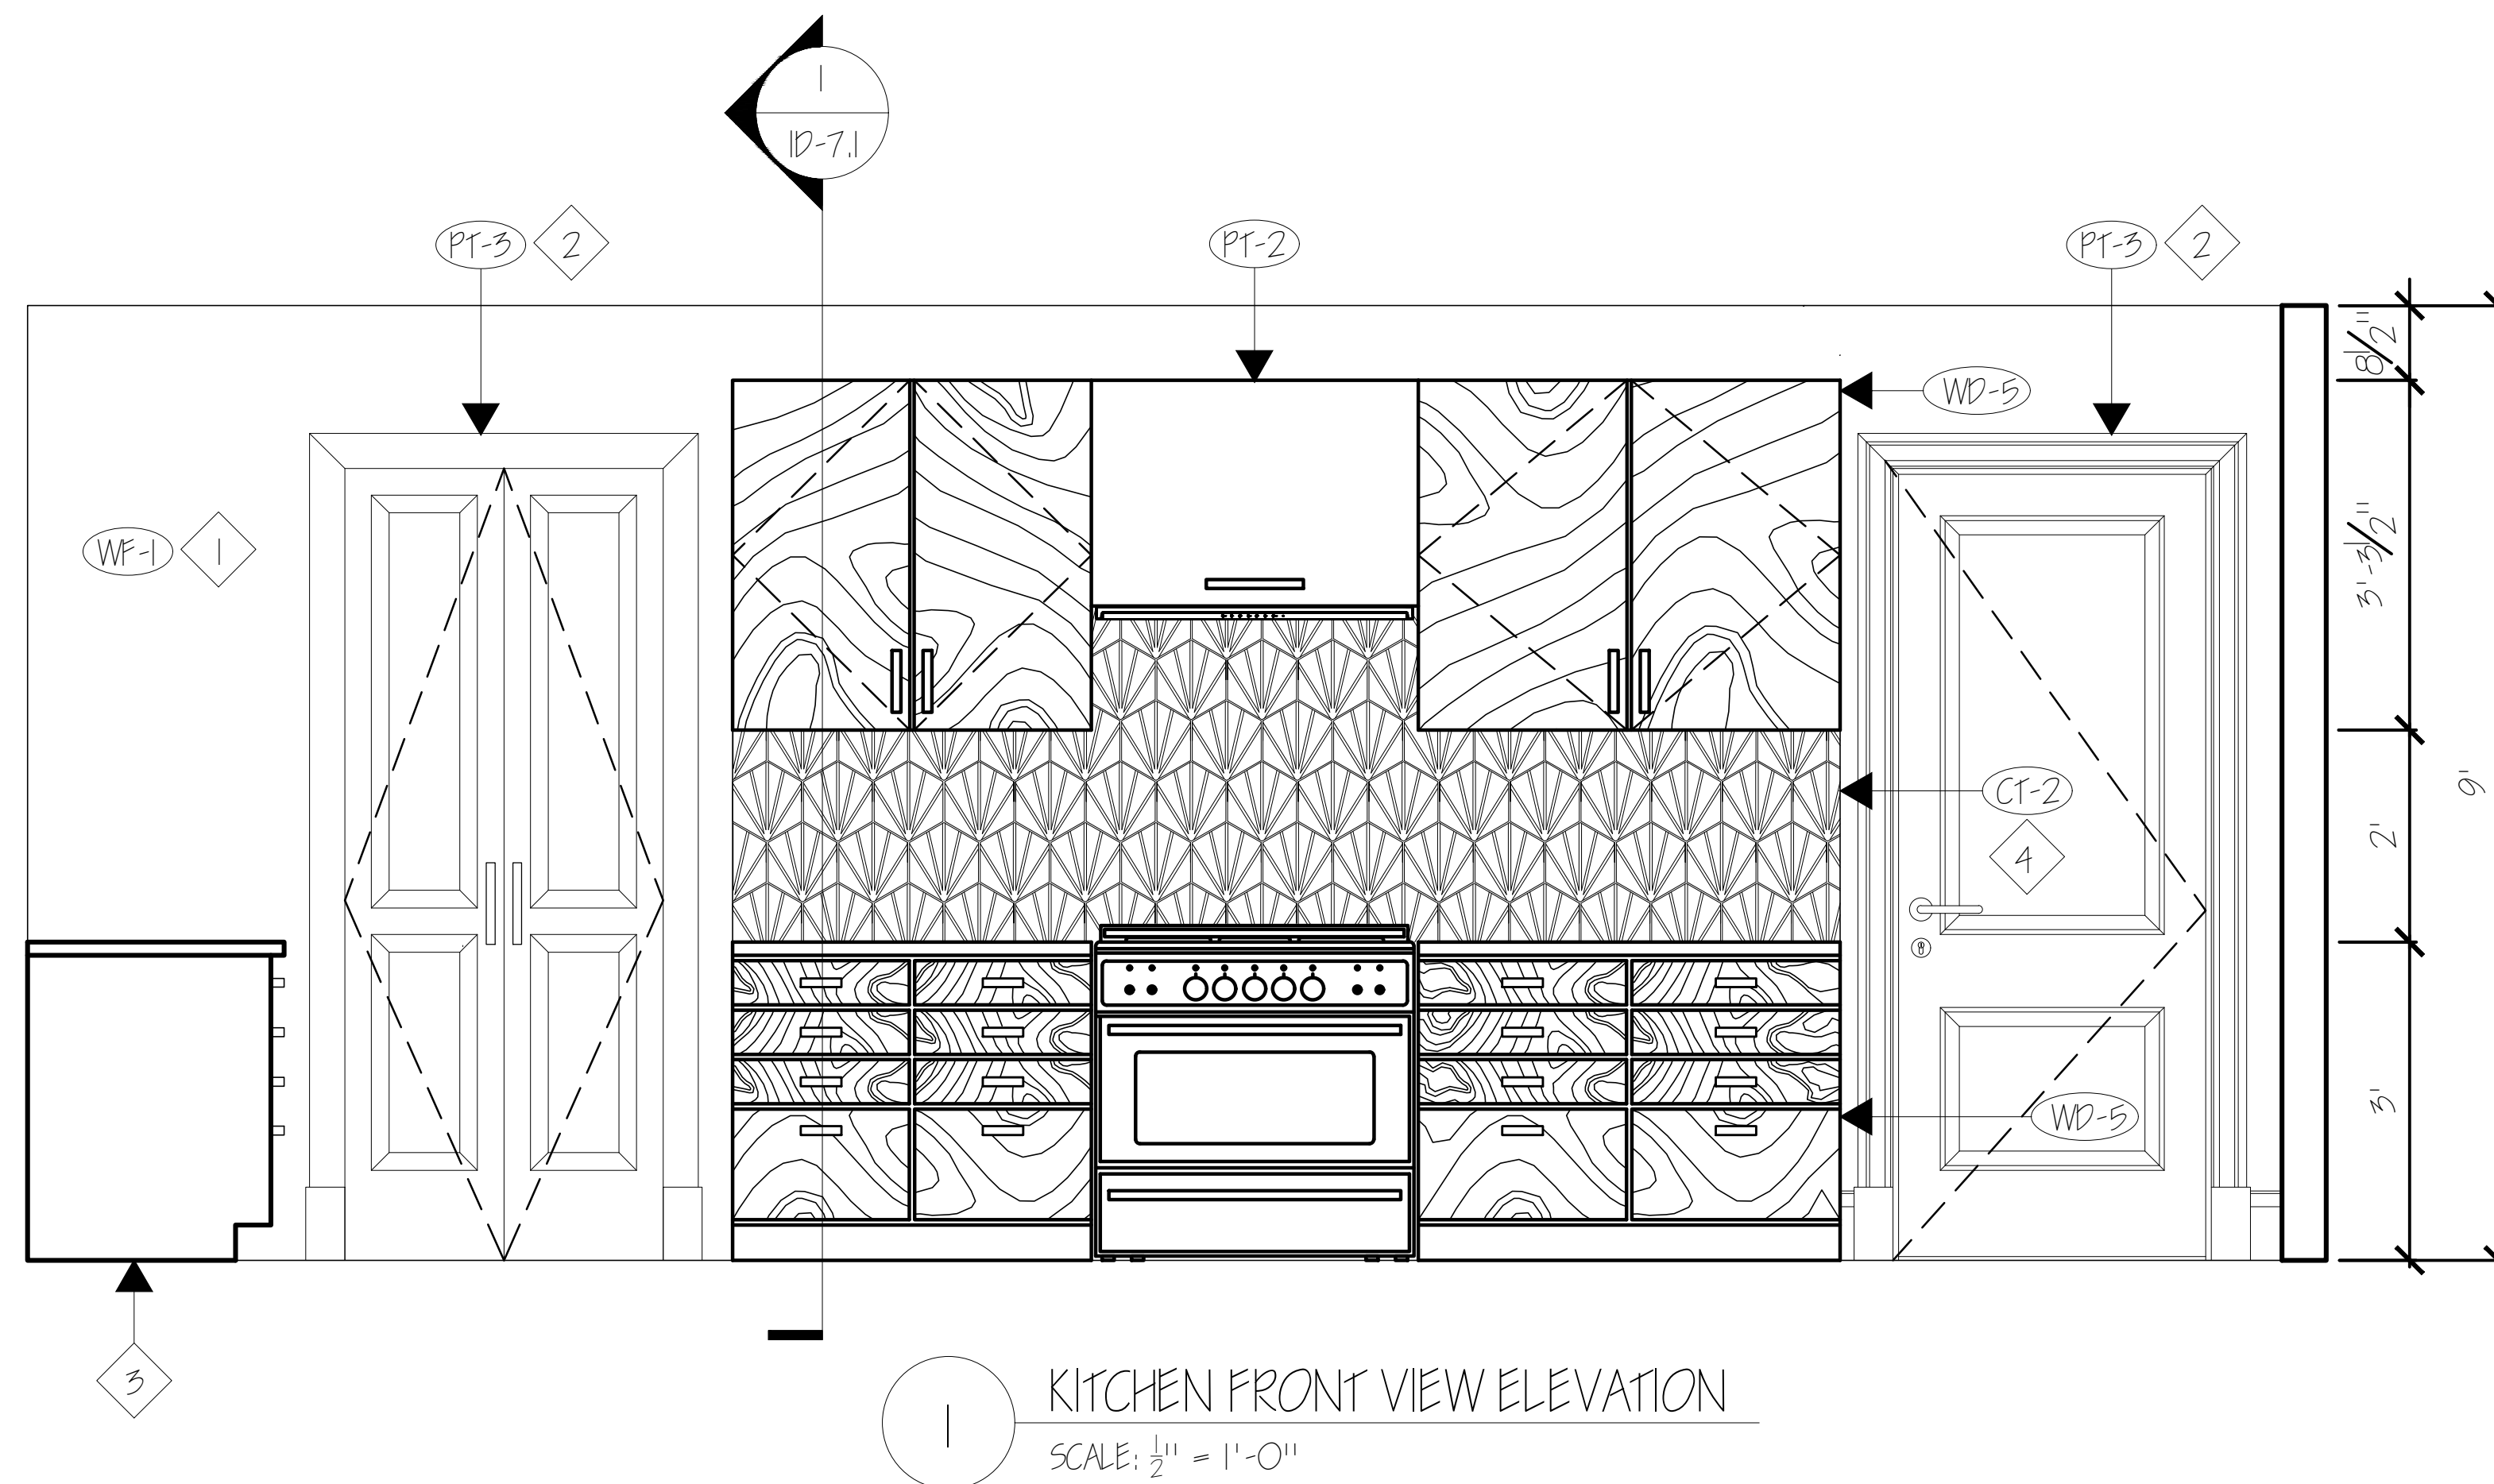


GENERAL NOTES

- ALL CEILING HEIGHTS ARE TO BE 9'-0" U.N.O.
- REFER TO THE MILLWORK SECTION DRAWING ID-7.1 FOR ADDITIONAL DETAILS.
- REFER TO THE FURNITURE SCHEDULE ID-9.1 FOR ADDITIONAL FURNITURE PLACEMENT INFORMATION.
- REFER TO MATERIAL FINISH SCHEDULE ID-8.1 FOR DETAILS ON FINISHES.
- REFER TO KITCHEN ISLAND ELEVATIONS ID-6.2 FOR DETAILS ON KITCHEN ISLAND.
- ALL KITCHEN HARDWARE IS DONE IN THE CHAMPAGNE BRONZE FINISH.

PLAN NOTES

1. ALL WALLS IN THIS ROOM RECEIVE THIS FINISH.
2. ALL ROOM DOORS INSIDE THE KITCHEN ARE PAINTED IN PT-3 ONLY IN THE SIDE OF THE DOOR FACING THE KITCHEN.
3. CABINET SIDES TO HAVE WF-1 SURFACE FINISH.
4. ALL TILE TO BE GROUTED WITH GR-1.
5. REFRIGERATOR PANELING IS IN PT-2 HYPER BLUE HUE FINISH.

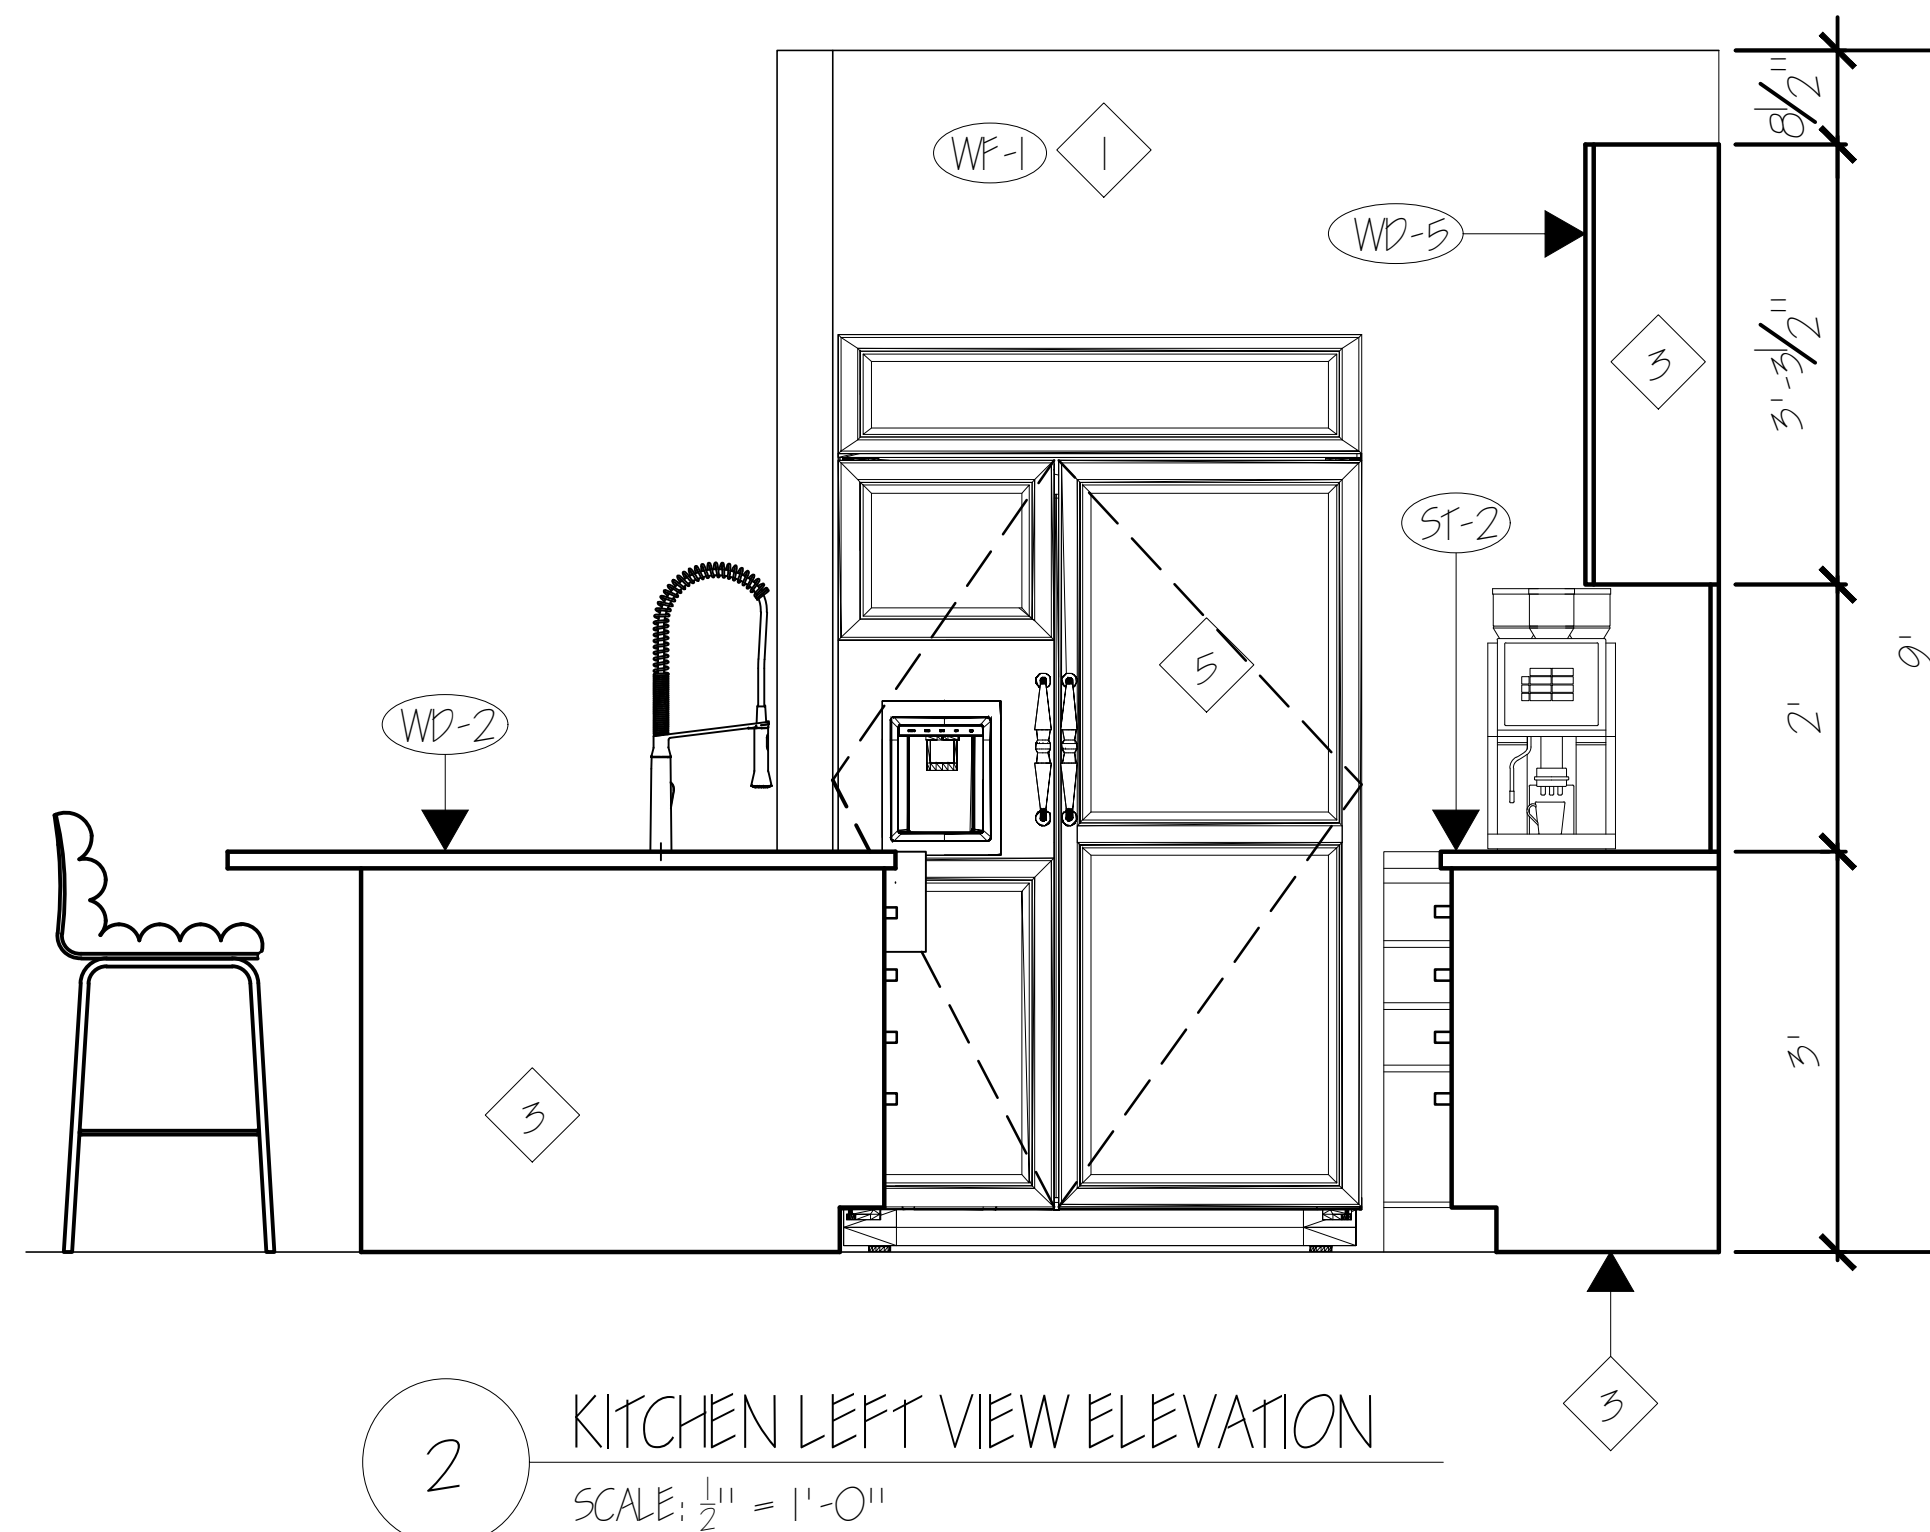



PROJECT:
RESIDENTIAL COURSE PROJECT
THE ESCOFFIER RESIDENCE

RESIDENTIAL DESIGN
INDS 2313

REVISIONS:

6		
5		
4		
3		
2		
1		

DATE: NOV 5TH, 2024

DRAFTED BY:

ALHAN VAZQUEZ

SHEET CONTENTS:

KITCHEN ISLAND
ELEVATIONS

SHEET:


ID-6.2

GENERAL NOTES


- REFER TO MATERIAL FINISH SCHEDULE ID-8.1 FOR DETAILS ON FINISHES.
- ALL ISLAND HARDWARE IS DONE IN THE CHAMPAGNE BRONZE FINISH.

PLAN NOTES


- THE THICKNESS OF THE LIVE EDGE WOOD COUNTERTOP IS $1\frac{1}{2}$ ".
- THE COUNTER OVERHANG IS 1" PAST THE EDGE OF THE ISLAND CABINETS HERE.
- ISLAND MATERIAL FINISH TO HAVE WF-1 SURFACE FINISH.
- VAIL BAR STOOL SADDLE LEATHER FINISH.

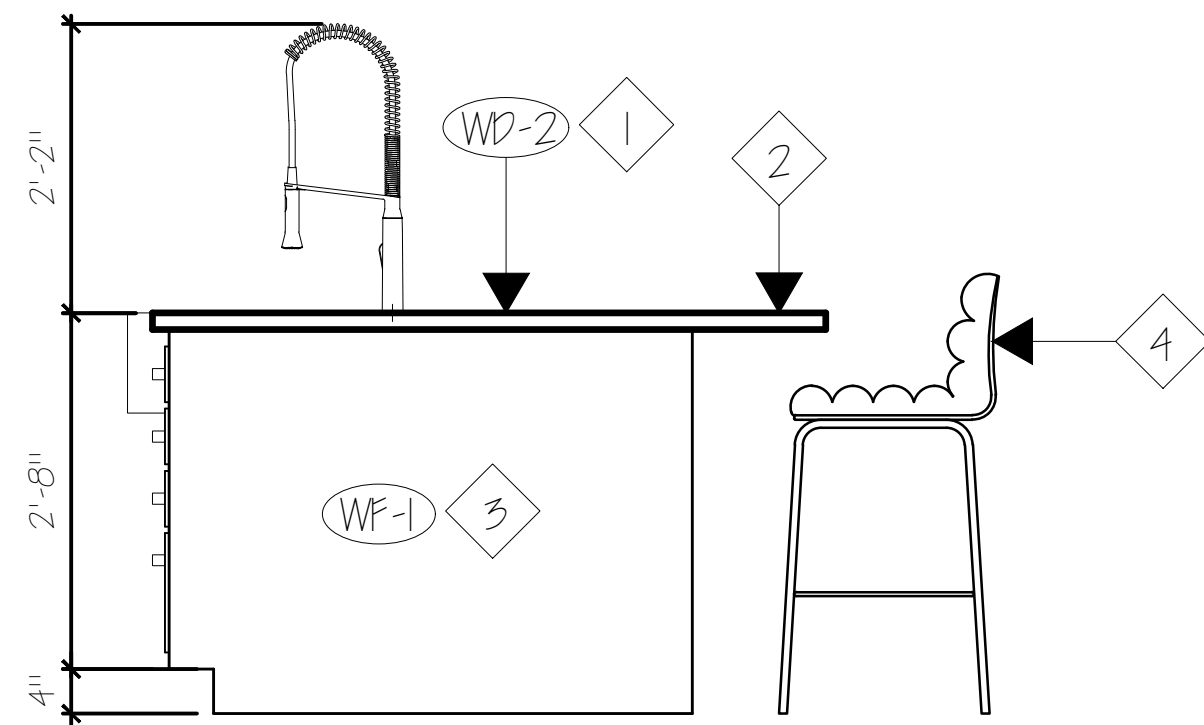


1 KITCHEN ISLAND RIGHT VIEW ELEVATION
SCALE: $\frac{1}{2}$ " = 1'-0"

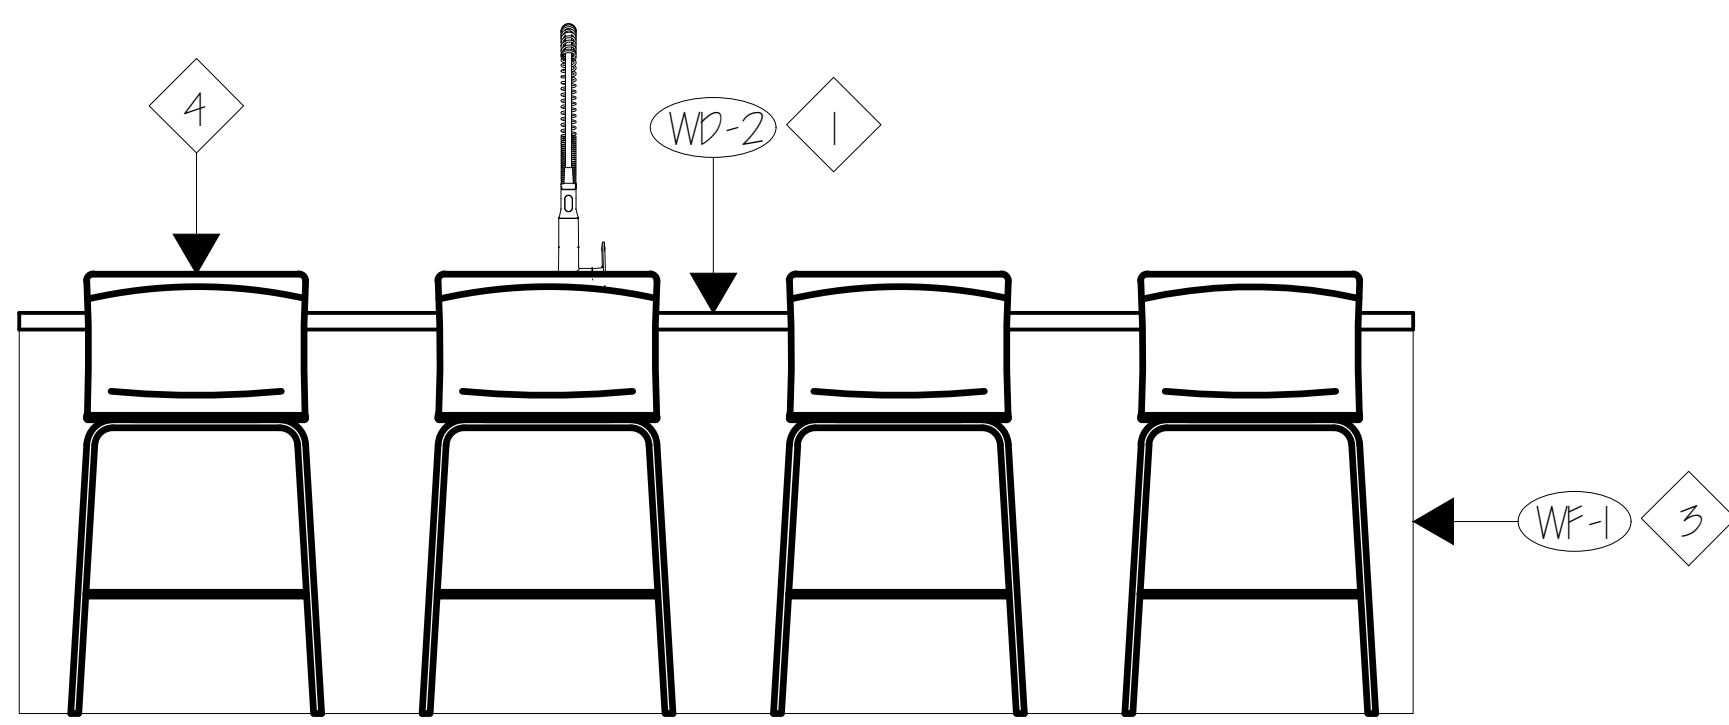

2 KITCHEN ISLAND REAR VIEW ELEVATION
SCALE: $\frac{1}{2}$ " = 1'-0"

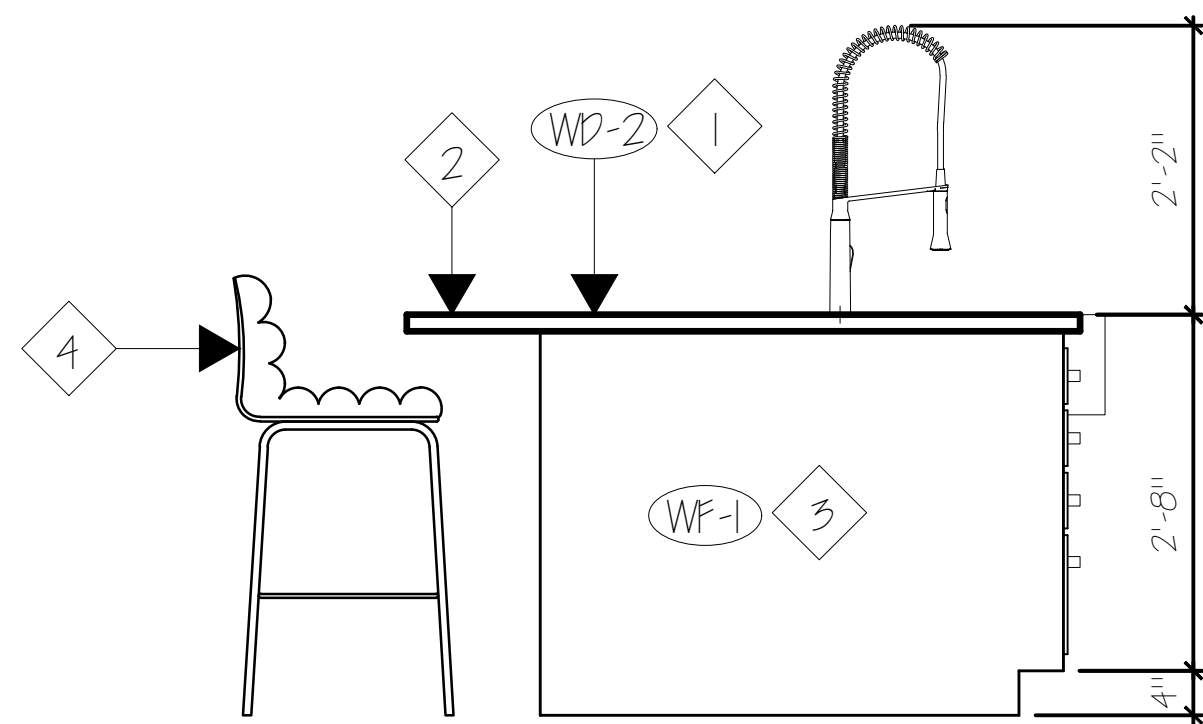


3 KITCHEN ISLAND LEFT VIEW ELEVATION
SCALE: $\frac{1}{2}$ " = 1'-0"

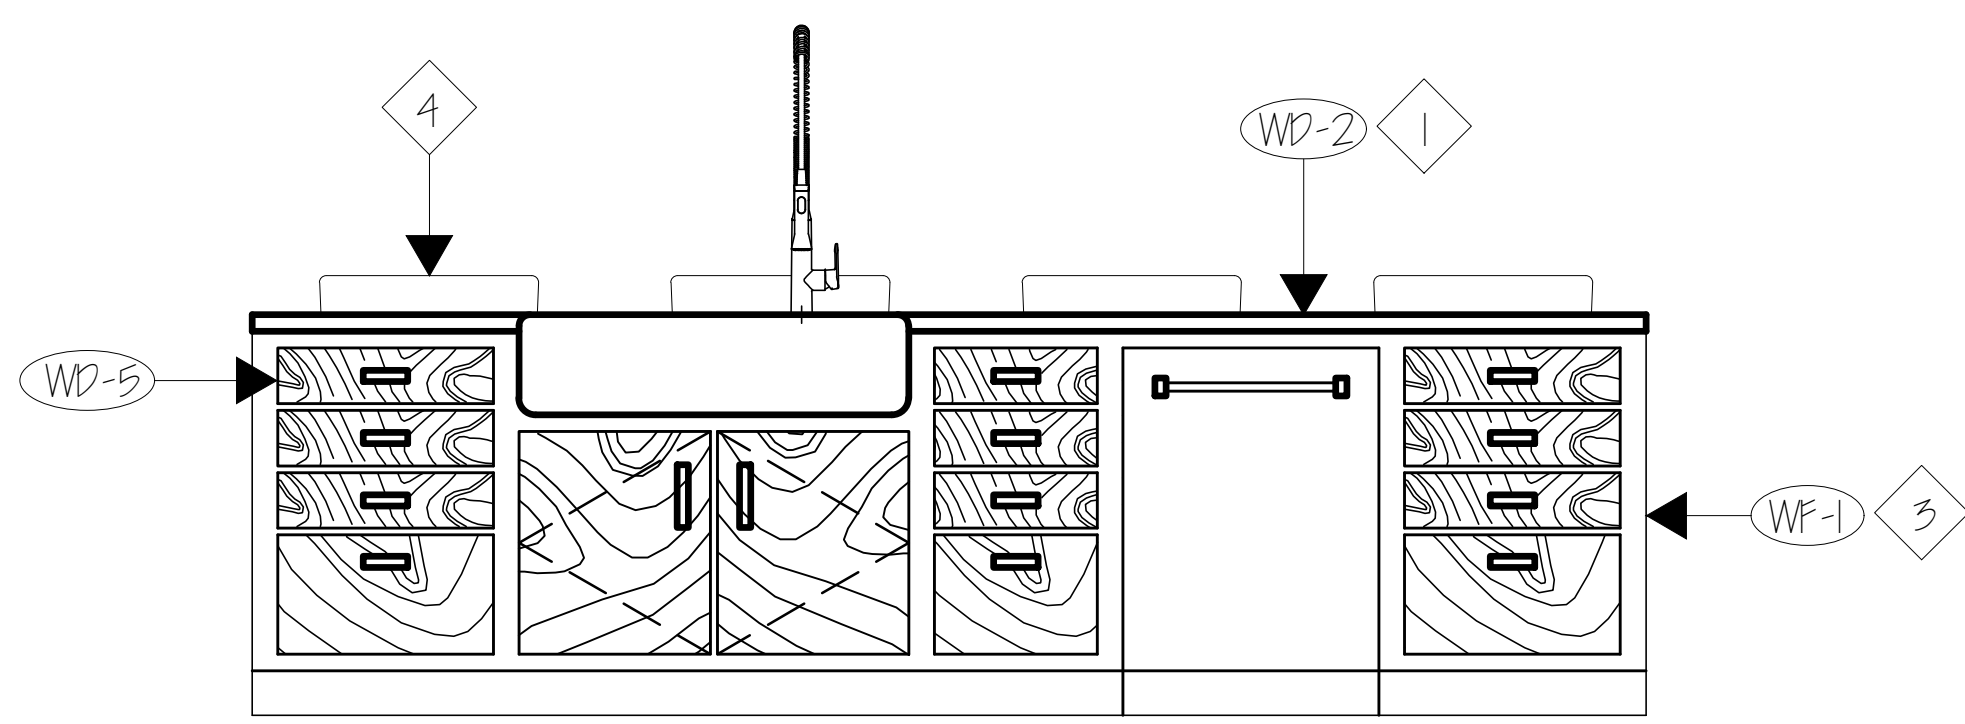


4 KITCHEN ISLAND FRONT VIEW ELEVATION
SCALE: $\frac{1}{2}$ " = 1'-0"


6		
5		
4		
3		
2		
1		

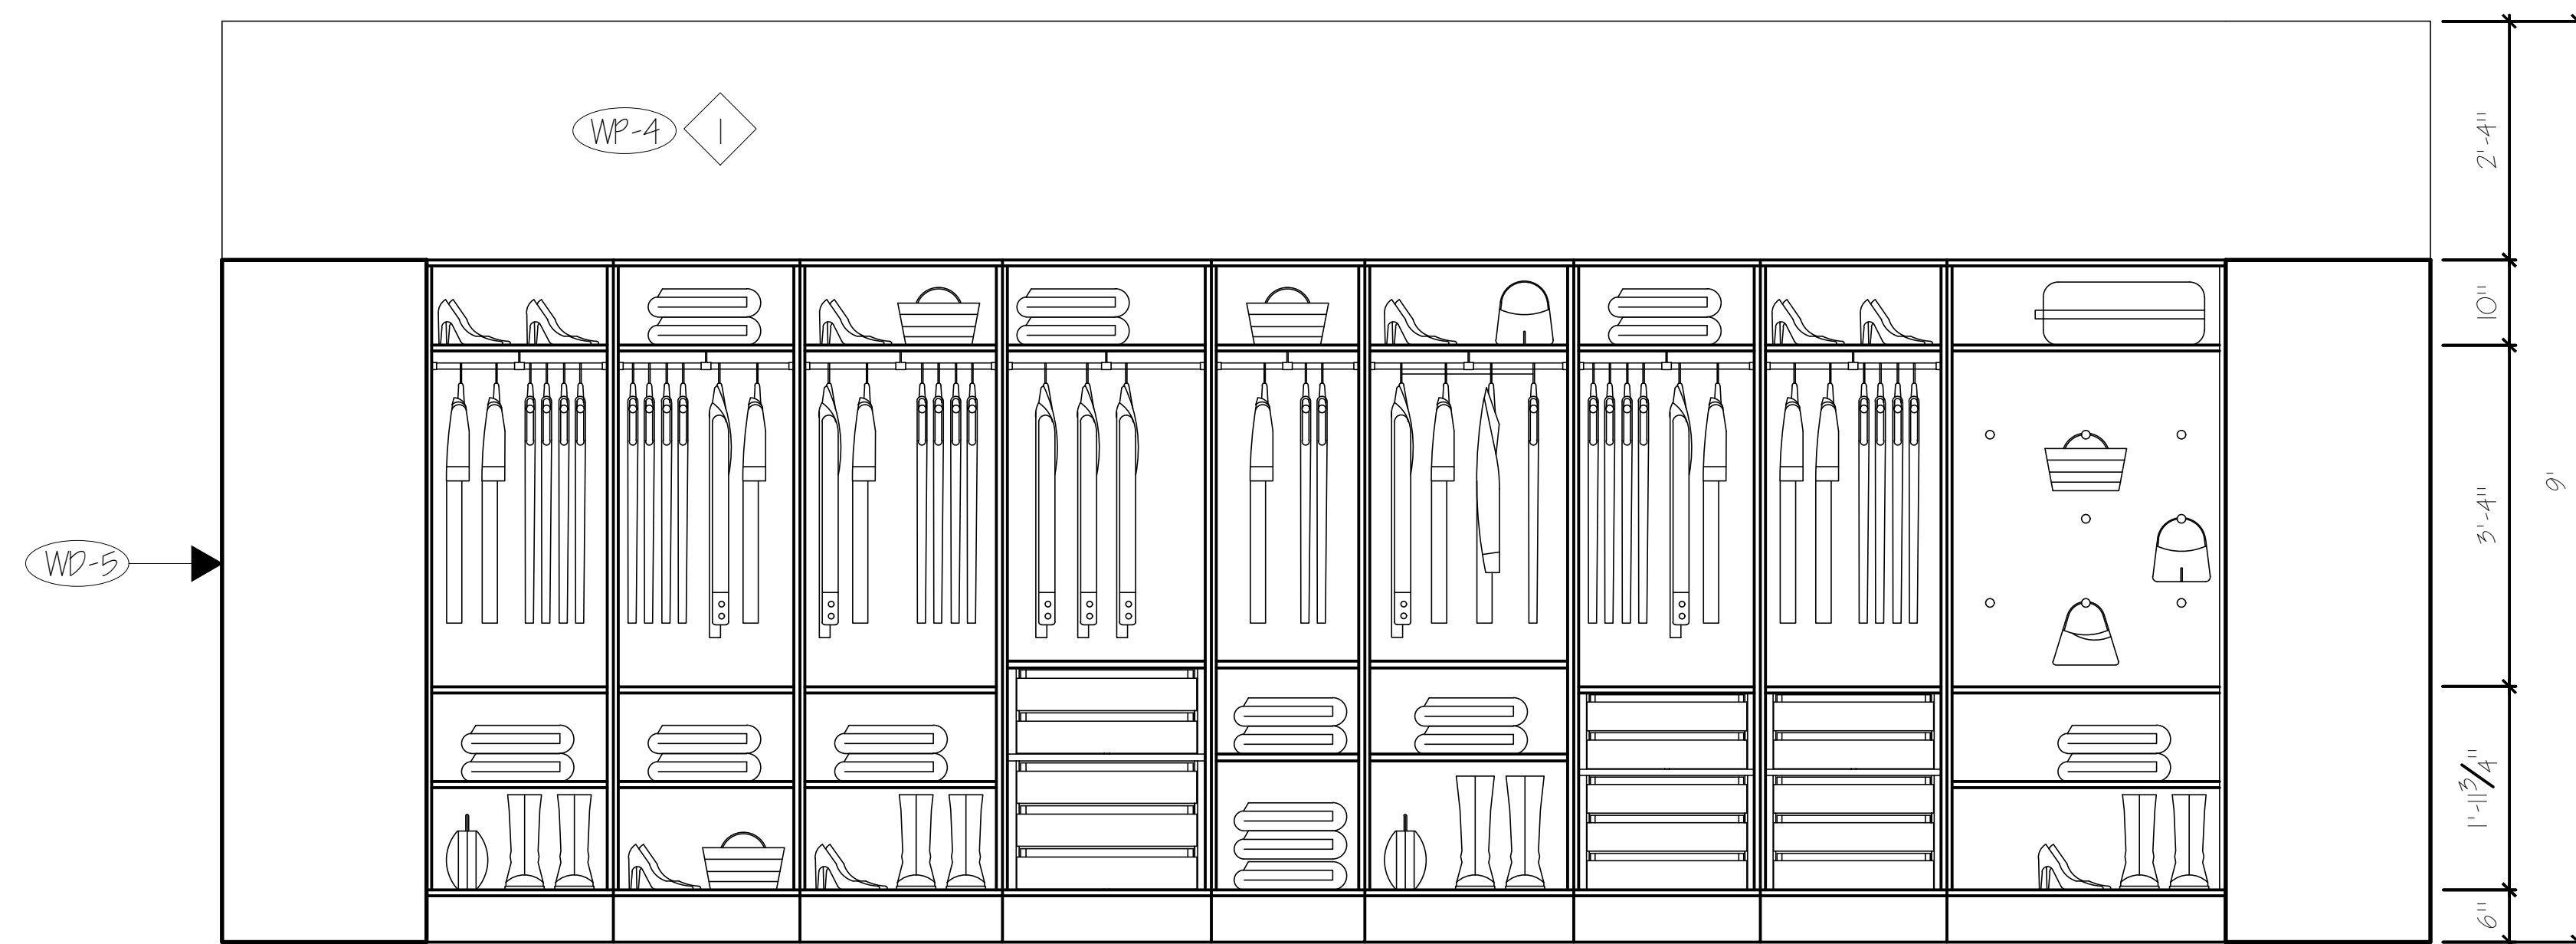

1 MASTER CLOSET FRONT VIEW ELEVATION
SCALE: 1/2" = 1'-0"

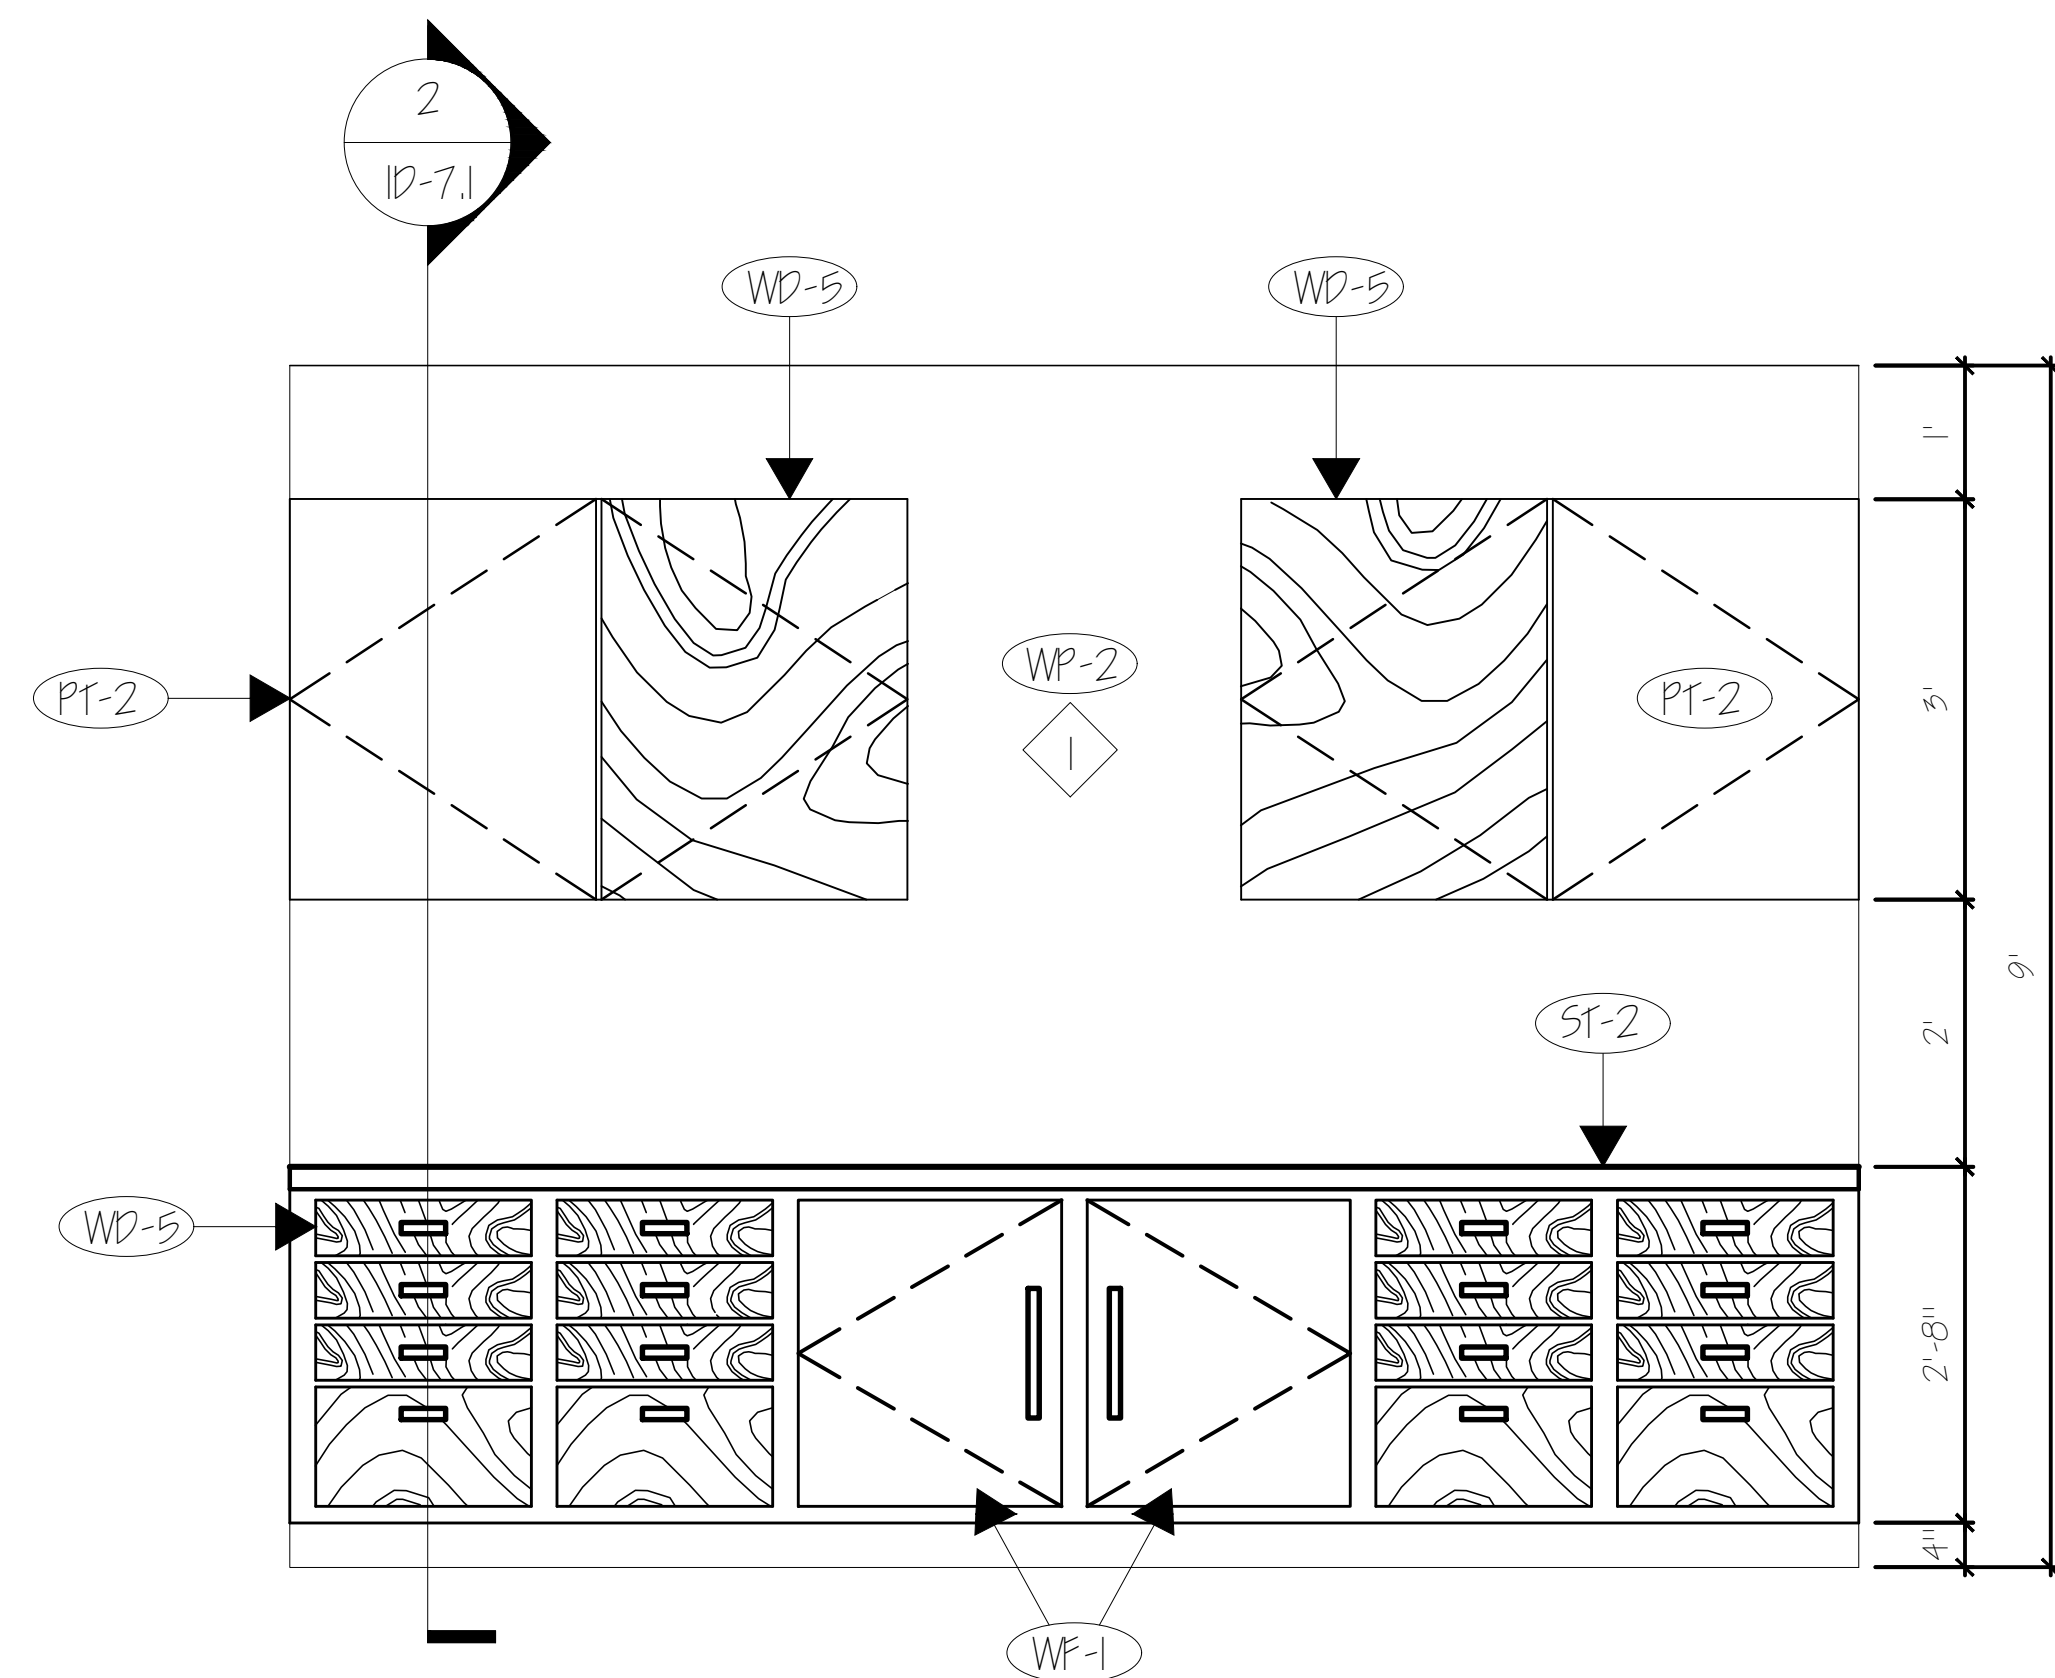

2 PANTRY RIGHT VIEW ELEVATION
SCALE: 1/2" = 1'-0"

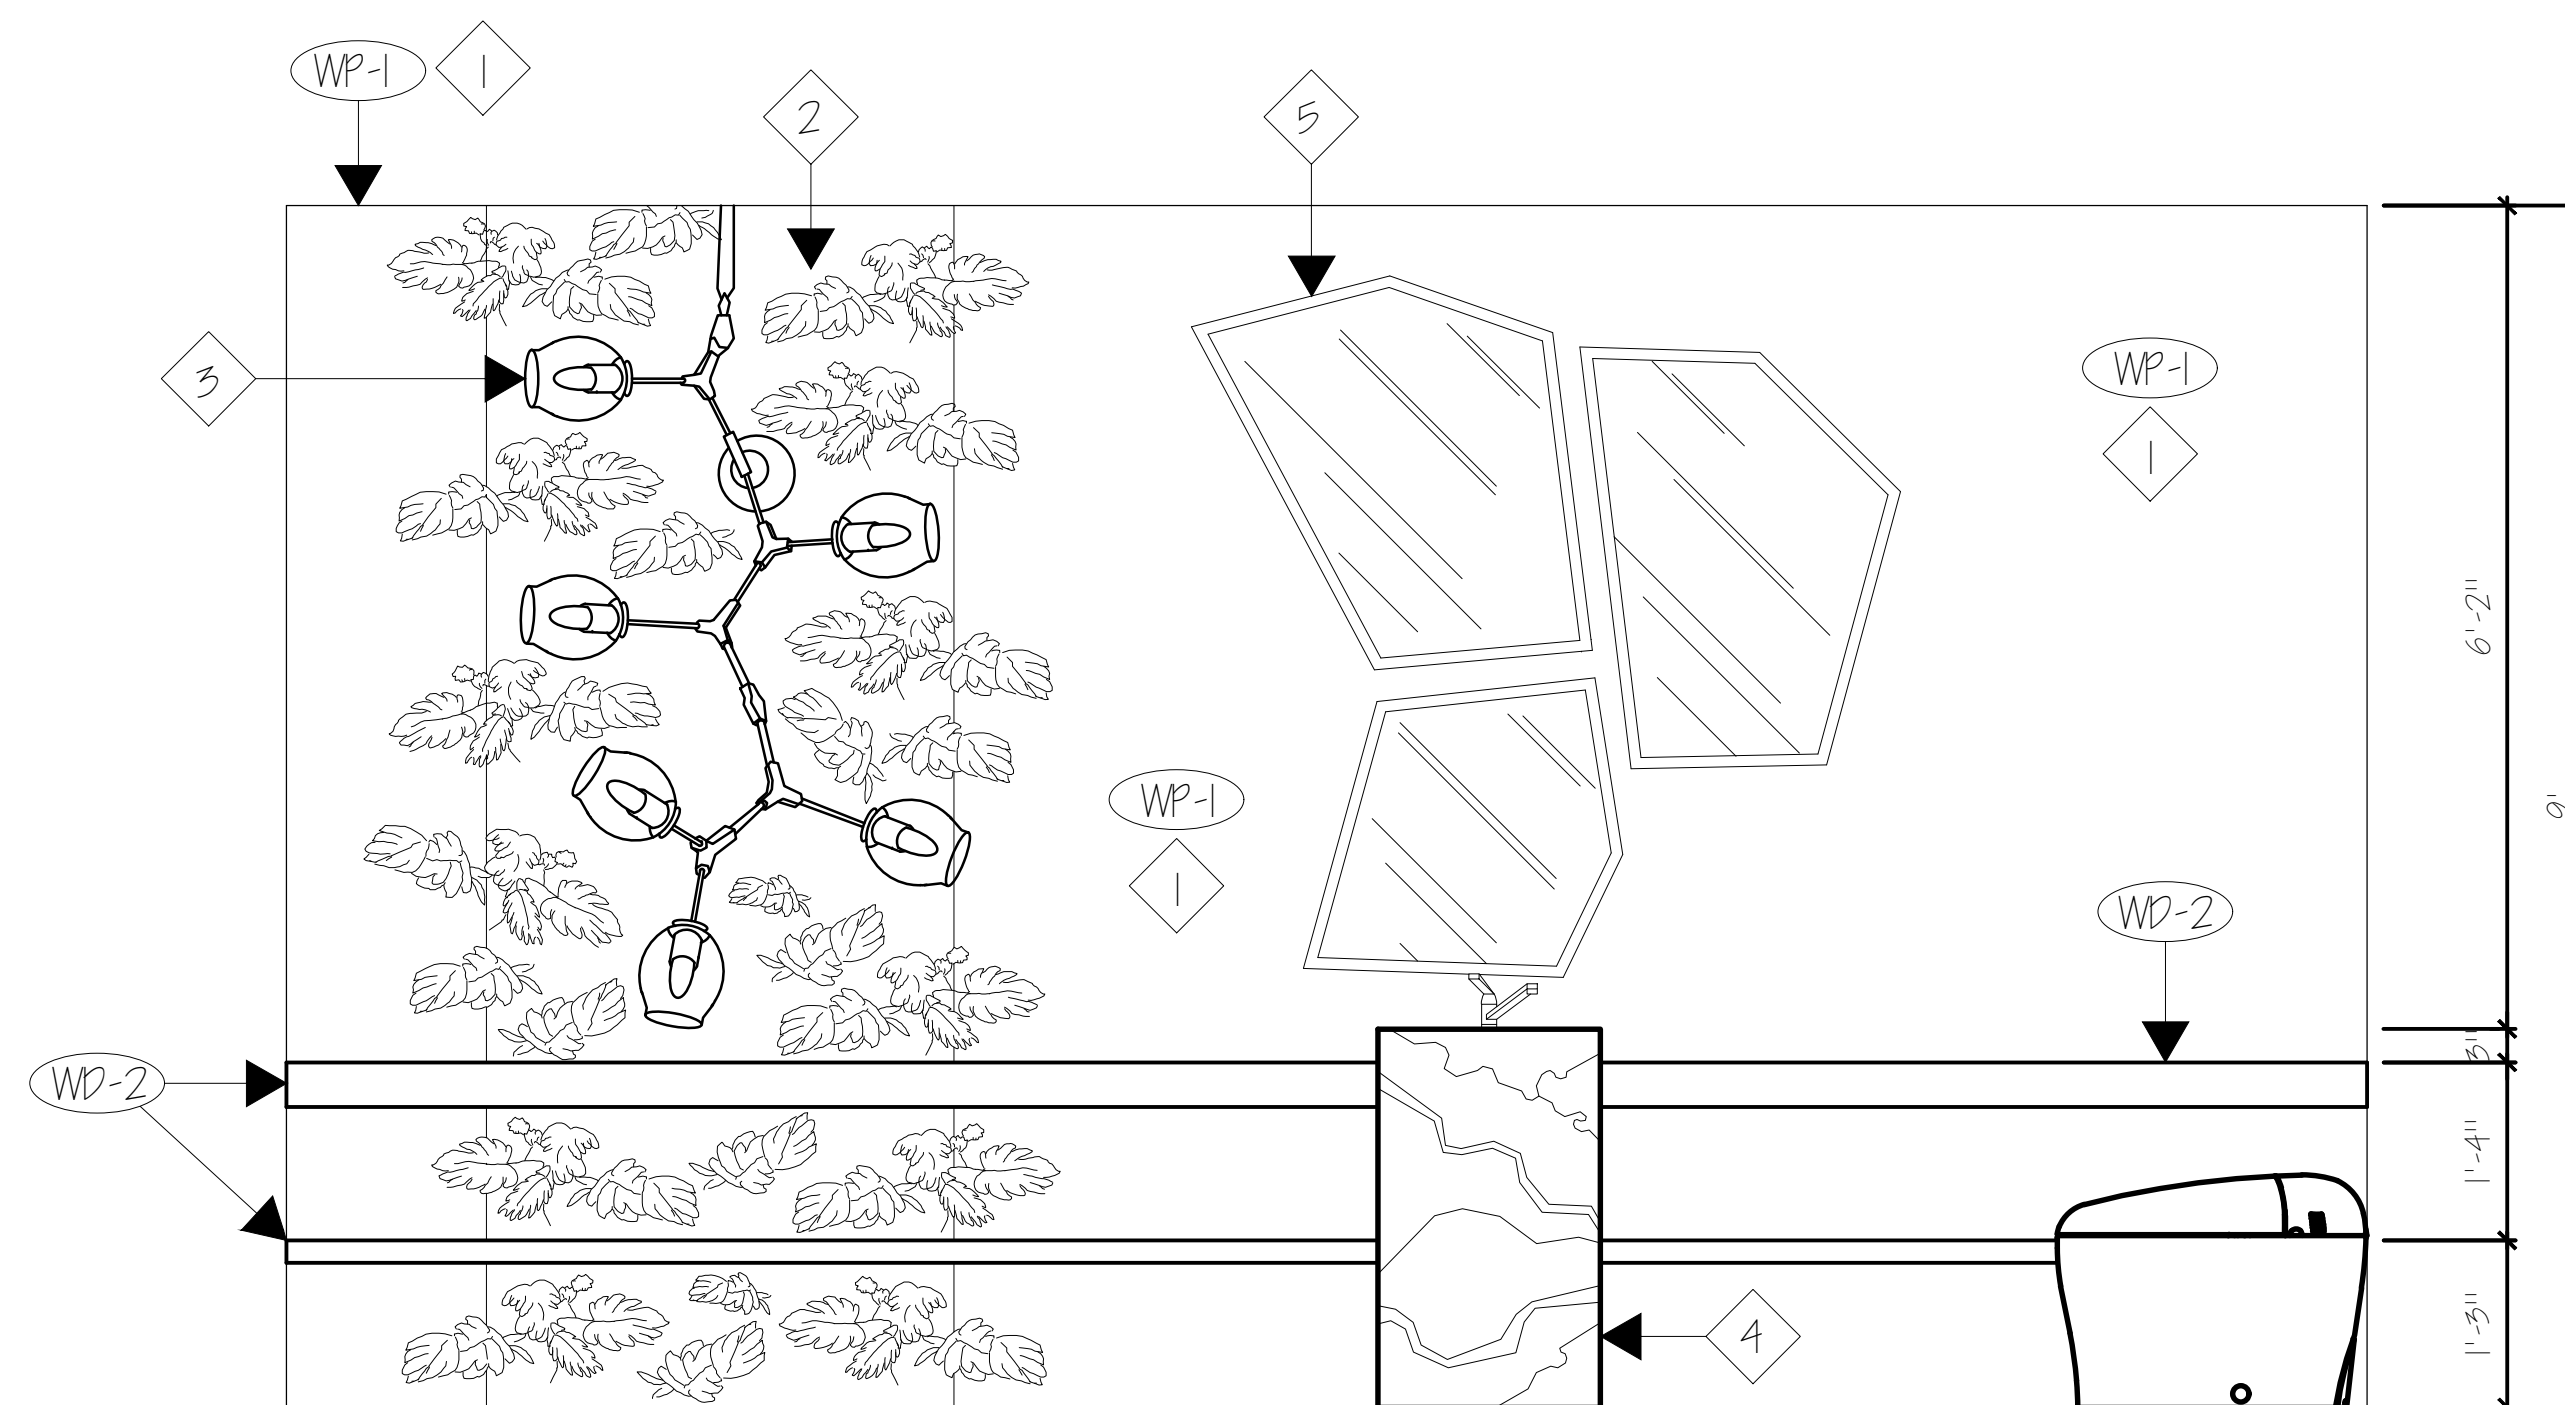


3 POWDER ROOM FRONT VIEW ELEVATION
SCALE: 1/2" = 1'-0"

GENERAL NOTES


- ALL CEILING HEIGHTS ARE TO BE 9'-0" U.N.O.
- REFER TO THE MILLWORK SECTION DRAWINGS ID-7.1 FOR ADDITIONAL DETAILS.
- REFER TO THE FURNITURE SCHEDULE ID-9.1 FOR ADDITIONAL FURNITURE PLACEMENT INFORMATION.
- REFER TO MATERIAL FINISH SCHEDULE ID-8.1 FOR DETAILS ON FINISHES.
- ALL PANTRY HARDWARE IS DONE IN THE CHAMPAGNE BRONZE FINISH.

PLAN NOTES

1. THE ENTIRE WALL IN THIS ROOM RECEIVE THIS FINISH.
2. CUSTOM GREEN PLANT FEATURE WALL.
3. METAL RELEAF VERTICAL GLOBE BRANCHING BUBBLE CHANDELIER.
4. WHITE MARBLE PATTERN PEDESTAL.
5. KALALOU GEOMETRIC MIRROR SET OF 3.

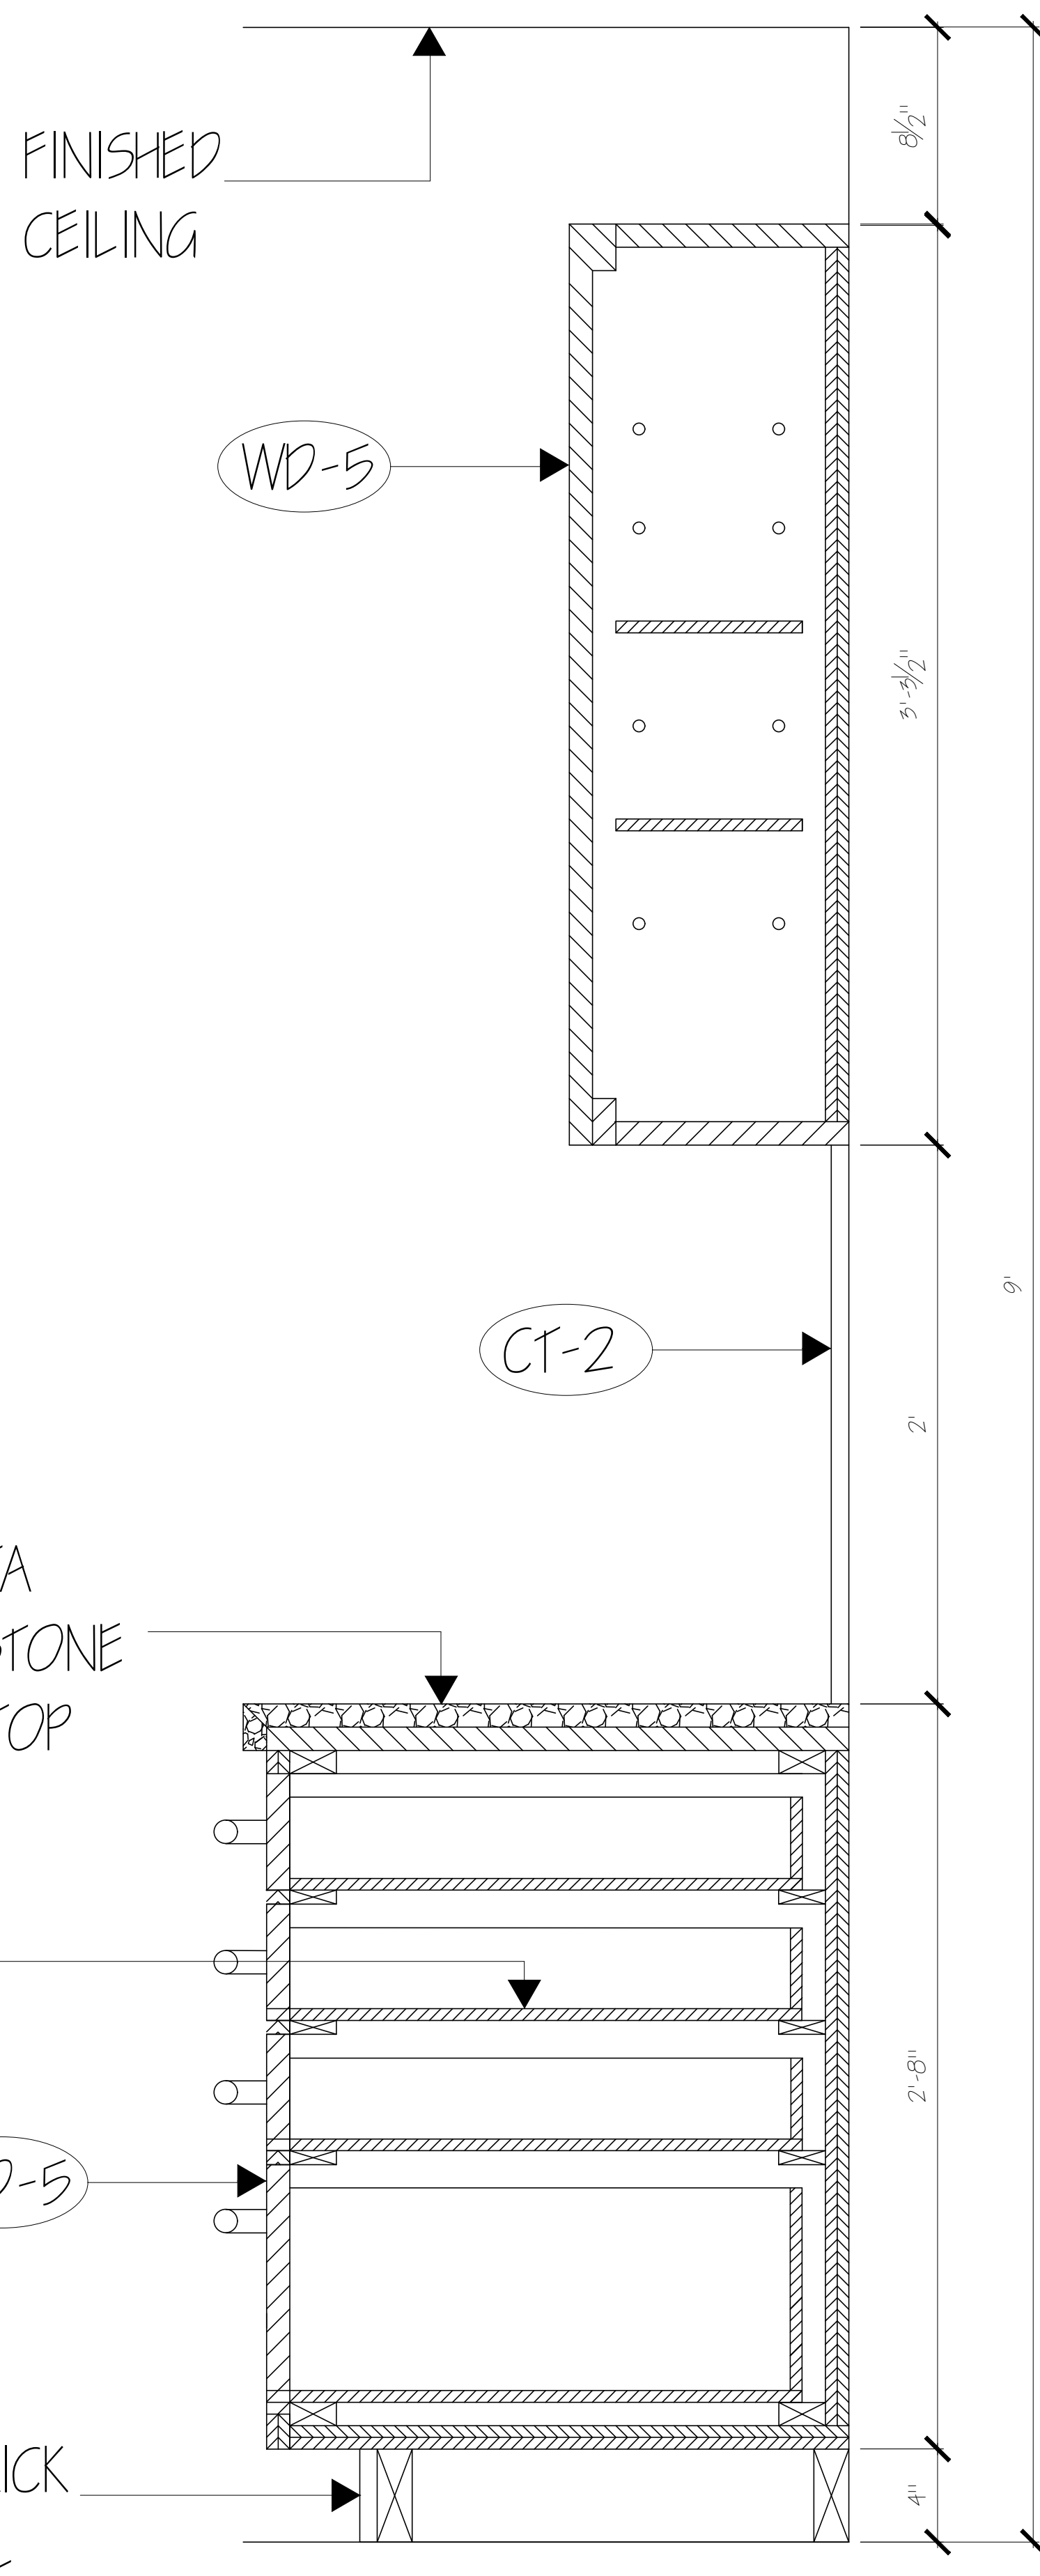

1 KITCHEN CABINET SECTION
SCALE: $\frac{1}{2}" = 1'-0"$

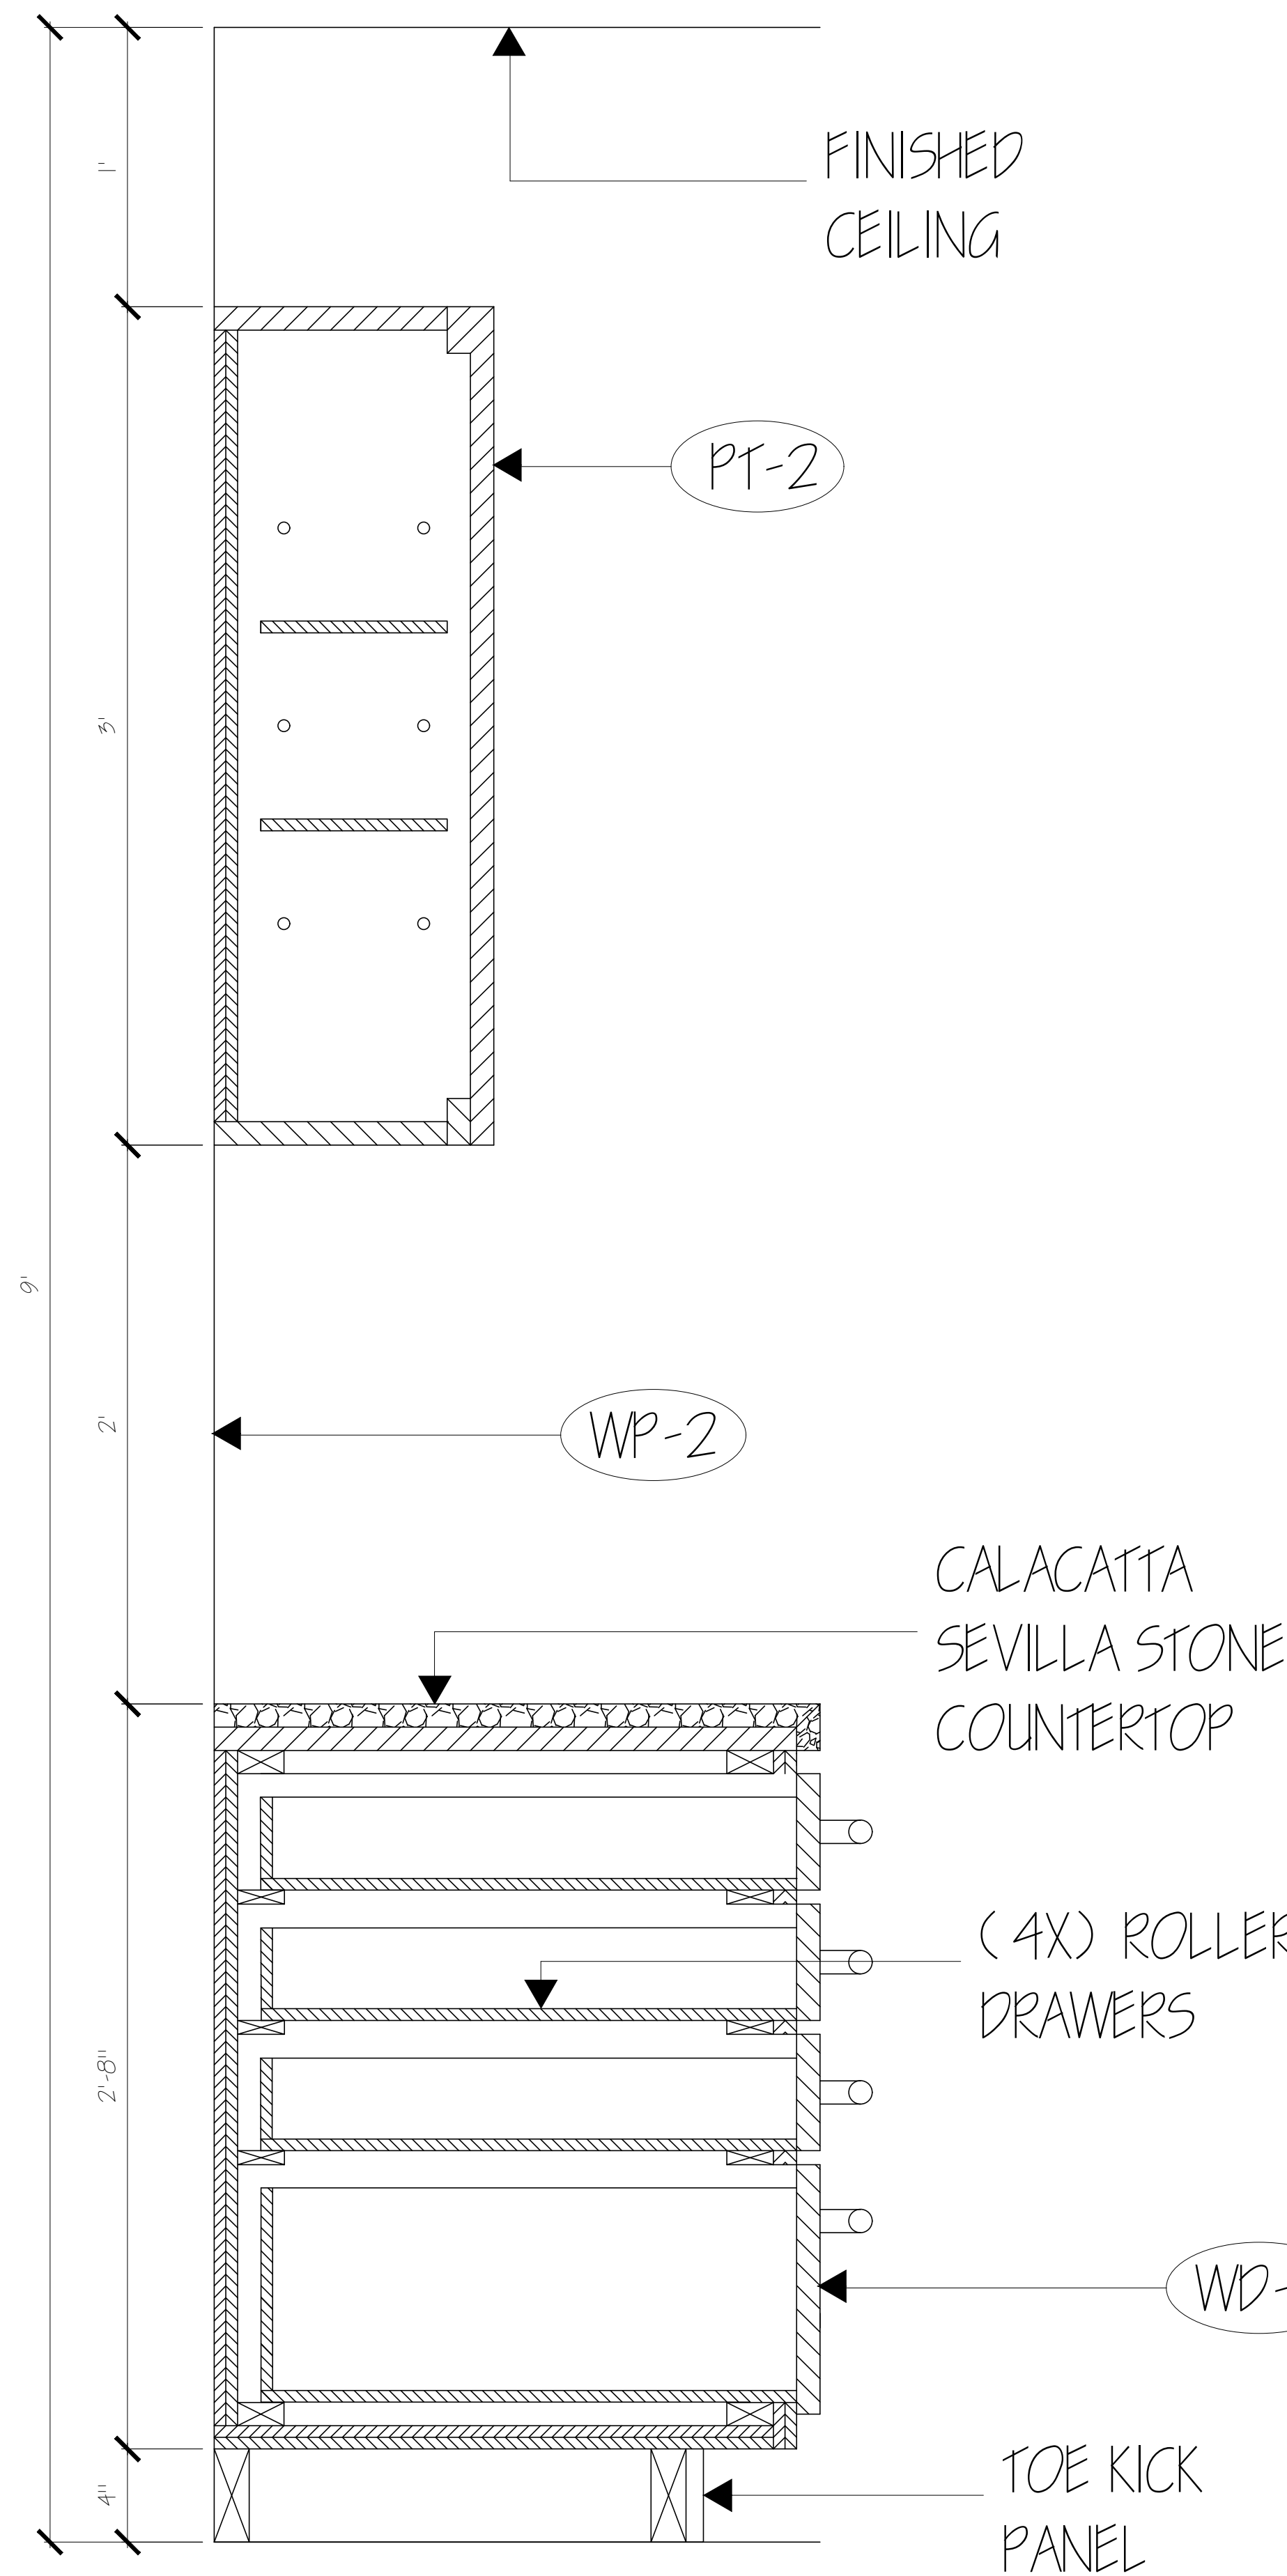

2 PANTRY CABINET SECTION
SCALE: $\frac{1}{2}" = 1'-0"$

GENERAL NOTES

- REFERENCE ELEVATION SHEETS ID-6.1 AND ID-6.3 FOR CABINET ELEVATION DETAILS
- REFER TO MATERIAL FINISH SCHEDULE ID-8.1 FOR DETAILS ON FINISHES.
- ALL WORK SHALL BE DONE IN ACCORDANCE WITH APPLICABLE CODES AND STANDARDS.



PROJECT:
RESIDENTIAL COURSE PROJECT
THE ESCOFFIER RESIDENCE

RESIDENTIAL DESIGN

INDS 2313

REVISIONS:

6		
5		
4		
3		
2		
1		

DATE: NOV 5TH, 2024

DRAFTED BY:

ALHAN VAZQUEZ

SHEET CONTENTS:

KITCHEN AND PANTRY
CABINET SECTIONS

SHEET:

ID-7.1



PROJECT:
RESIDENTIAL COURSE PROJECT
THE ESCOFFIER RESIDENCE

RESIDENTIAL DESIGN
INDS 2313


REVISIONS:		
6		
5		
4		
3		
2		
1		

DATE: NOV 5TH, 2024


DRAFTED BY:
ALHAN VAZQUEZ

SHEET CONTENTS:
BEDROOM SECTION
CUT DETAILS

SHEET:
ID-7.2

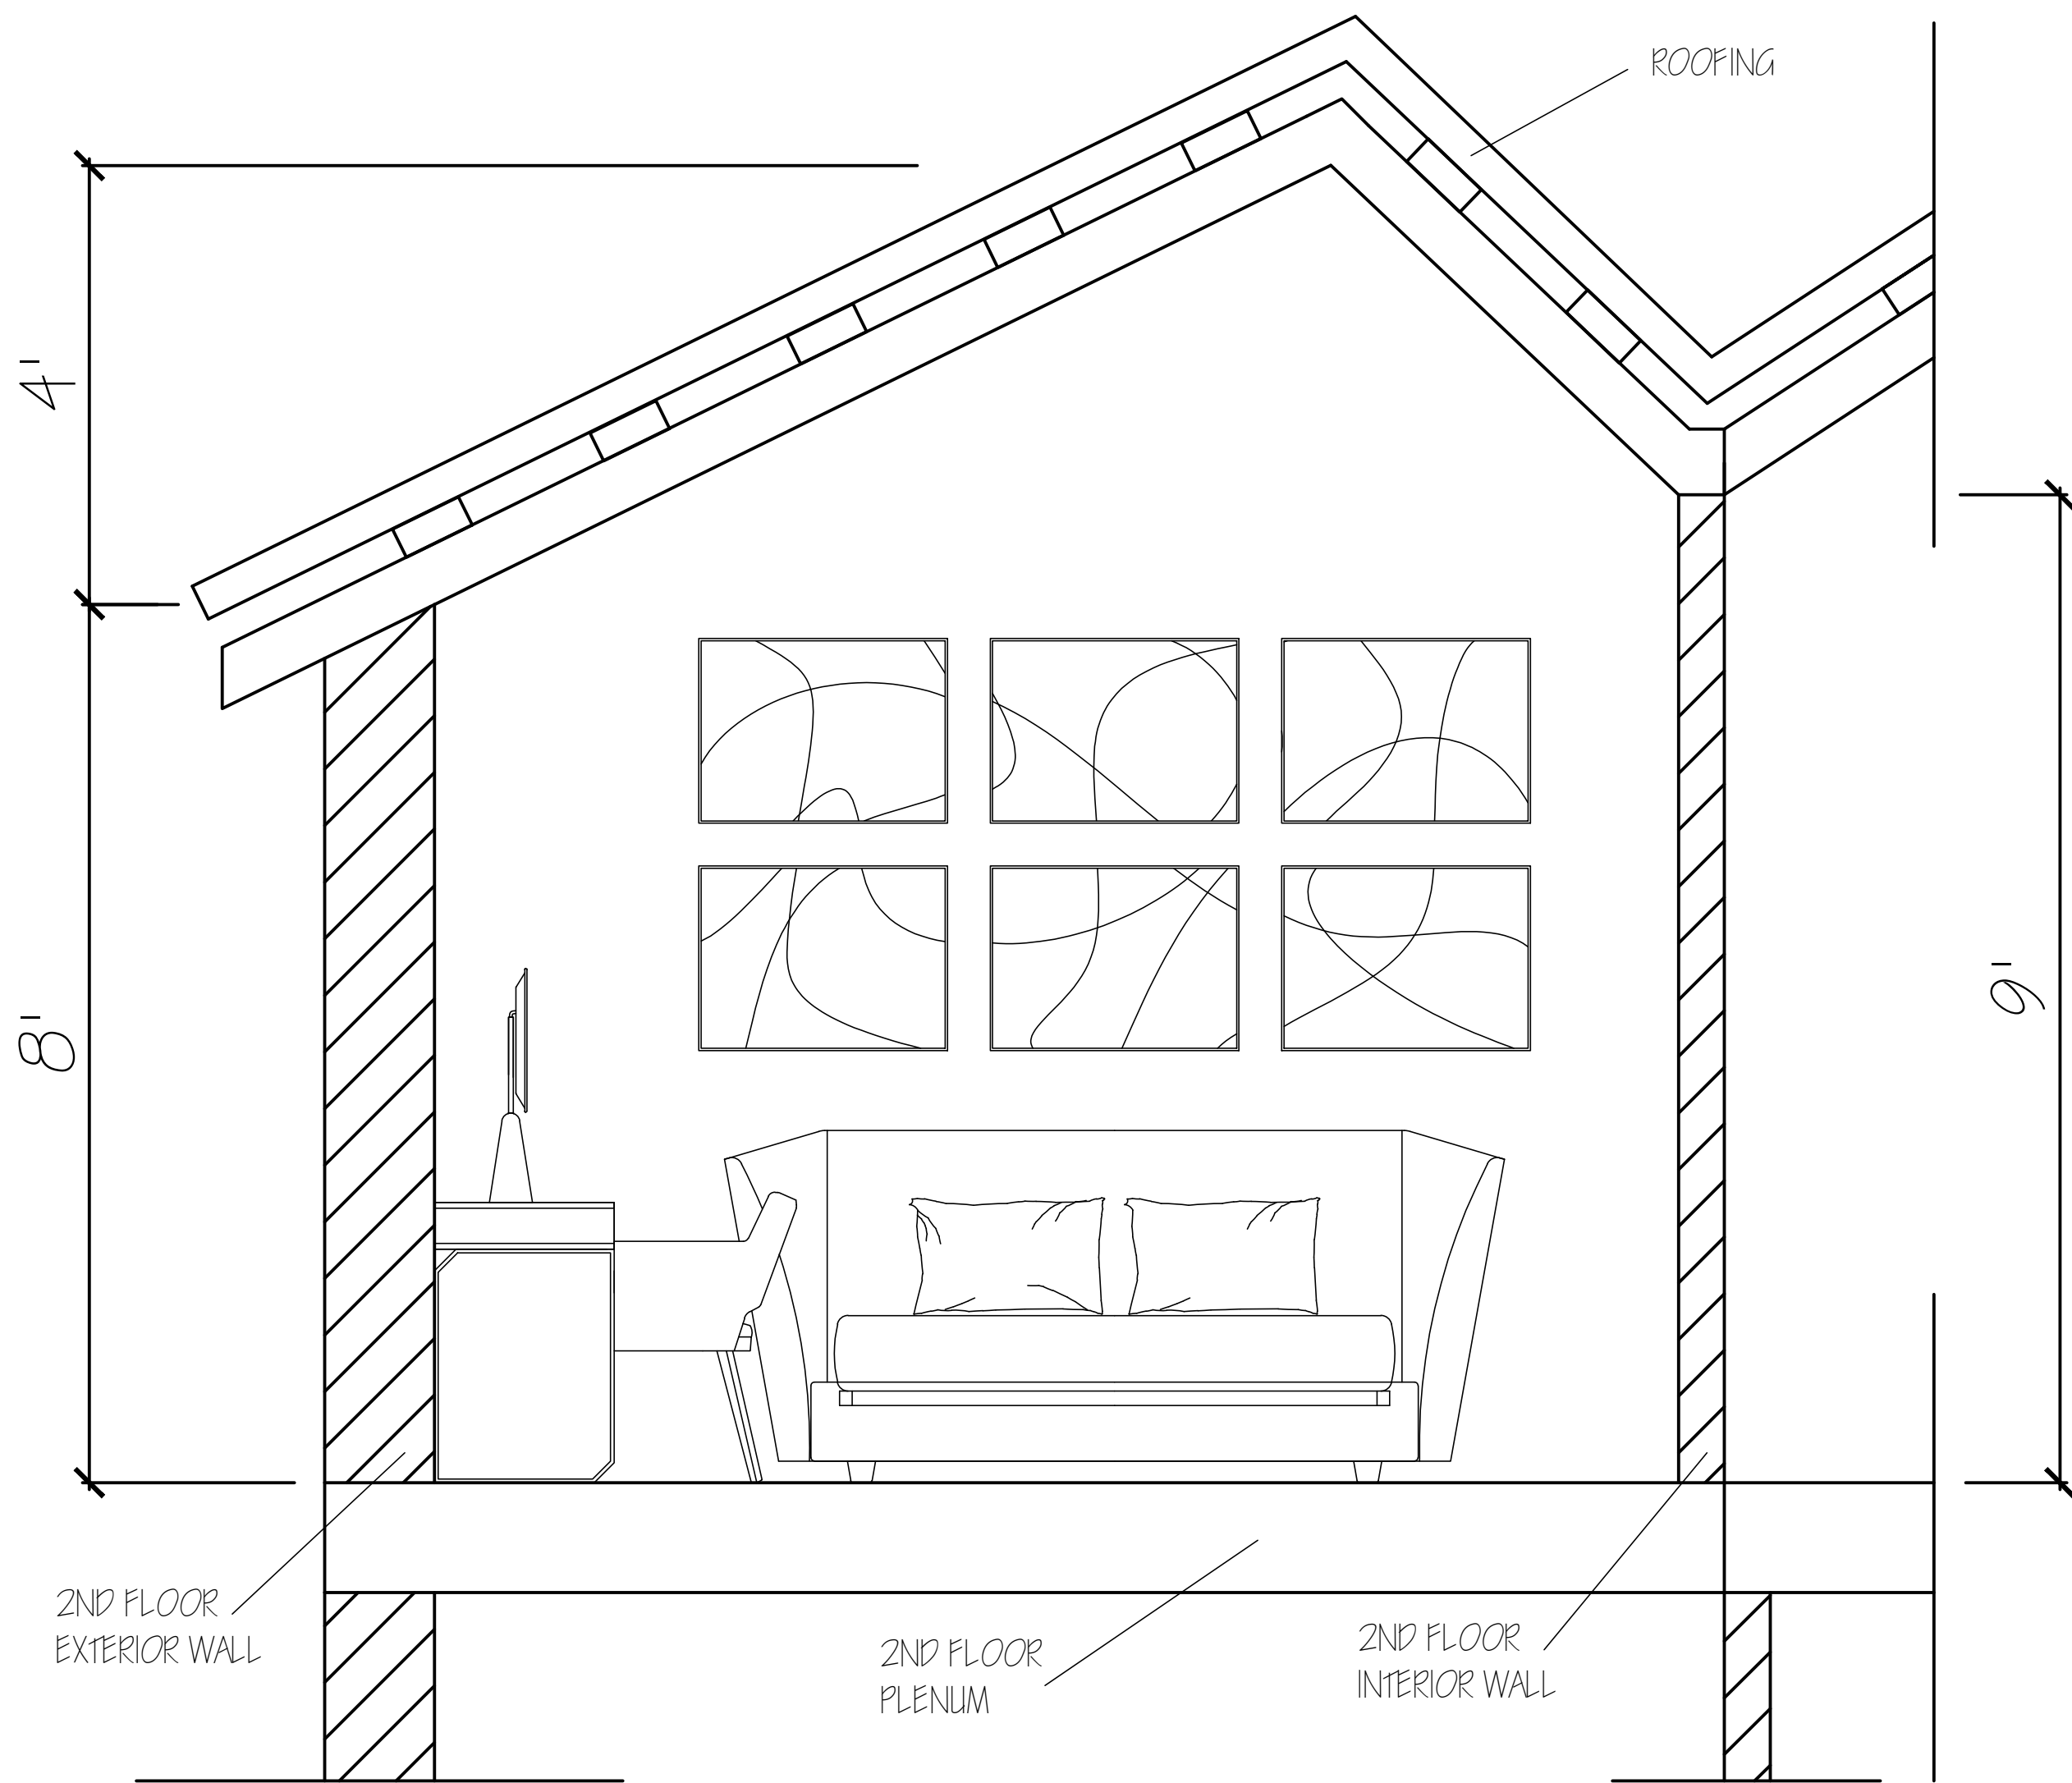


1 GUEST BEDROOM SECTION A-A CUT
SCALE: $\frac{1}{2}" = 1'-0"$

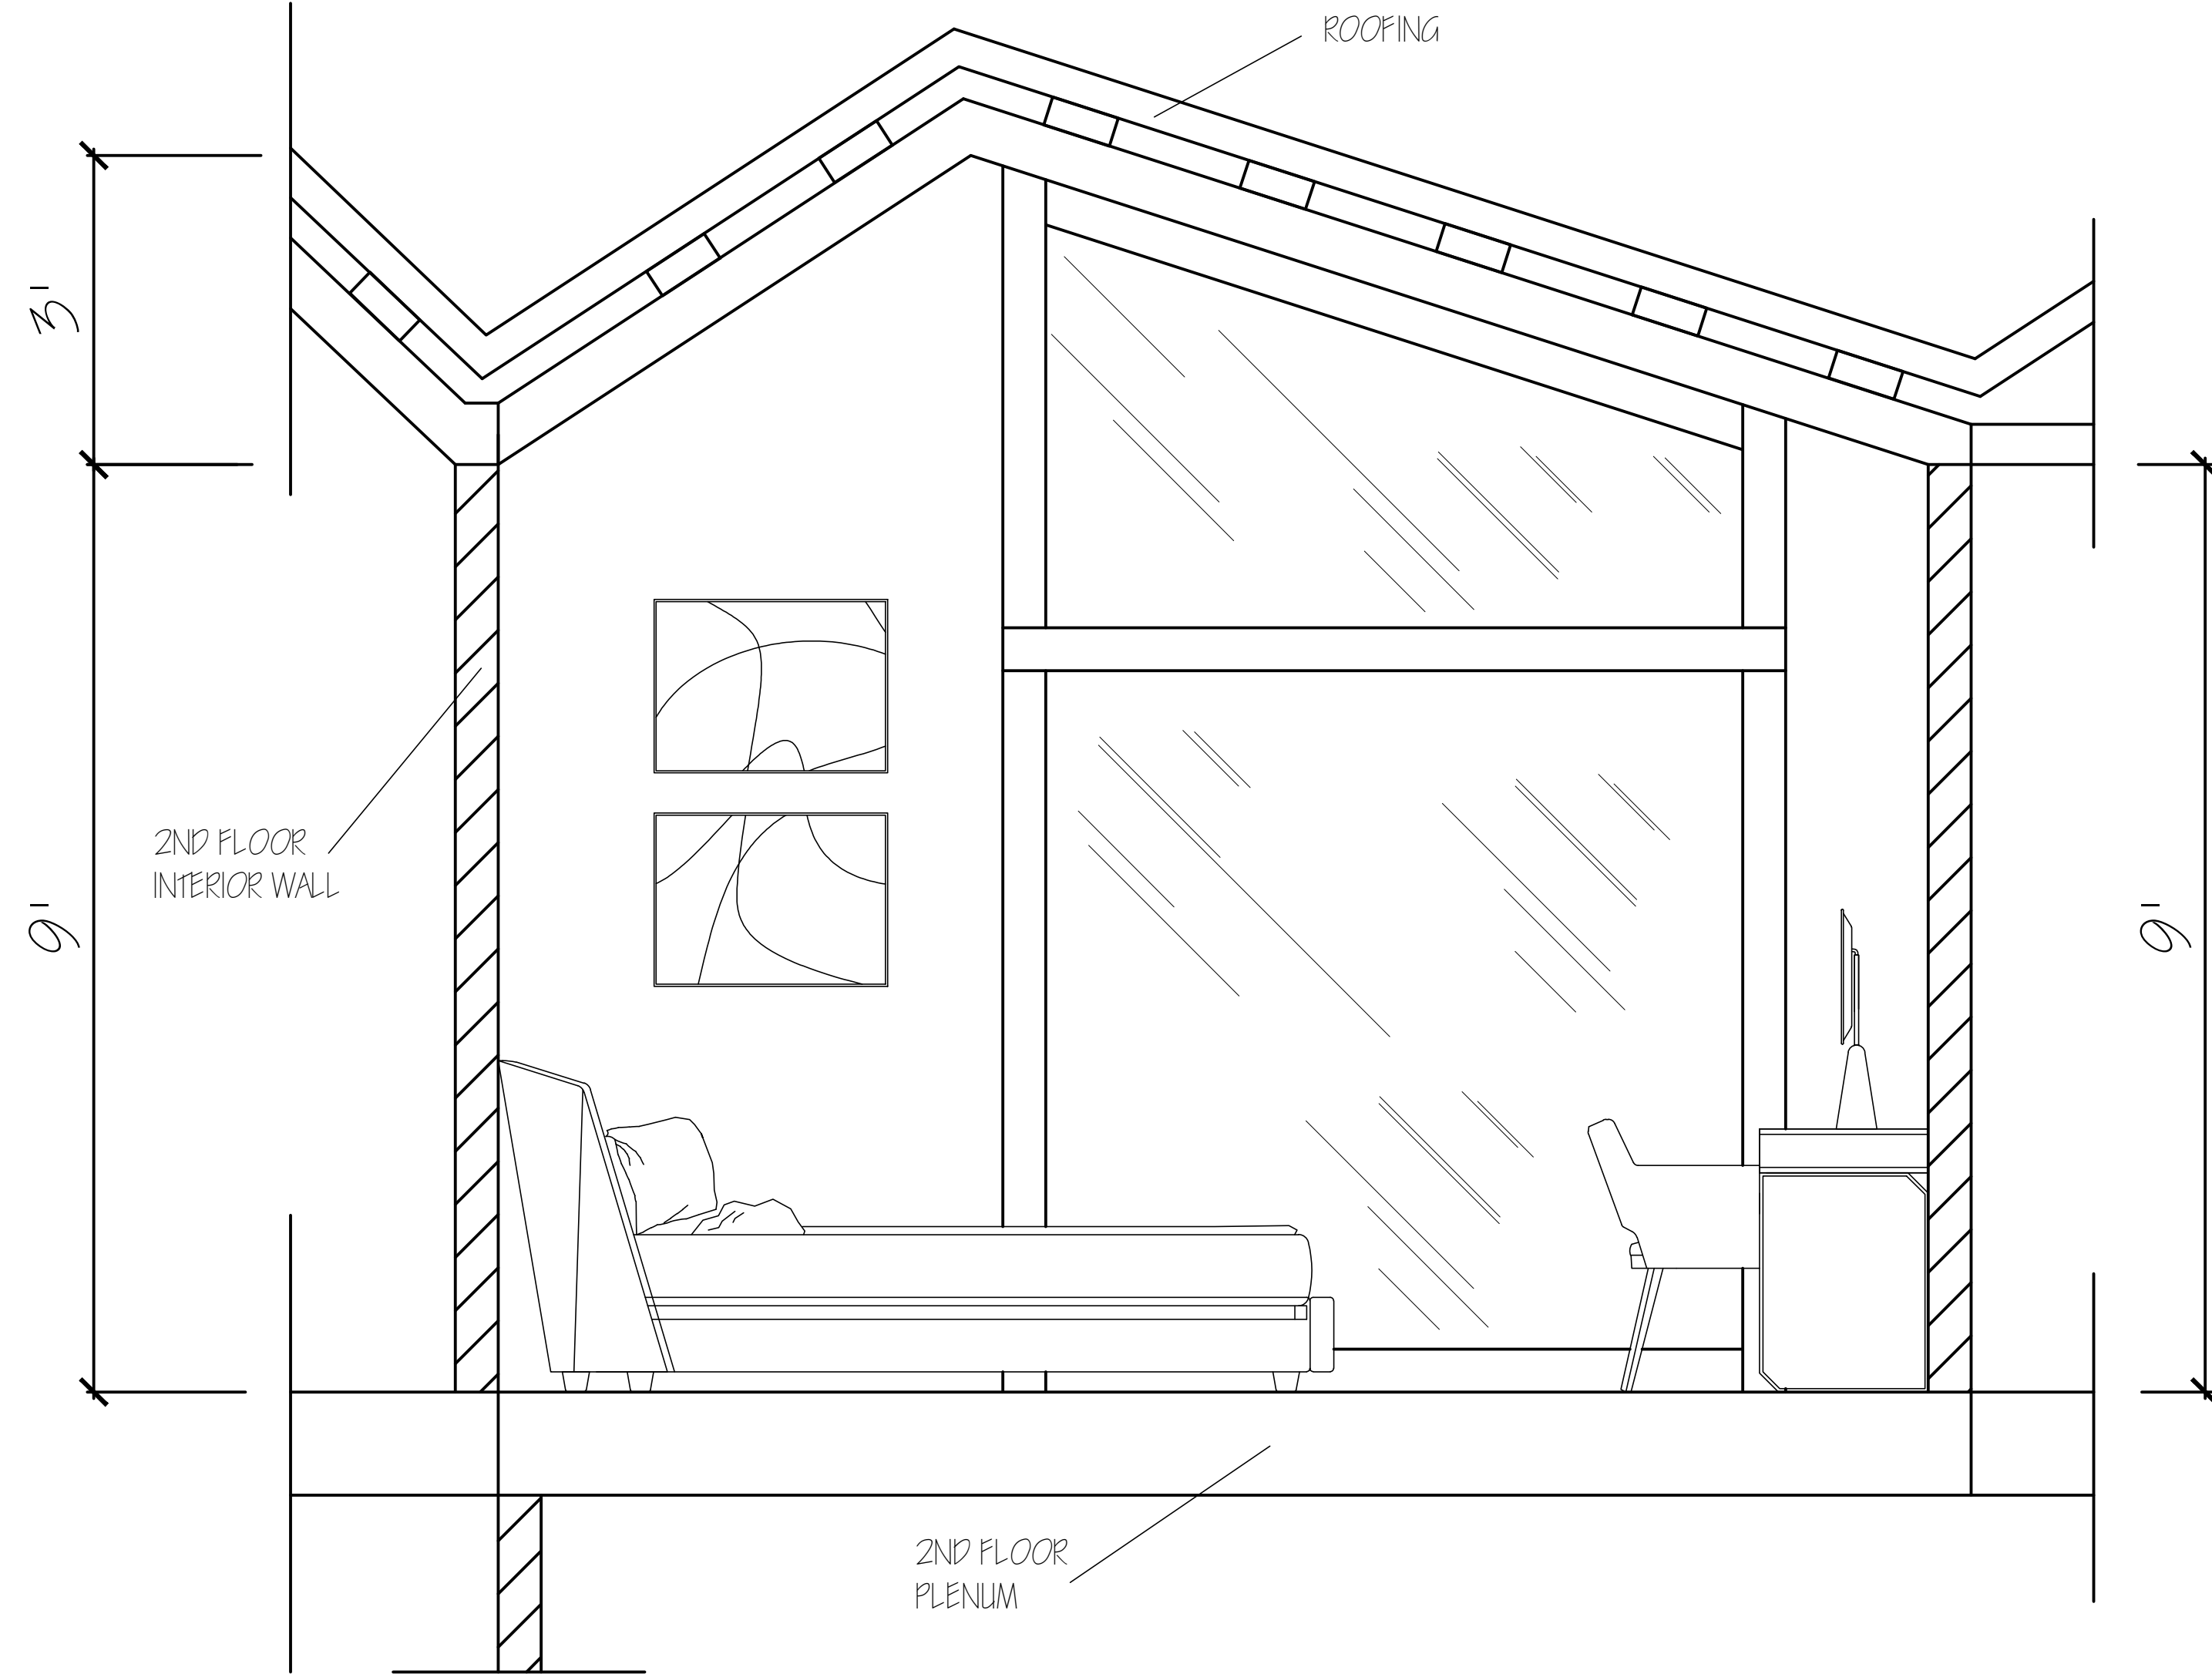

2 CHILDREN'S BEDROOM SECTION B-B CUT
SCALE: $\frac{1}{2}" = 1'-0"$


GENERAL NOTES

- REFERENCE 2ND FLOOR PARTITION PLAN ID-1.2 FOR SECTIONS A-A, B-B AND C-C CUT DETAILS.
- REFER TO MATERIAL FINISH SCHEDULE ID-B.1 FOR DETAILS ON FINISHES.
- ALL WORK SHALL BE DONE IN ACCORDANCE WITH APPLICABLE CODES AND STANDARDS.
- FOR FURTHER DETAILS ON BEDROOM HEIGHT SHIFTS REFER TO 2ND FLOOR RCP ID-10.2
- FOR REFERENCE ONLY, SHOWCASING THE CEILING DETAILS IN 2ND FLOOR BEDROOMS.
- WINDOW IN CHILDREN'S BEDROOM FROM FLOOR TO CEILING IN HEIGHT.

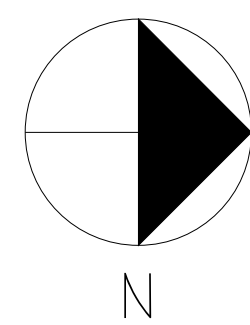


GENERAL NOTES

- REFER TO MATERIAL FINISH SCHEDULE ID-8.1 FOR DETAILS ON FINISHES.
- ALL WORK SHALL BE DONE IN ACCORDANCE WITH APPLICABLE CODES AND STANDARDS.

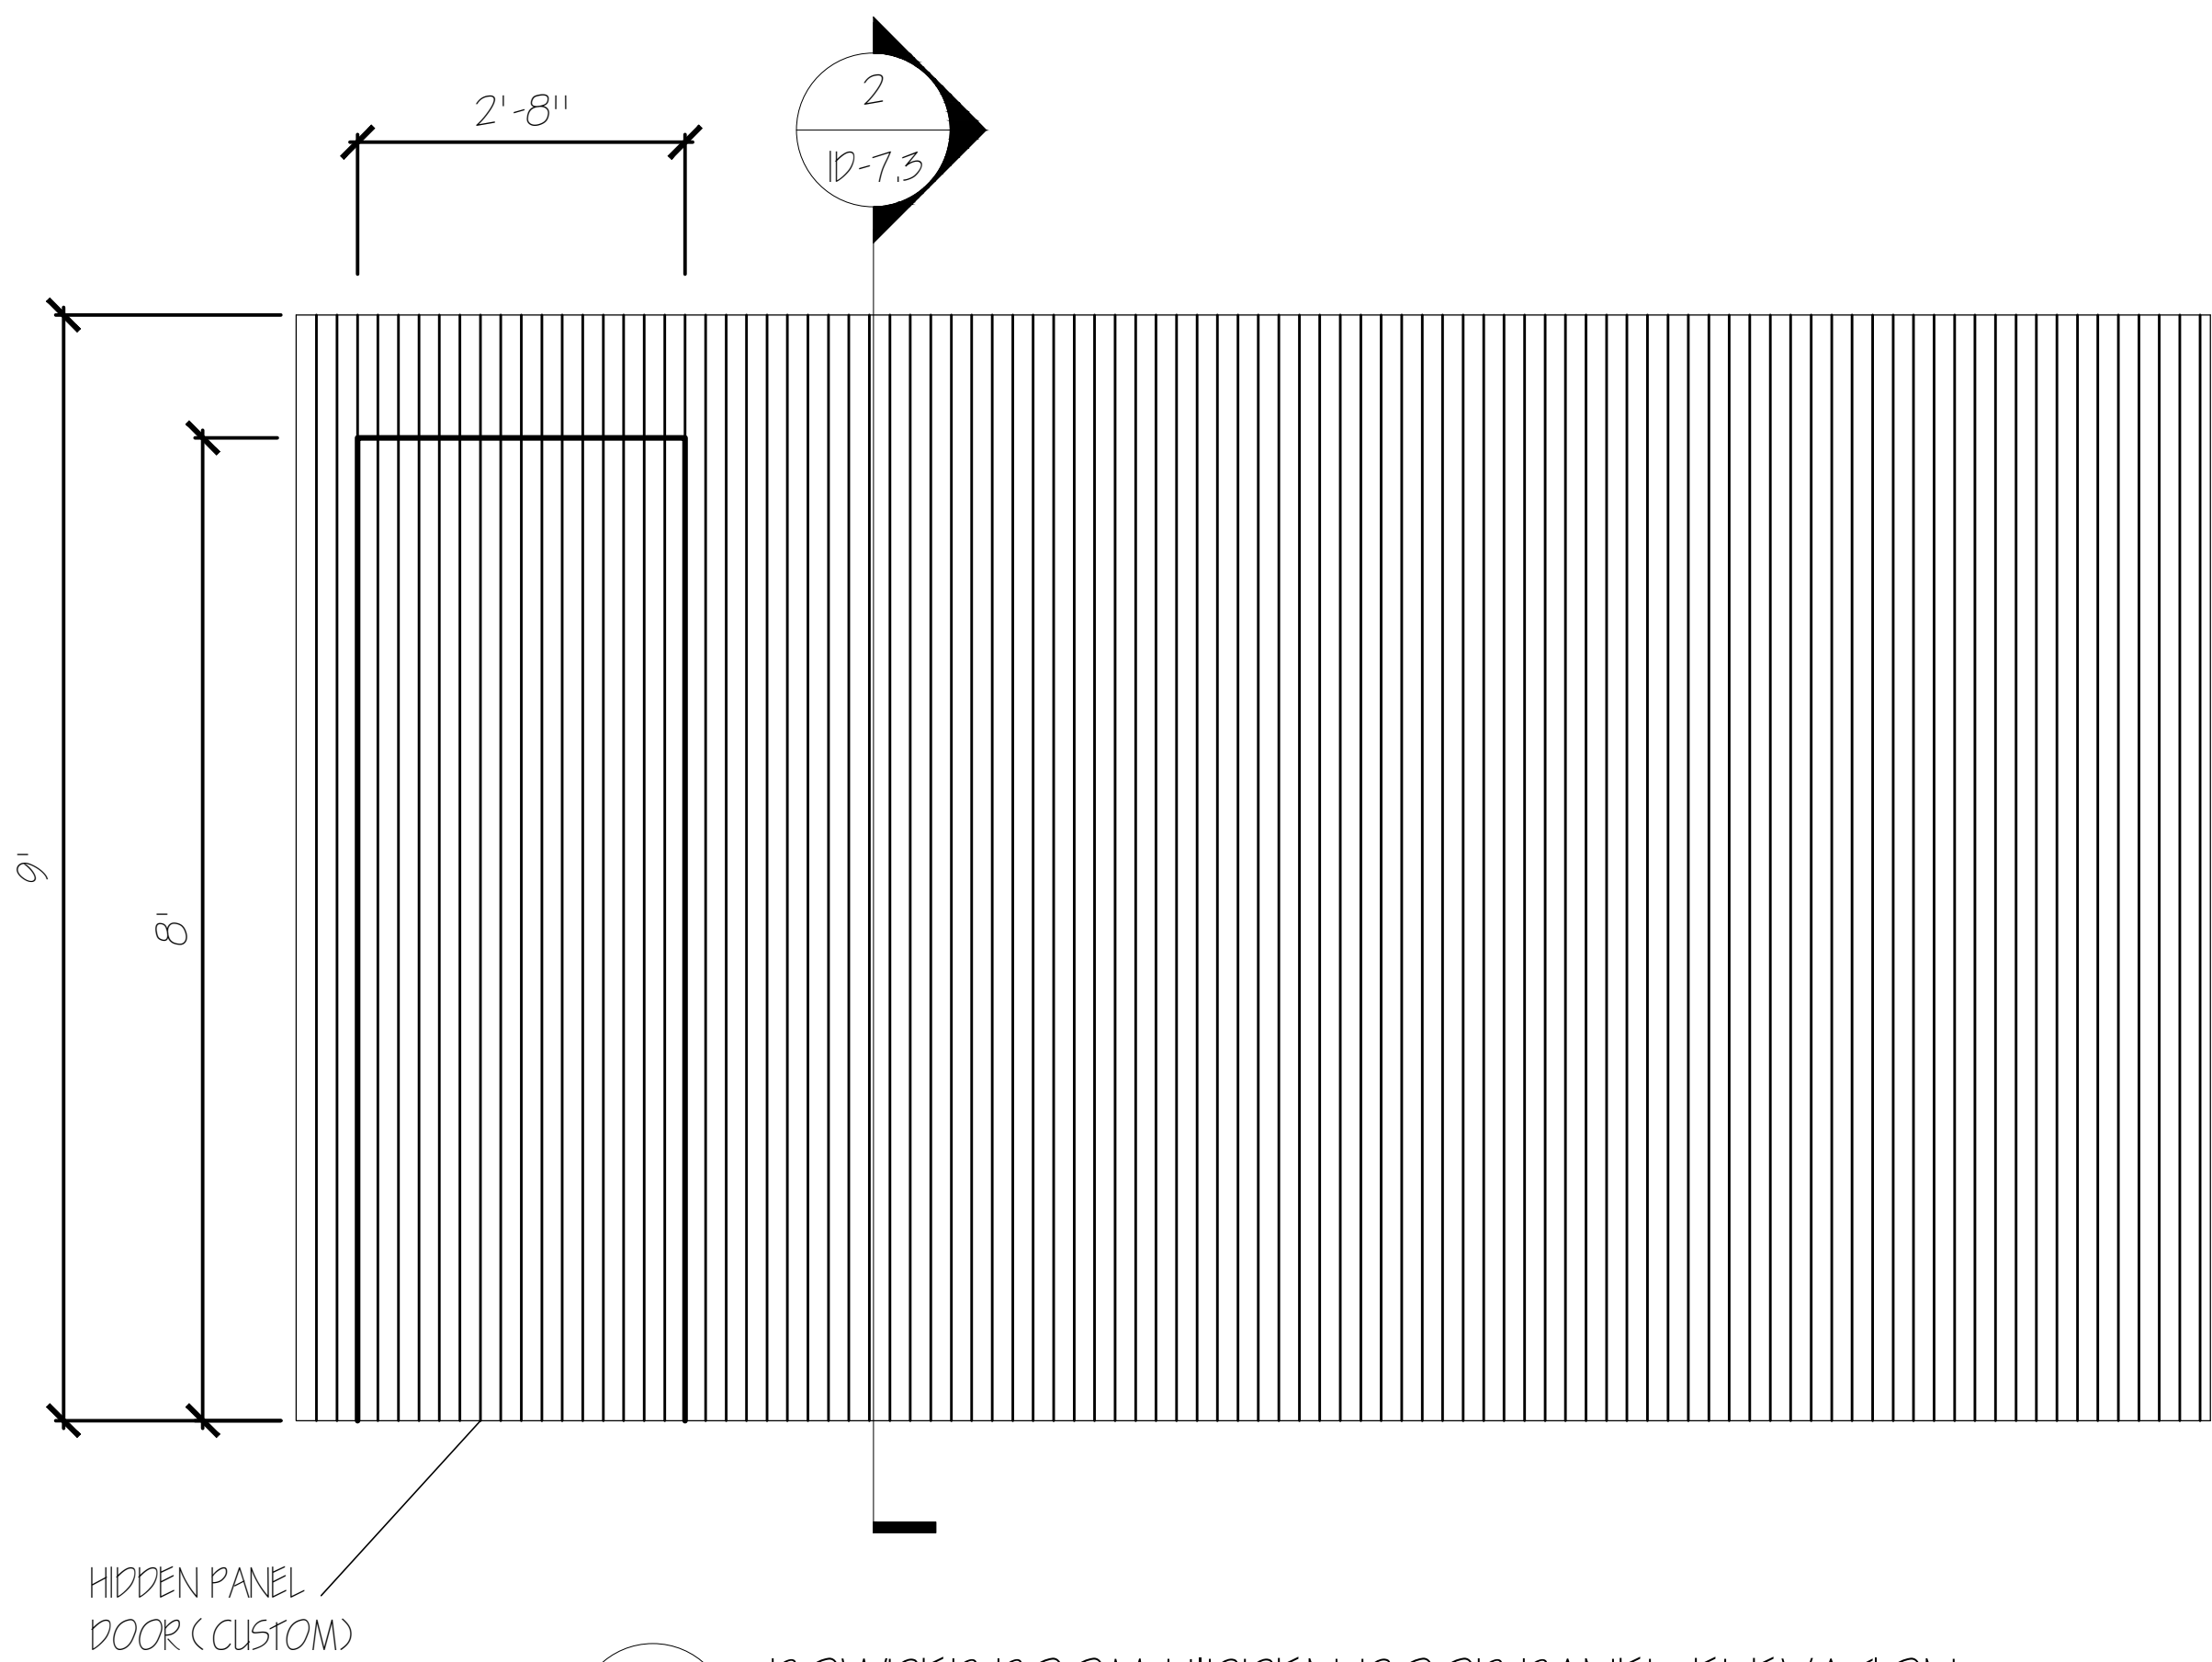

1 POWDER ROOM HIDDEN DOOR PANEL ELEVATION
SCALE: $\frac{1}{2}$ " = 1'-0"

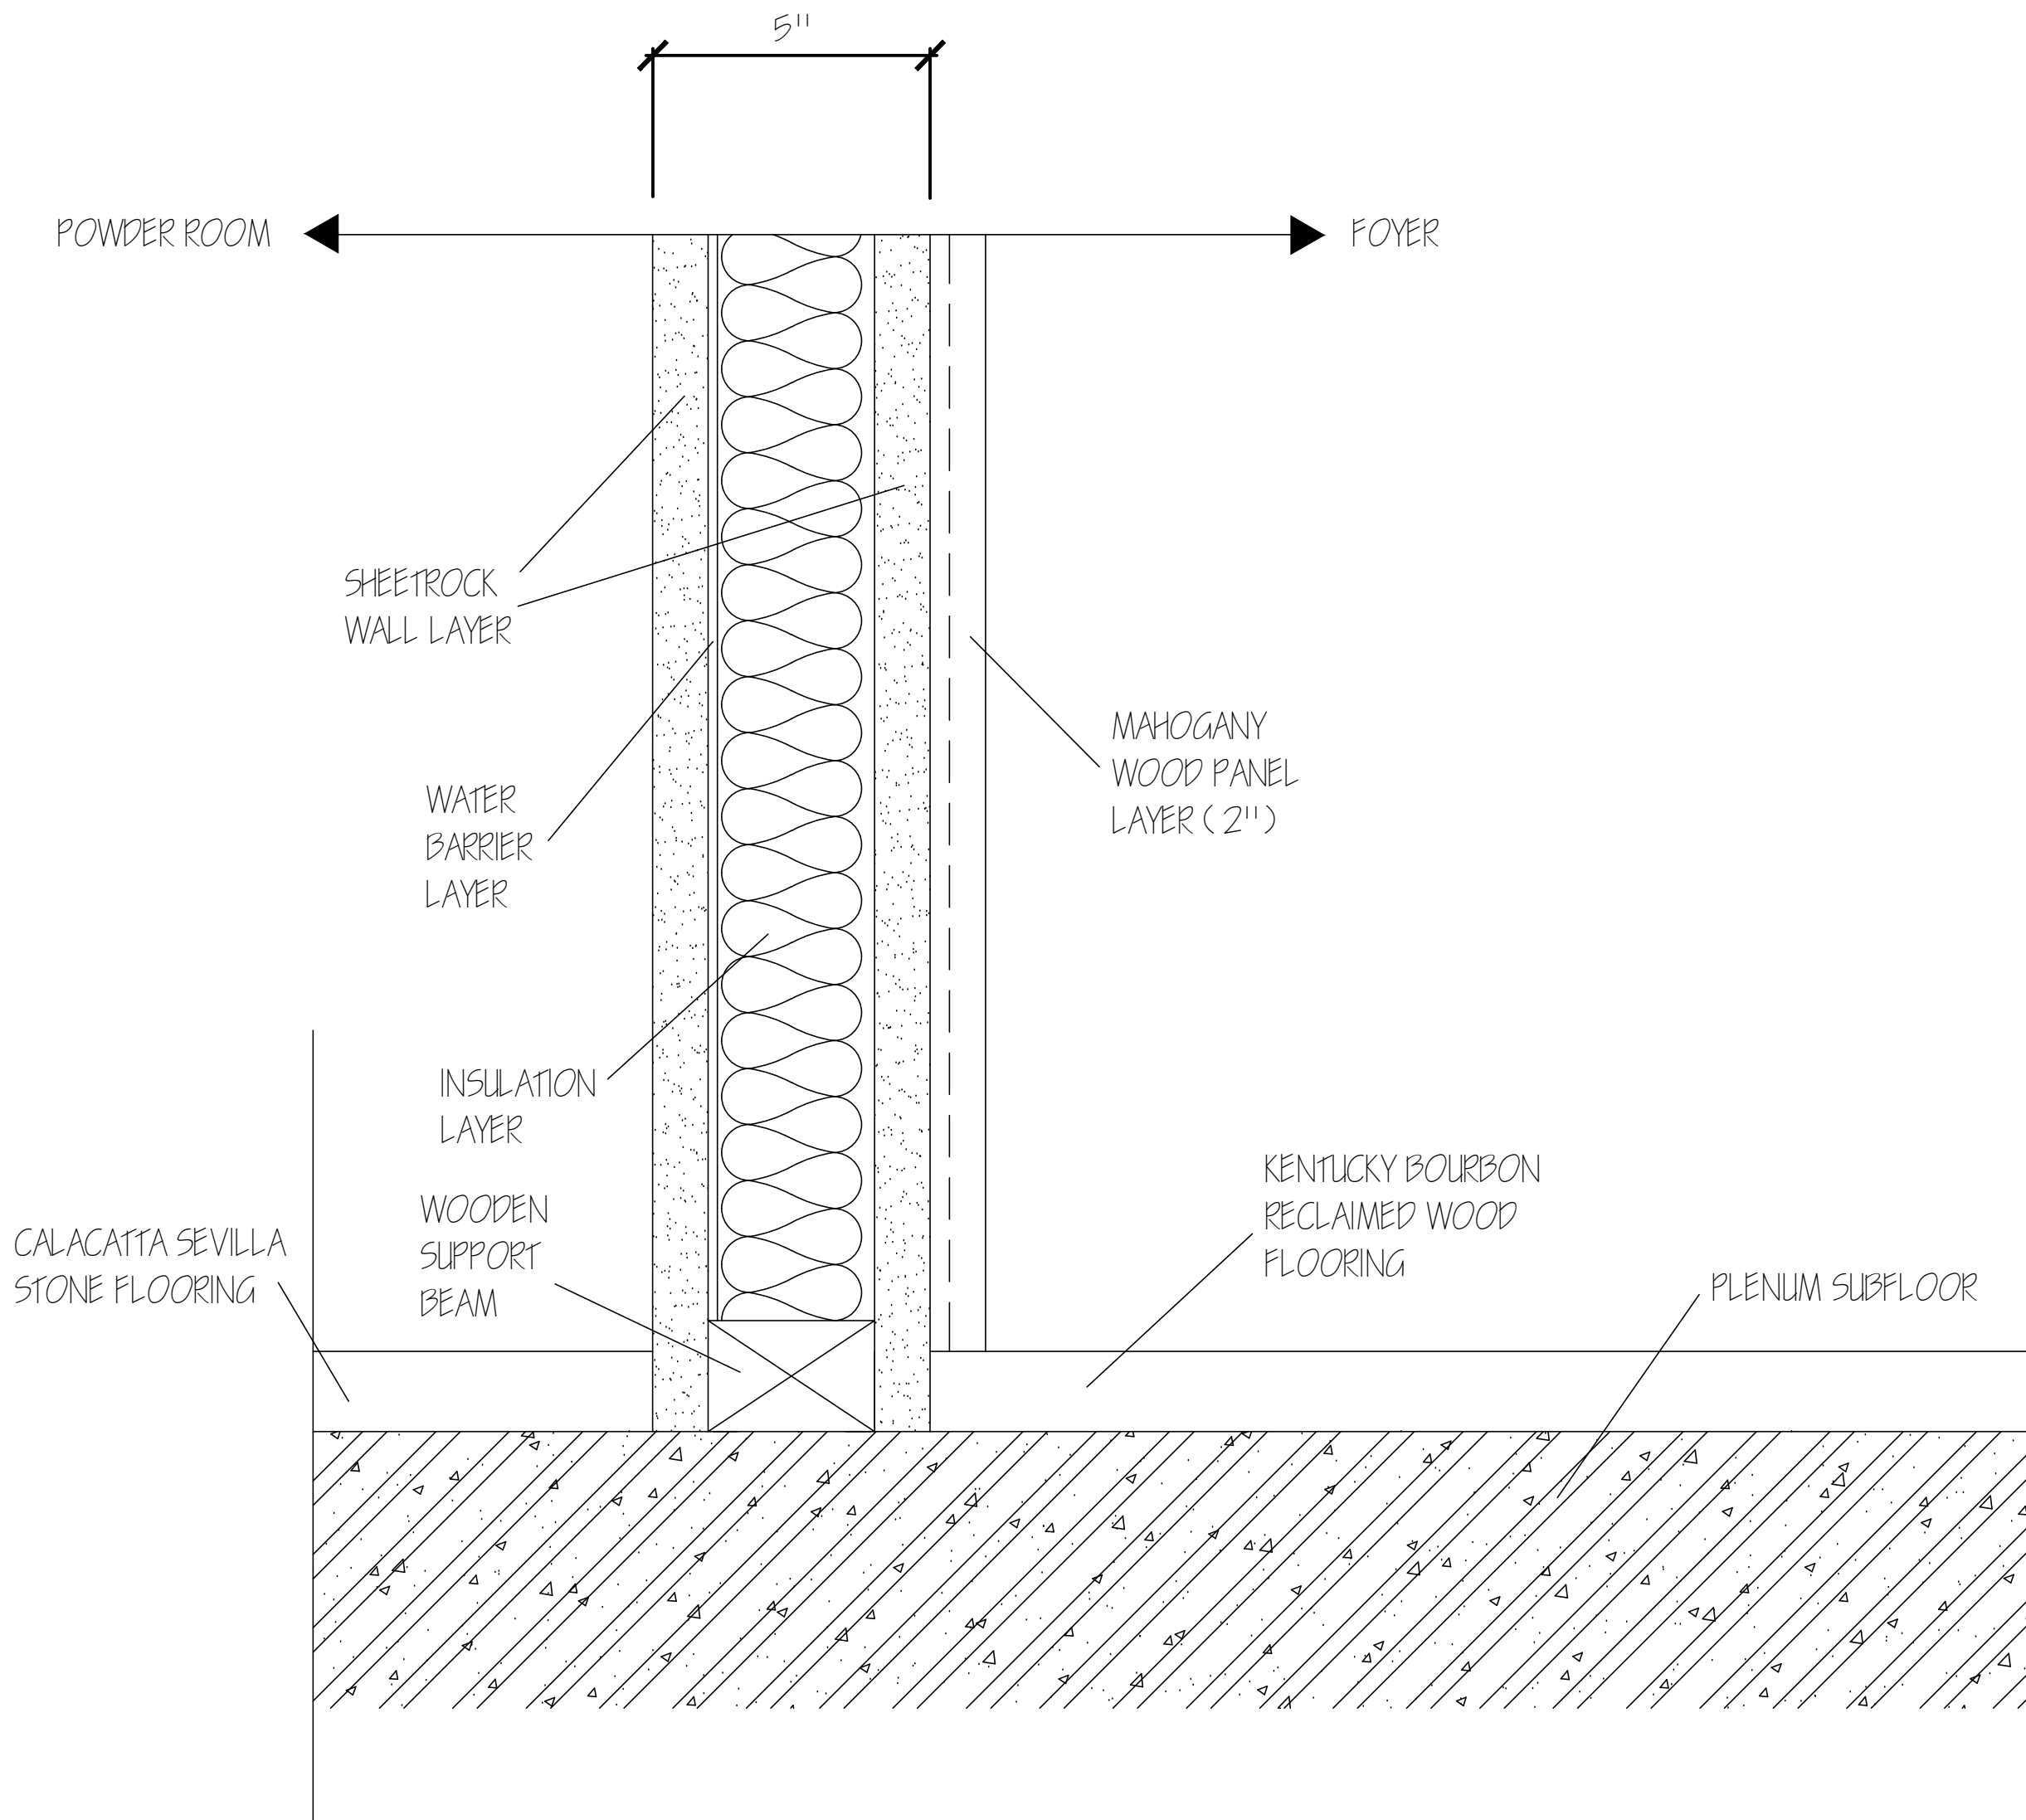

2 POWDER ROOM HIDDEN DOOR PANEL WALL SECTION
SCALE: $\frac{1}{2}$ " = 1'-0"



PROJECT:
RESIDENTIAL COURSE PROJECT
THE ESCOFFIER RESIDENCE

RESIDENTIAL DESIGN
INDS 2313

REVISIONS:

6		
5		
4		
3		
2		
1		

DATE: NOV 5TH, 2024

DRAFTED BY:
ALHAN VAZQUEZ

SHEET CONTENTS:
FURTHER SECTION
DETAILS

SHEET:
ID-7.3



PROJECT:
RESIDENTIAL COURSE PROJECT
THE ESCOFFIER RESIDENCE

RESIDENTIAL DESIGN
INDS 2313

REVISIONS:		
6		
5		
4		
3		
2		
1		

DATE: NOV 5TH, 2024

DRAFTED BY:


ALHAN VAZQUEZ

SHEET CONTENTS:

CHILDREN'S BEDROOM
SECTION CUT DETAILS

SHEET:


ID-7.4

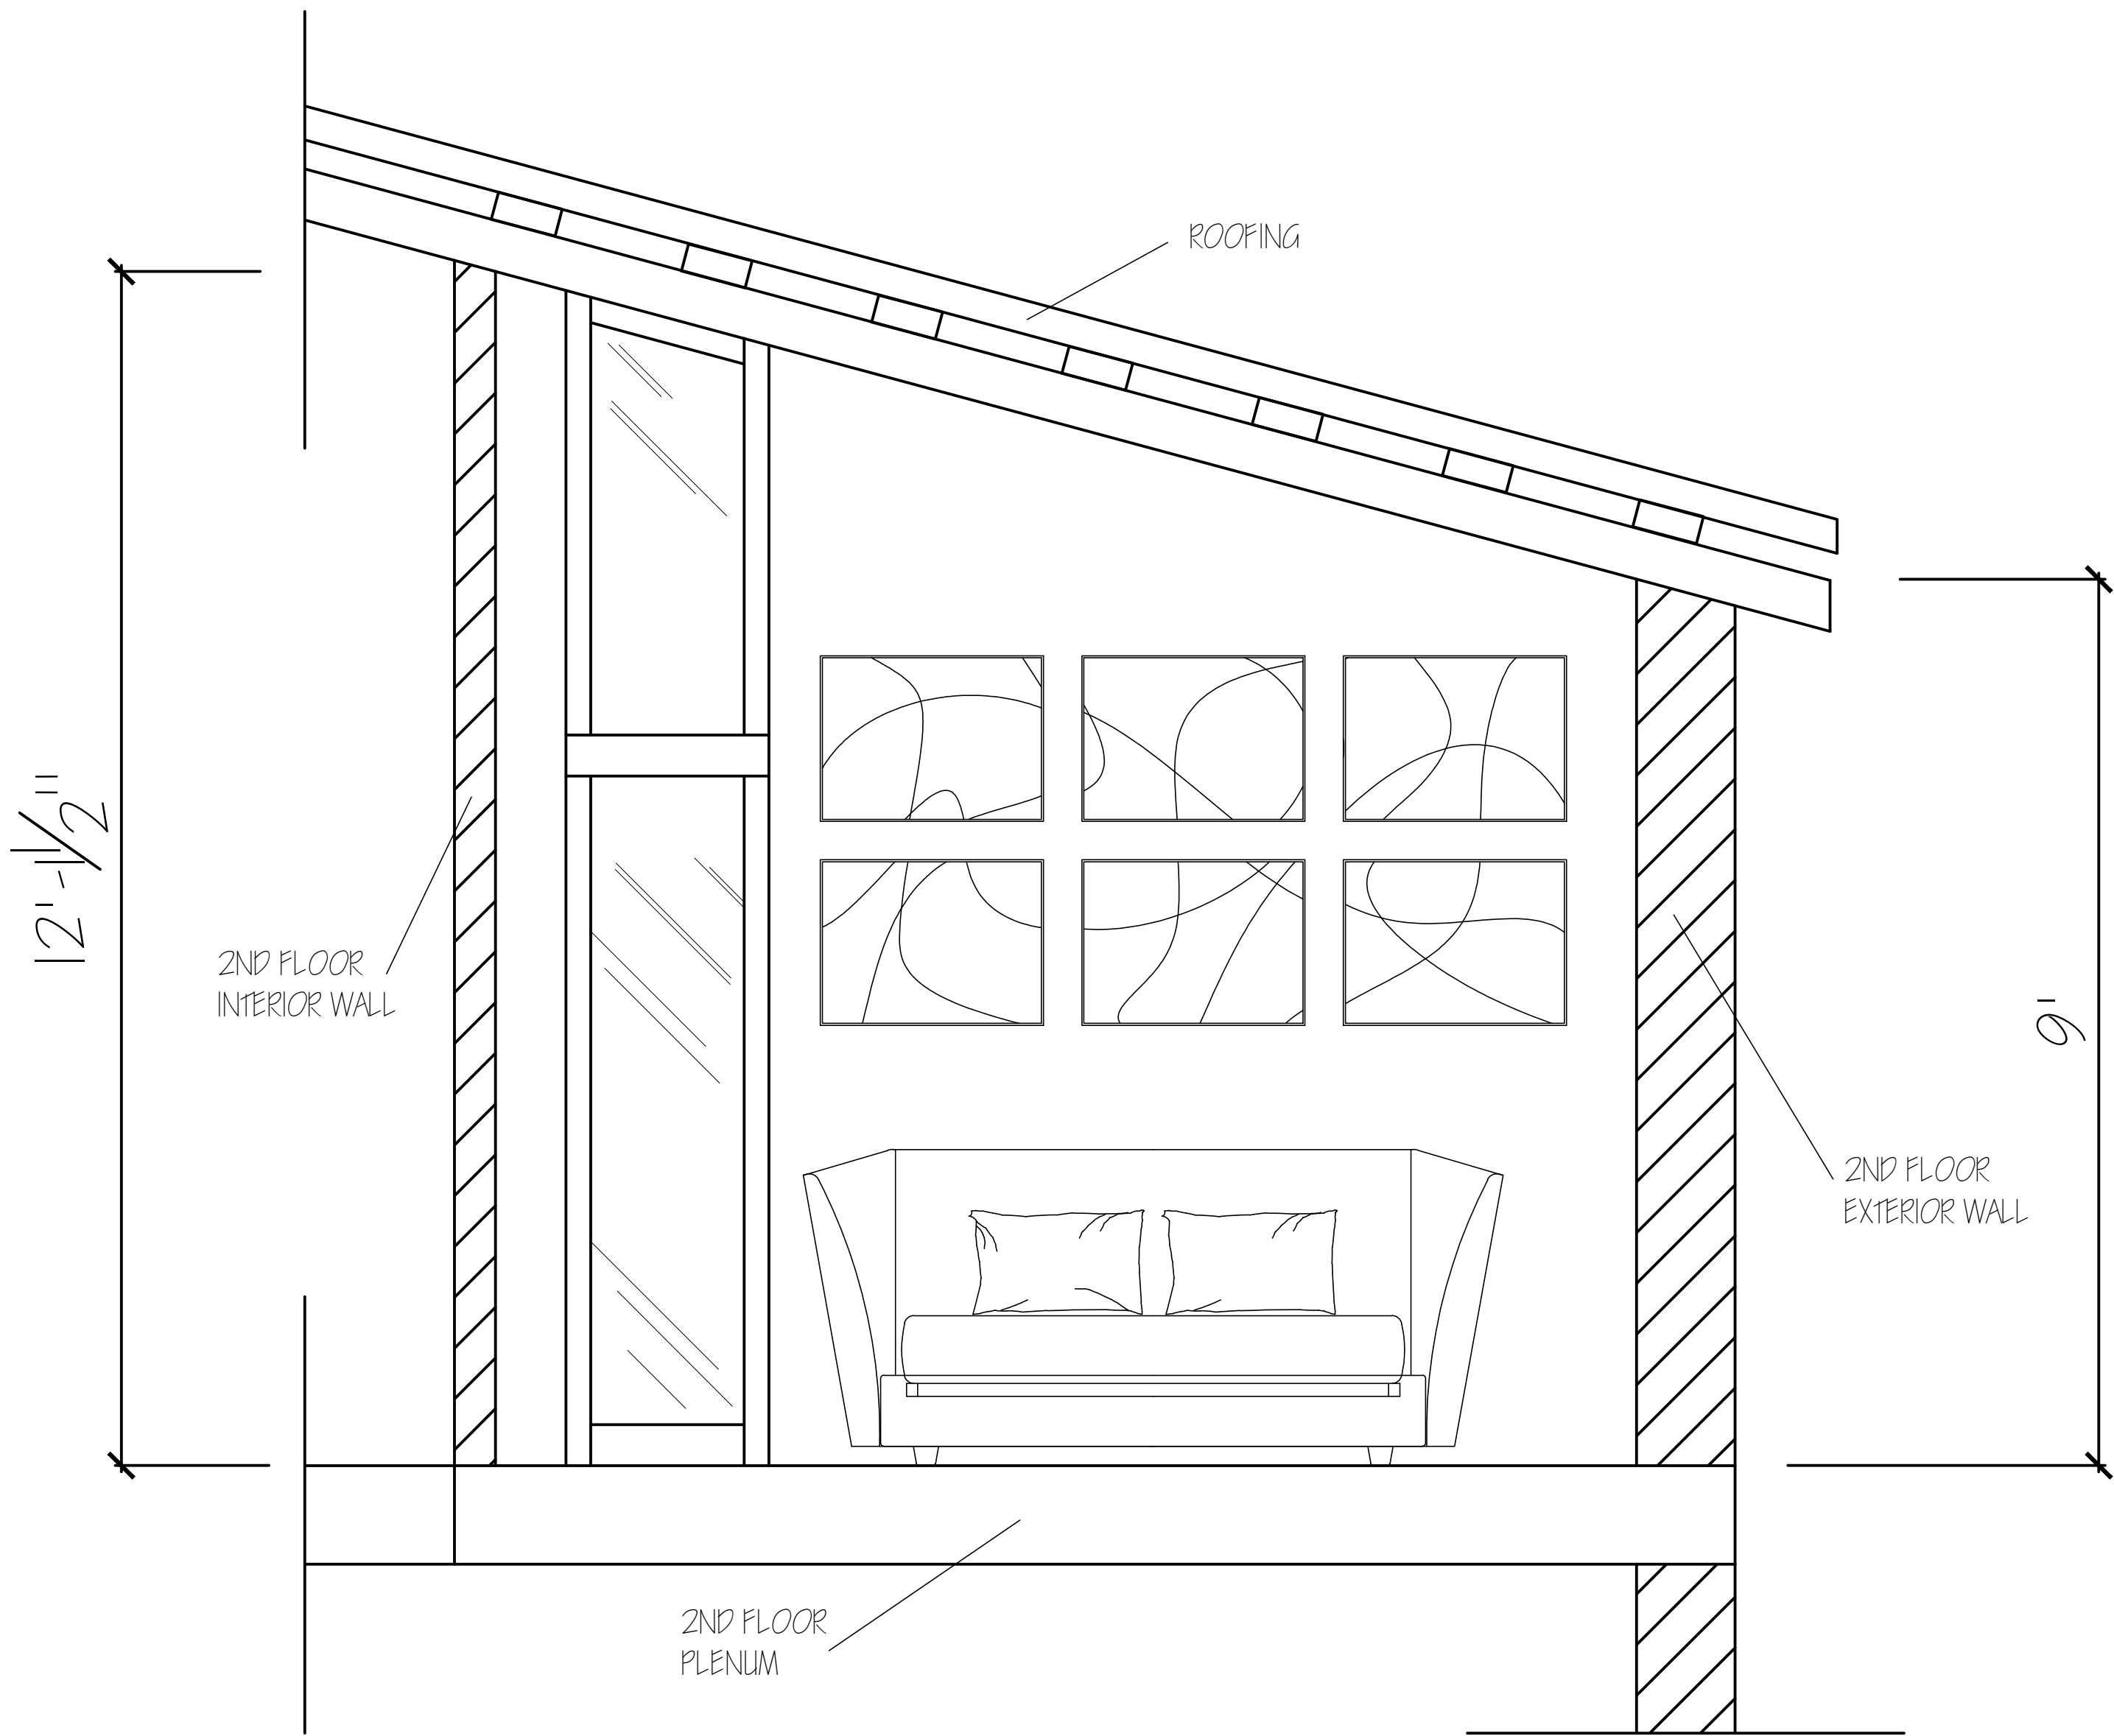

1 CHILDREN'S BEDROOM SECTION C-C CUT
SCALE: 1/2" = 1'-0"

GENERAL NOTES

- REFERENCE 2ND FLOOR PARTITION PLAN ID-1.2 FOR SECTIONS A-A, B-B AND C-C CUT DETAILS.
- REFER TO MATERIAL FINISH SCHEDULE ID-B.1 FOR DETAILS ON FINISHES.
- ALL WORK SHALL BE DONE IN ACCORDANCE WITH APPLICABLE CODES AND STANDARDS.
- FOR FURTHER DETAILS ON BEDROOM HEIGHT SHIFTS REFER TO 2ND FLOOR RCP ID-10.2
- FOR REFERENCE ONLY, SHOWCASING THE CEILING DETAILS IN 2ND FLOOR BEDROOMS.
- WINDOW IN CHILDREN'S BEDROOM FROM FLOOR TO CEILING IN HEIGHT.

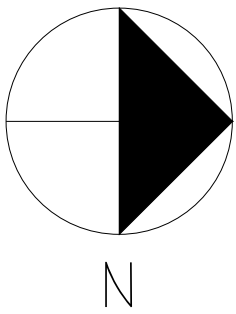



PROJECT:
RESIDENTIAL COURSE PROJECT
THE ESCOFFIER RESIDENCE

RESIDENTIAL DESIGN
INDS 2313

REVISIONS:		
6		
5		
4		
3		
2		
1		

DATE: NOV 5TH, 2024

DRAFTED BY:

ALHAN VAZQUEZ

SHEET CONTENTS:

MATERIAL FINISH
SCHEDULE

SHEET:

ID-8.1

MATERIAL FINISH SCHEDULE					
KEY	MATERIAL	MANUFACTURER	NUMBER/ COLOR	SIZE	REMARKS
WF-1	VENETIAN PLASTER FINISH COVERING	COSIO	COS 5844, STONE	54" WIDTH	REVERSE HANG, RANDOM MATCH
WF-2	MAHOGANY WOOD PANEL	VENO	MAHOGANY, REAL WOOD PANEL	94" X 24" X 1"	BLACK MDF AND FELT BACKING
PT-1	PAIN T	SHERWIN WILLIAMS	SW 7757 HIGH REFLECTIVE WHITE		1 PRIMER COAT, 2 FINISH COATS
PT-2	PAIN T	SHERWIN WILLIAMS	EGGSHELL		1 PRIMER COAT, 2 FINISH COATS
PT-3	PAIN T	SHERWIN WILLIAMS	SW 6965 HYPER BLUE, EGGSHELL		1 PRIMER COAT, 2 FINISH COATS
			SW 6793 BLUEBELL, EGGSHELL		1 PRIMER COAT, 2 FINISH COATS
WP-1	PATTERNED WALL PAPER	MAHONE'S INTERIOR DESIGN	CHESAPEAKE ANTLER DAMASK NAVY	20.5" WIDTH	56.4 SQ. FT. ROLL
WP-2	PATTERNED WALL PAPER	WALLPAPER BOULEVARD	MARE NAVY WAVE	20.5" WIDTH	STRAIGHT, NON-WOVEN
WP-3	PATTERNED WALL PAPER	REBEL WALLS	BIRCH TREES R19070	19.7" WIDTH	MATTE FINISH
WP-4	PATTERNED WALL PAPER	MAHONE'S INTERIOR DESIGN	PEACOCK NAVY YORK	25.25" REPEAT	60.74 SQ. FT. ROLL
ST-1	STONE FLOORING	LA FABBRICA	ONICLE IRIDE COBALTO STONE	63" X 123"	LATERAL REPEATS
ST-2	STONE (COUNTERS AND FLOORING)	G STONE	CALACATTA SEVILLA STONE		IMPORT SLABS
ST-3	STONE FLOORING	LA FABBRICA	NAUTILUS STONE	63" X 123"	LATERAL REPEATS
CT-1	CERAMIC TILE (FLOORING)	FLOOR & DECOR	STRATFORD PORCELAIN TILE	8" X 8"	$\frac{1}{8}$ " GROUT JOINTS
CT-2	CERAMIC TILE (BACKSPLASH)	TILEBAR	HEX ART DECO AZUL HEXAGON	8" HEXAGON	MATTE TILE
GR-1	GROUT	TEXRITE	#013 SILVER GRAY	$\frac{1}{8}$ " GROUT JOINTS	EPOXY
WD-1	RECLAIMED WOOD FLOORING	REC WOOD	KENTUCKY BOURBON RECLAIMED WOOD PANELS	20 SQ FT.	NATURALLY WORN FINISH
WD-2	LIVE EDGE WOOD COUNTERS	LITTLE BRANCH FARM	LIVE EDGE WOOD COUNTERS		NATURAL WOOD
WD-3	WALNUT WOOD	FLOOR & DECOR	ROYAL WALNUT WOOD		POLISHED FINISH
WD-4	SIERRA SANDS WOOD FLOORING	TILES OF EUROPE	SIERRA SANDS SKU: WM1120	24 SQ FT.	WOOD EMBOSS
WD-5	PINE BOARD CABINET DOORS	MOD CABINETRY	RUSTIC PINE BOARD	CUSTOM	CUSTOM CABINETS



PROJECT:
RESIDENTIAL COURSE PROJECT
THE ESCOFFIER RESIDENCE

RESIDENTIAL DESIGN
INDS 2313

REVISIONS:		
6		
5		
4		
3		
2		
1		

DATE: NOV 5TH, 2024

DRAFTED BY:

ALHAN VAZQUEZ


SHEET CONTENTS:

FURNITURE SCHEDULE

SHEET:

ID-9.1

FURNITURE SCHEDULE						
KEY	ITEM	QUANTITY	SIZE	MANUFACTURER	LOCATION	SPECIFICATION
1	VAIL BAR STOOL	4	33.5" H x 22" W x 18.5" L	DENVER MODERN	KITCHEN	100% SADDLE LEATHER, BLACK POWDER-COATED STEEL FRAME
2	CAMILLA FARMHOUSE CUSTOM RUNNER RUG	2	27" W x 8'-0" L	WELL WOVEN	KITCHEN	MEDALLION DENIM BLUE YARN RUG
3	CAMILLA FARMHOUSE CUSTOM RUNNER RUG	1	27" W x 12'0" L	WELL WOVEN	KITCHEN	MEDALLION DENIM BLUE YARN RUG
4	ANTELOPE CANYON SECTIONAL	1	29.1" H x 187" W x 104" L	ALMA DE LUCE	LIVING ROOM	NATURE COLLECTION, KRAVET QUEEN'S VELVET SAPPHIRE FABRIC, AMERICAN WALNUT
5	DYAG EAST COFFEE TABLE	1	17.3" H x 39.4" W x 39.4" L	PERIGOLD	LIVING ROOM	BROWN SOLID NATURAL WOOD FREE FORM
6	ARHAUS HAIR ON HIDE RUG	1	0.5" H x 84" W x 78" L	ARHAUS	LIVING ROOM	BROWN AND WHITE HAIR ON HIDE LEATHER BACKING
7	LIVE EDGE MAPLE DINING TABLE	1	44" W x 90" L	PATHWAY TABLES	DINING ROOM	MAPLE LACQUER FINISH, SEMI-GLOSS
8	BLUE LEATHER SIDE CHAIR	6	45" H x 21" W x 22" L	RUNYON'S	DINING ROOM	TUFTED SAPPHIRE WESTERN BLUE LEATHER
9	COSMO ABSTRACT AREA RUG	1	10'-0" L x 8'-0" W	PERIGOLD	DINING ROOM	WOOL AND SILK BLEND HAND WOVEN
10	AZURE DECORATIVE ACCENT BENCH	3	18" H x 20" W x 35" L	LAKIQ	DINING ROOM/ MASTER BEDROOM	SCANDINAVIAN AZURE BLUE FAUX LEATHER TUFTED
11	FOUR HANDS BUFFET	2	38.25" H x 63" W x 18" L	PERIGOLD	DINING ROOM	BLUE MANUFACTURED DISTRESSED FINISH
12	GINKGO NATURE MASTER BED	1	55.1" H x 124.8" W x 84.6" L	ALMA DE LUCE	MASTER BEDROOM	VELVET BLUE AND WHITE UPHOLSTERY
13	DEVI COW HIDE RUG	2	0.5" H x 84" W x 78" L	POTTERY BARN	MASTER BEDROOM	100% NATURAL HAIR ON HIDE IN WHITE
14	WANSBECK CHEST OF DRAWERS	2	27" H x 47" W x 18" L	FUNKY CHUNKY FURNITURE	MASTER BEDROOM	RUSTIC WALNUT FINISH

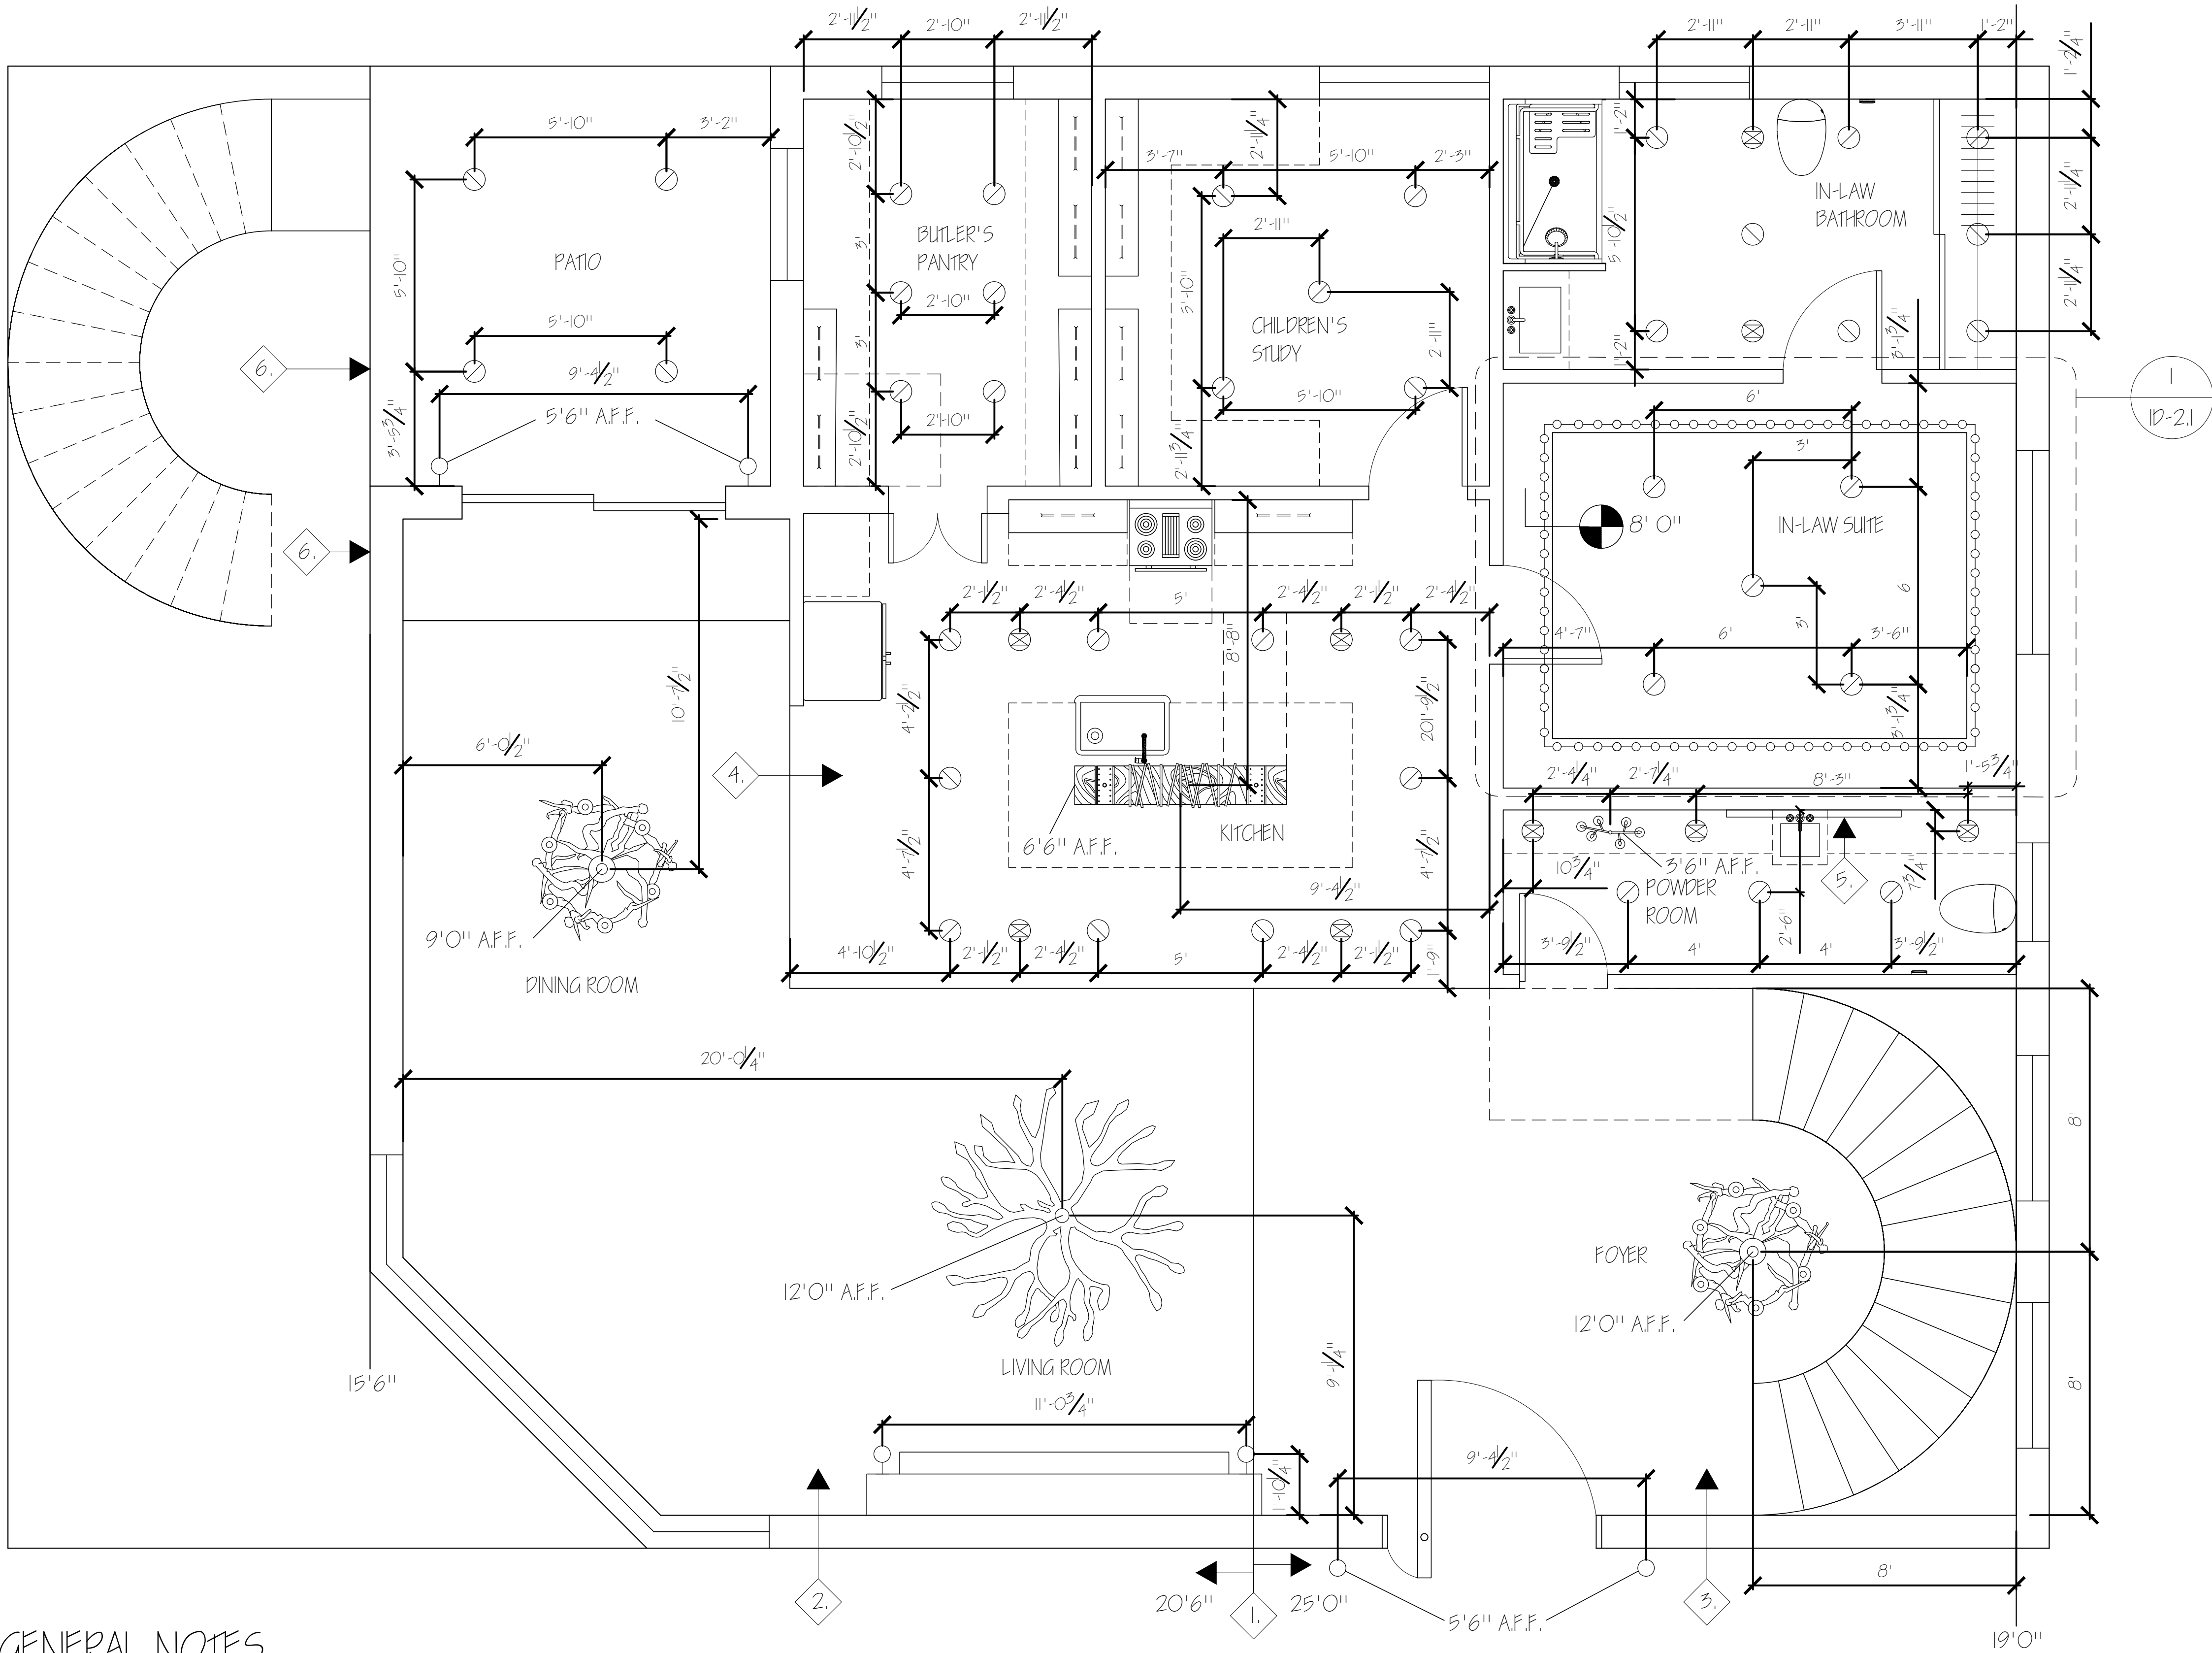


1 1ST FLOOR FINAL RCP
SCALE: 1/4" = 1'-0"

GENERAL NOTES

- ALL DIMENSIONS ARE TO THE CENTERLINE OF FIXTURE, U.N.O.
- REFER TO MANUFACTURER INSTALLATION INSTRUCTIONS FOR LIGHT FIXTURES AND LAMP CONFIGURATIONS.
- ALL CEILING HEIGHTS TO BE 9'-0", U.N.O.
- ALL OUTLETS ARE AT 15" FROM THE FLOOR U.N.O.
- ALL CEILING TO BE DONE IN A WHITE PLASTER FINISH U.N.O.
- ALL UNDER CABINET STRIP LIGHTING PLACED ALONG THE MIDPOINT OF THE DEPTH OF THE TOP CABINETS U.N.O.
- FOR FURTHER DETAILS ON COVE LIGHTING REFER TO 1D-2.1 ENLARGED IN-LAW SUITE RCP.

PLAN NOTES

- THE ROOF VALLEY TO THE LEFT SITS AT 20'6" A.F.F. WHILE THE ROOF VALLEY TO THE RIGHT SITS AT 25'0" A.F.F.
- THE ROOF SLOPES DOWN FROM RIGHT TO LEFT FROM A HEIGHT OF 20'6" A.F.F. TO 15'6" A.F.F.
- THE ROOF SLOPES DOWN FROM LEFT TO RIGHT FROM A HEIGHT OF 25'0" A.F.F. DOWN TO 19'0" A.F.F.
- THE KITCHEN CEILING IS COVERED BY THE SITTING AREA ON THE SECOND FLOOR.
- WALL HUNG MIRROR TO RECEIVE BACK LIGHTING ALL AROUND.
- THIS AREA'S CEILING IS COVERED BY THE GUEST ROOM ON THE SECOND FLOOR.

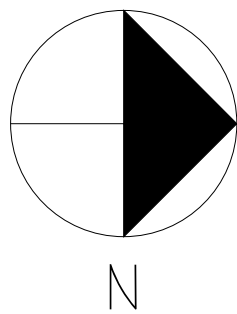

RCP FIXTURE LEGEND	
ITEM	DESCRIPTION
○	6" RECESSED LIGHT
⊞	WALL SCONCE
---	LED UNDER CABINET LIGHT
	LIVING ROOM ANTLER CHANDELIER
	FOYER CHANDELIER
	KITCHEN ISLAND CHANDELIER
	DINING ROOM CHANDELIER
	POWDER ROOM CHANDELIER
—○—○—○—	COVE LIGHTING
⊗	EXHAUST VENT
⬢	LIGHT SWITCH
□	DUPLEX OUTLET
□	GFCI OUTLET
□	220V OUTLET



PROJECT:
RESIDENTIAL COURSE PROJECT
THE ESCOFFIER RESIDENCE

RESIDENTIAL DESIGN
INDS 2313

REVISIONS:

6		
5		
4		
3		
2		
1		

DATE: NOV 5TH, 2024

DRAFTED BY:

ALHAN VAZQUEZ

SHEET CONTENTS:

1ST FLOOR RCP

SHEET:

1D-10.1




INDS 23|3






6		
5		
4		
3		
2		
1		

ALHAN VAZQUEZ

2ND FLOOR RCP

 10-10.2

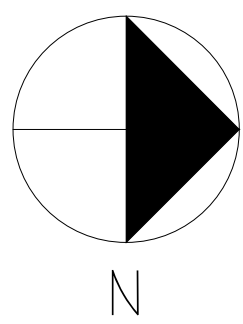

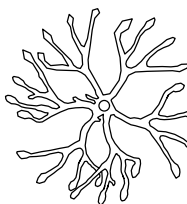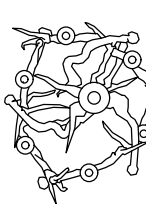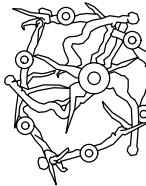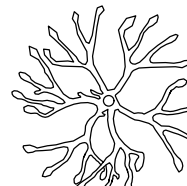
RCP FIXTURE LEGEND	
ITEM	DESCRIPTION
	6" RECESSED LIGHT
	WALL SCONCE
	LED UNDER CABINET LIGHT
	LIVING ROOM ANTLER CHANDELIER
	FOYER CHANDELIER
	KITCHEN ISLAND CHANDELIER
	DINING ROOM CHANDELIER
	POWDER ROOM CHANDELIER
	COVE LIGHTING
	EXHAUST VENT
	BEDROOM CHANDELIER

- ALL DIMENSIONS ARE TO THE CENTERLINE OF FIXTURE, U.N.O
- REFER TO MANUFACTURER INSTALLATION INSTRUCTIONS FOR LIGHT FIXTURES AND LAMP CONFIGURATIONS.
- ALL CEILING HEIGHTS TO BE 9'-0", U.N.O.
- ALL OUTLETS ARE AT 15" FROM THE FLOOR U.N.O.
- ALL CEILING TO BE DONE IN A WHITE PLASTER FINISH U.N.O.



1. THE ROOF VALLEY TO THE LEFT SITS AT 20'6" A.F.F. WHILE THE ROOF VALLEY TO THE RIGHT SITS AT 25'0" A.F.F.
2. THE ROOF SLOPES DOWN FROM RIGHT TO LEFT FROM A HEIGHT OF 20'6" A.F.F. TO 15'6" A.F.F.
3. THE ROOF SLOPES DOWN FROM LEFT TO RIGHT FROM A HEIGHT OF 25'0" A.F.F. DOWN TO 19'0" A.F.F.

4. THE ROOF IN THIS SPACE RISES FROM 8'0" A.F.F. TO 12'0" A.F.F. THEN DROPS BACK TO 9'0" A.F.F.
5. THE ROOF IN THIS SPACE RISES FROM 9'0" A.F.F. TO 12'0" A.F.F. THEN DROPS BACK TO 9'0" A.F.F.
6. THE ROOF VALLEY TO THE LEFT SITS AT 9'0" A.F.F. FROM THE 2ND FLOOR WHILE THE ROOF VALLEY TO THE RIGHT SITS AT 15'0" A.F.F. FROM THE SECOND FLOOR.
7. THE ROOF SLOPES DOWN FROM LEFT TO RIGHT FROM A HEIGHT OF 15'0" A.F.F. DOWN TO 9'0" A.F.F.

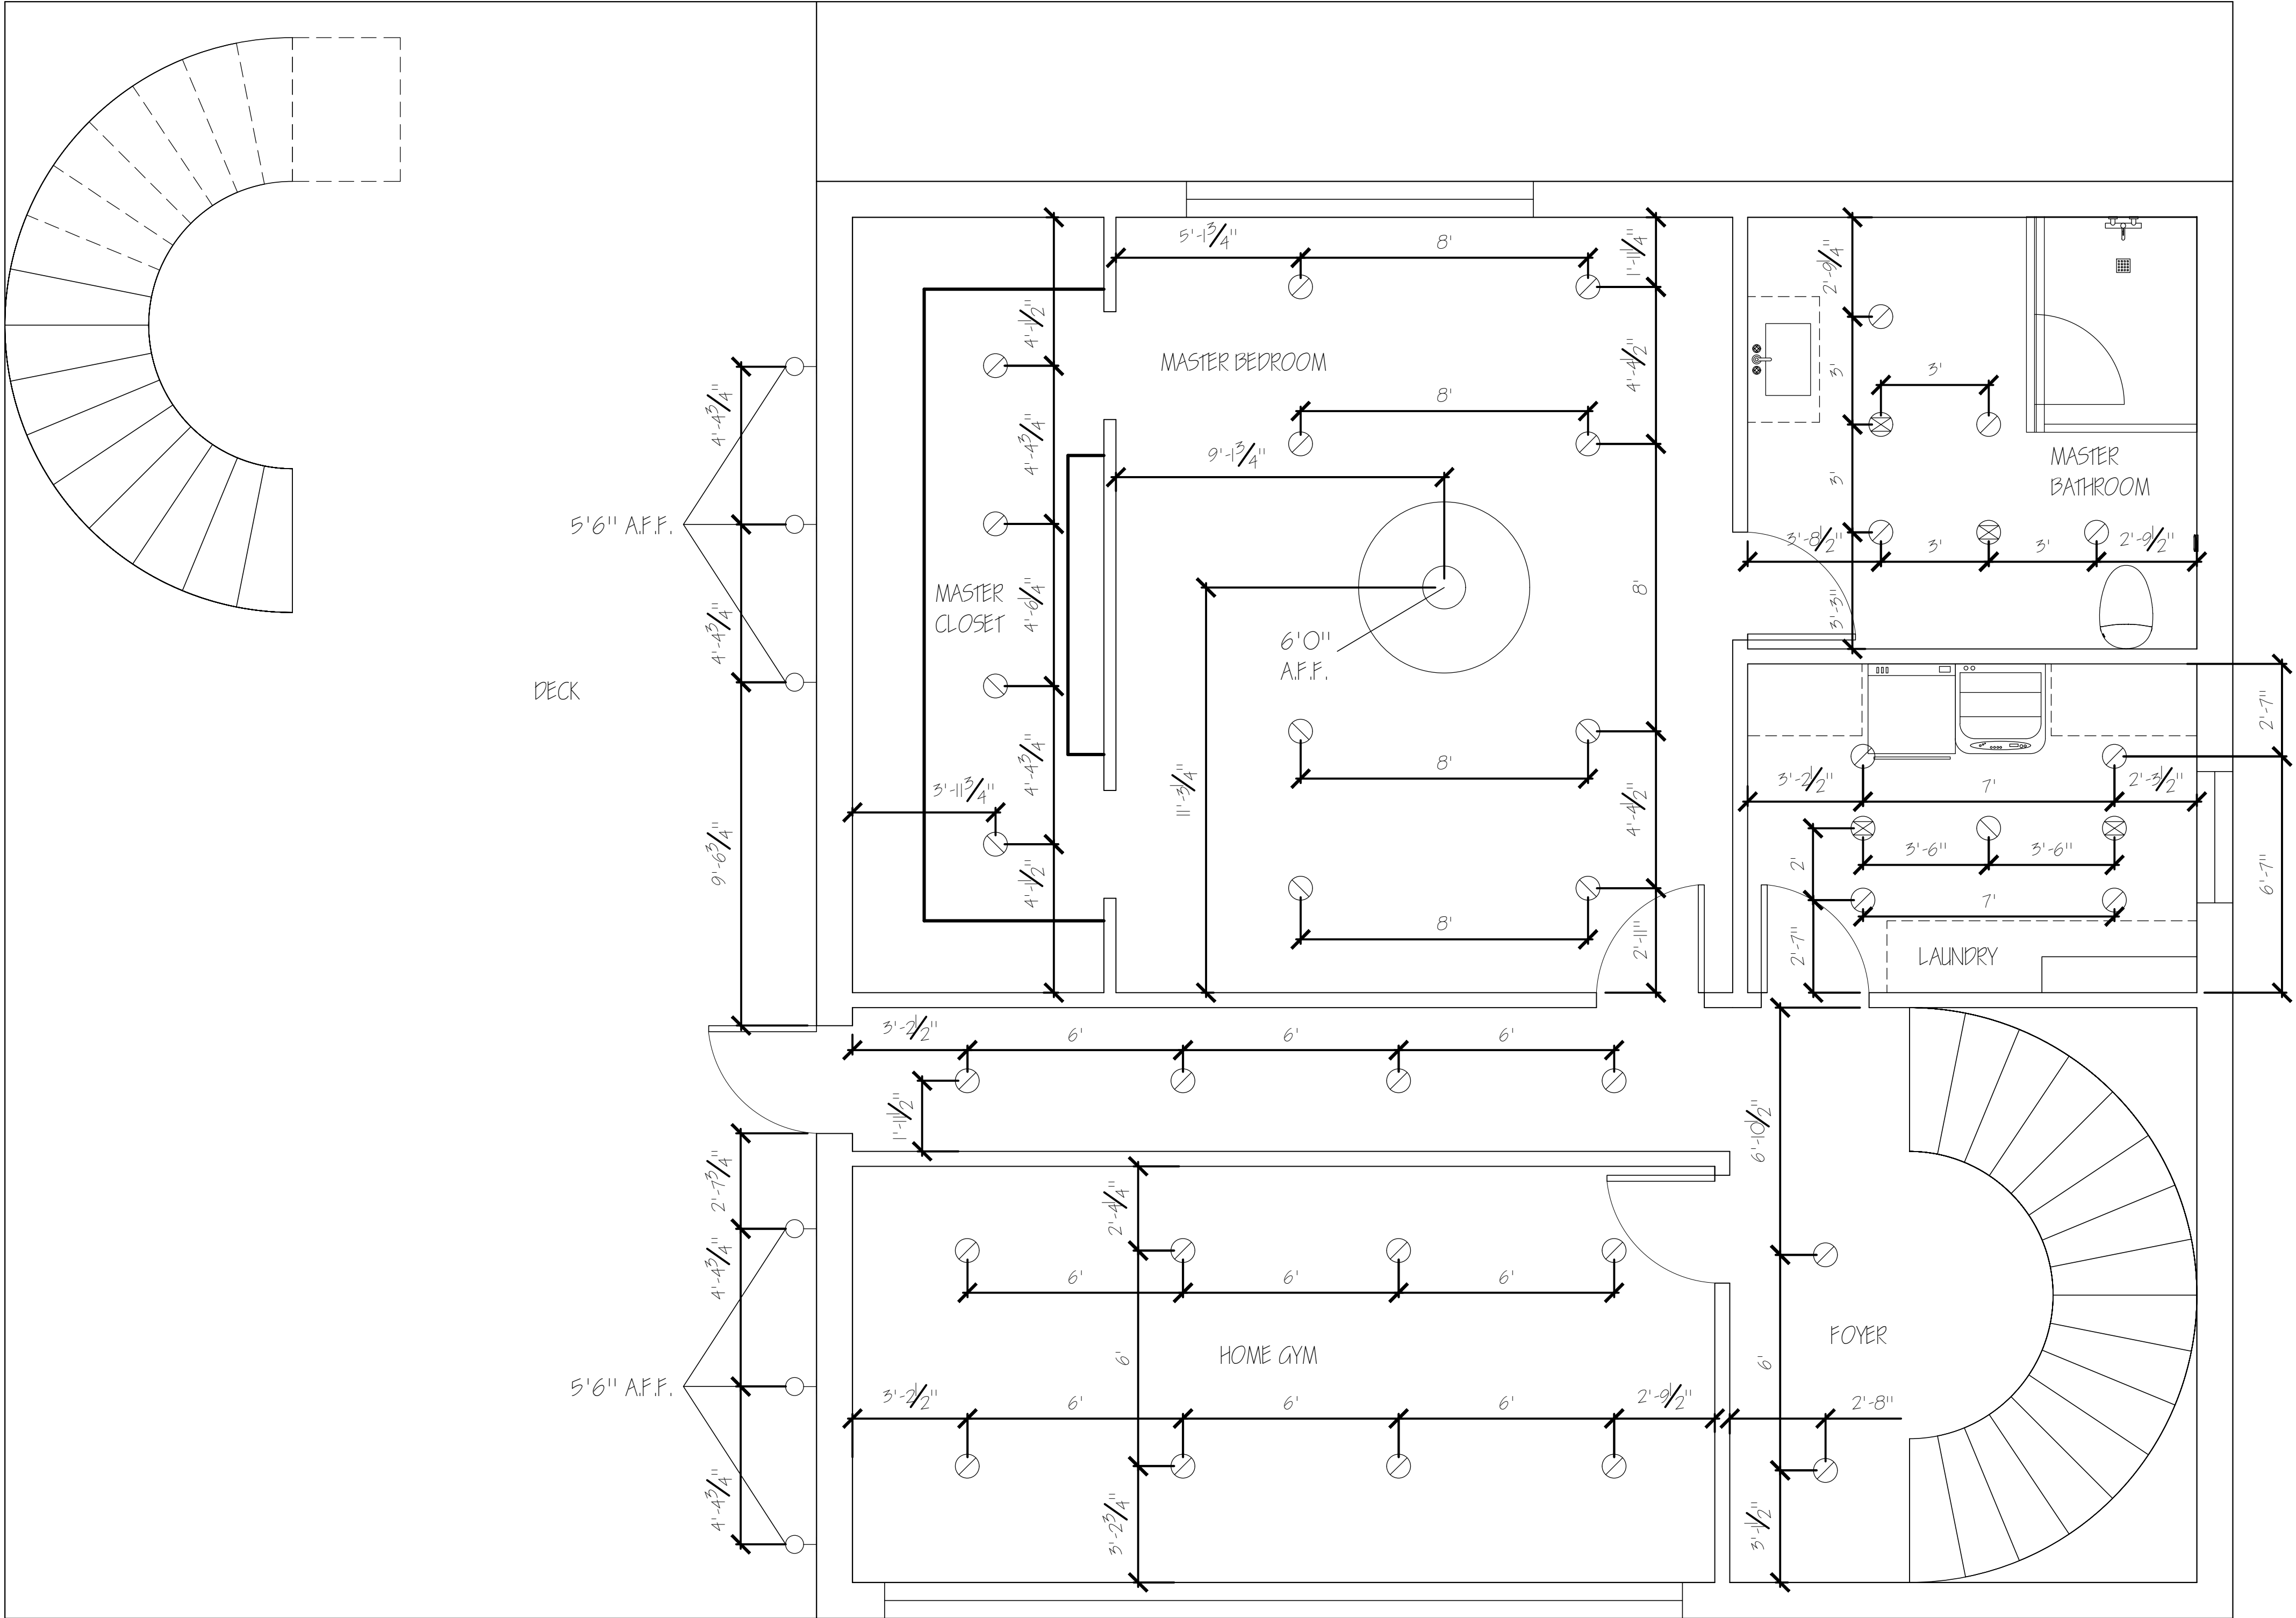


GENERAL NOTES

- ALL DIMENSIONS ARE TO THE CENTERLINE OF FIXTURE, U.N.O.
- REFER TO MANUFACTURER INSTALLATION INSTRUCTIONS FOR LIGHT FIXTURES AND LAMP CONFIGURATIONS.
- ALL CEILING HEIGHTS TO BE 9'-0", U.N.O.
- ALL OUTLETS ARE AT 15" FROM THE FLOOR U.N.O.
- ALL CEILING TO BE DONE IN A WHITE PLASTER FINISH U.N.O.

1 BASEMENT FINAL RCP
SCALE: 1/4" = 1'-0"

RCP FIXTURE LEGEND	
ITEM	DESCRIPTION
	6" RECESSED LIGHT
	WALL SCONCE
	LED UNDER CABINET LIGHT
	LIVING ROOM ANTLER CHANDELIER
	FOYER CHANDELIER
	KITCHEN ISLAND CHANDELIER
	DINING ROOM CHANDELIER
	POWDER ROOM CHANDELIER
	COVE LIGHTING
	EXHAUST VENT
	MASTER BEDROOM CHANDELIER

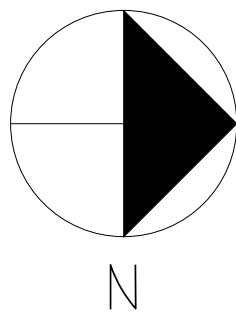

PROJECT:
RESIDENTIAL COURSE PROJECT
THE ESCOFFIER RESIDENCE

RESIDENTIAL DESIGN
INDS 2313

REVISIONS:

6		
5		
4		
3		
2		
1		

DATE: NOV 5TH, 2024

DRAFTED BY:

ALHAN VAZQUEZ

SHEET CONTENTS:

BASEMENT RCP

SHEET:

ID-10.3